

- A -		- F CONTINUED -	
AA	AMP	FIN	FINISH(ED)
AA	ART & ACCESSORIES	FIXT	FIXTURE
AB	ANCHOR BOLT	FLASH	FLASHING
AC	AIR CONDITIONING	FLR	FLOOR
ACST	ACOUSTIC(AL)	FMF	FLEXIBLE MEMBRANE FLASHING
ACT	ACOUSTIC CEILING TILE	FOB	FACE OF BRICK
AD	AREA DRAIN	FOC	FACE OF CONCRETE
ADJ	ADJACENT	FOF	FACE OF FINISH
	ADJUSTABLE	FCM	FACE OF MASONRY
AFF	ABOVE FLOOR FINISH	FOS	FACE OF STUD
AHU	AIR HANDLING UNIT	FP	FIRE PLACE
ALT	ALTERNATE	FRP	FIBER REINFORCED PANELS
ALUM	ALUMINUM	FRTW	FIRE RETARDANT TREATED WOOD
AP	ACCESS PANEL	FRZ	FREEZER
APPROX	APPROXIMATELY	FS	FULL SIZE
ARCH	ARCHITECT(URAL)	FCG	FURNITURE-CASEGOODS
ASPH	ASPHALT	FTG	FURNITURE-SOFTGOODS
AUTO	AUTOMATIC	FT	FOOT
AUX	AUXILIARY		FEET
AV	AUDIO VISUAL	FTG	FOOTING

<u>-B-</u>		<u>-G-</u>	
BATH	BATHROOM	G	GROUND
BD	BOARD	GA	GAUGE
BED	BEDROOM	GALV	GALVANIZED
BLDG	BUILDING	GAR	GARAGE
BLKG	BLOCKING	GB	GRAB BAR
BM	BEAM	GC	GENERAL CONTRACTOR
BO	BOTTOM OF	GEN	GENERAL
BOB	BOTTOM OF BEAM	GFRG	GLASS FIBER REINFORCED GYPSUM
BOD	BOTTOM OF DECK	GI	GALVANIZED IRON
BOJ	BOTTOM OF FRAMING	GL	GLASS
BTW	BETWEEN	GLAZ	GLAZING
BUR	BUILT UP ROOF(ING)	GLF	GLAZING FILM

-- C --		GT	GROUT
CAB	CABINET	GWB	GYPSUM WALL BOARD
CALC	CALCULATION	GYP	GYPSUM SHEATHING
CB	CATCH BASIN, CORNER BEAD		

CEM	CEMENT	<u>- H -</u>	
CFOI	CONTRACTOR FURNISHED & OWNER INSTALLED	H	HEIGHT,
CIP	CAST IN PLACE	HB	HIGH
CJ	CONTROL JOINT,	HC	HOSE BIB
	CONSTRUCTION JOINT	HDR	HOLLOW CORE
CL	CENTERLINE	HDR	HEADER
CLG	CEILING	HDW	HARDWARE
CLO	CLOSE	HDWD	HARDWOOD
CLR	CLEAR	HGR	HANGER
CMU	CONCRETE MASONRY UNIT	HM	HOLLOW METAL
CO	CLEAN OUT	HRL	HANDRAIL
COL	COLUMN	HORIZ	HORIZONTAL
CONC	CONCRETE	HR	HOUR(S)
CONF	CONFERENCE	HVAC	HEATING, VENTILATION & AIR CONDITIONING
CONN	CONNECTION(ION)	HW	HOT WATER
CONSTR	CONSTRUCTION	HWT	HOT WATER TANK
CONT	CONTINUE,		

COORD	CONTINUOUS	<u>1-</u>	
CORR	COORDINATE	<u>1-</u>	
	CORRIDOR	INC	IMPACT INSULATION CLASS
CPT	CEMENT PLASTER	INC	INCH(ES)
CS	CARPET	INC	INCREASE
CP	CONCRETE SEALER	INCL	INCLUDE(ED)
CSMT	CASEMENT	INCL	INCLUDING
CTR	CENTER	INFO	INFORMATION
CW	COLD WATER	INSTL	INSTALL(ATION)
		INSUL	INSULATION
		INT	INTERIOR

<u>-D-</u>			
D	DEEP,		
	DRYER		
DBL	DOUBLE	<u>-J-</u>	
DEMO	DEMOLISHED),	JAN	JANITOR
	DEMOLITION	JBOX	JUNCTION BOX
	DEPARTMENT	JST	JOIST
DEPT	DEPT	JT	JOINT
DET	DETAIL		
DF	DRINKING FOUNTAIN		
DIA	DIAMETER		
DIM	DIMENSION	<u>-K-</u>	
DISP	DISPOSAL	KD	KILN DRIED
DL	DEAD LOAD	KIT	KITCHEN
DN	DOWN	KP	KICK PLATE
DP	DECORATIVE PANEL	KW	KILOWATT
DR	DOOR,		

DS	DINING ROOM, DRAIN	<u>-L-</u> L	LEFT,
DW	DOWNSPOUT		LENGTH,
DWG	DISHWASHER		LINEN,
DWR	DRAWING(S)		LONG
	DRAWER	LAB	LABORATORY

-E--		LAV	LAVATORY
(E)	EXISTING	LB(S)	POUND(S)
E	EAST	LD	LIGHTING-DECORATIVE
EA	EACH	LDG	LANDING
EC	EDGE OF CURB	LF	LIGHT FOOT
EES	EACH END	LL	LIVE LOAD
EIFS	EXTERIOR INSULATION & FINISH SYSTEM	LOC	LOCATION
EF	EACH FACE	LPT	LIGHTING PORTABLE
EJ	EXPANSION JOINT	LP	LOW POINT
EL	ELEVATION	LR	LIVING ROOM
ELEC	ELECTRICAL	LRG	LARGE
ELV	ELEVATOR	LT	LIGHTING(S)
EMER	EMERGENCY	LVR	LOUVER
ENCL	ENCLOSE(D), ENCLOSURE		
EP	ELECTRICAL PANELBOARD	-M--	
EQ	EQUAL	MACH	MACHINE
EQP	EQUIPMENT	MAINT	MAINTENANCE
EST	ESTIMATE(D)	MATL	MATERIAL
EW	EACH WAY	MAX	MAXIMUM
EWG	ELECTRIC WATER COOLER	MB	MACHINE BOLT
EWH	ELECTRIC WATER HEATER	MBR	MASTER BEDROOM
EXH	EXHAUST	MC	MEDICINE CABINET
EXP	EXPOSED, EXPANSION	MDD	MEDIUM DENSITY OVERLAY
		MECH	MECHANICAL
EXT	EXTERIOR	MED	MEDIUM

-F -		MEMB	MEMBRANE
FA	FIRE ALARM	MEZZ	MEZZANINE
FAAP	FIRE ALARM ANNUNCIATOR PANEL	MFR	MANUFACTURER
FD	FLOOR DRAIN	MANUFRRREC	MANUFACTURER'S RECOMMENDATION(S)
FDC	FIRE DEPARTMENT CONNECTION	MGR	MANAGER
FDN	FOUNDATION	MH	MANHOLE
FDV	FIRE DEPARTMENT VALVE	MIN	MINIMUM
FE	FIRE EXTINGUISHER	MIR	MIRROR
FEC	FIRE EXTINGUISHER CABINET	MISC	MISCELLANEOUS
FF	FACTORY FINISH	MO	MASONRY OPENING
	FINISH FINISH		MONITOR
FH	FIRE HYDRANT	M/S	MIRROR & SHELF
FHC	FIRE HOSE CABINET	MTD	MOUNTED
FHR	FIRE HOSE REEL		
	FIRE HOSE REEL		

<u>- M CONTINUED -</u>		<u>- S CONTINUED -</u>	
MTL	METAL	SOL	SOLID SURFACE
MUL	MULLION	STO	STONE
MULT	MULTIPLE	SPEC	SPECIFICATION(S)
MW	MICROWAVE OVEN	SPKLR	SPRINKLER
		SPKR	SPEAKER
		SQ	SQUARE
<u>- N -</u>		SQIN	SQUARE INCH
NA	NORTH	SS	SERVICE SINK
NE	NORTH EAST	SST	SANITARY SEWER
NC	NOISE CRITERIA,	ST	STAINLESS STEEL
	NURSE CALL	ST	STREET,
NCAP	NURSE CALL ANNUNCIATOR PANEL	STC	STAIN
NIC	NOT IN CONTRACT	STD	STANDARD TRANSMISSION CLASS
NO	NUMBER	STD	STANDARD
NOM	NOMINAL	STL	STEEL
NTS	NOT TO SCALE	STOR	STORAGE
NTS	NORTHWEST	STRUCT	STRUCTURAL
NW		SUBE1	SOILED UTILITY
		SUBE1	SUBE1

0 →		SW	SOUTHWEST,
O	OVER		SWITCH
OA	OVERALL		
OC	ON CENTER	SYM	SYMMETRICAL
OCC	OCCUPANTS,		
	OCCUPANT LOAD,	→ T →	TREAD,
	OCCUPANCY		TILE
OD	OUTSIDE DIAMETER		
OFCl	OWNER FURNISHED & CONTRACTOR INSTALLED	T&B	TOP AND BOTTOM
OFoI	OWNER FURNISHED & OWNER INSTALLED	TEL	TELEPHONE
OFD	OVERFLOW DRAIN	TEMP	TEMPORARY,
OFF	OFFICE		TEMPERATURE
OGL	OBSCURE GLASS	TER	TERRAZZO
OH	OVERHEAD	THK	THICK(NESS)
OPH	OPPOSITE HAND	THRU	THROUGH
OPNG	OPENING	TI	TENANT IMPROVEMENT
OPP	OPPOSITE	TL	TOTAL LOAD
ORD	OVERFLOW ROOF DRAIN	TMPD	TEMPERED

- P --				TOB	TOP OF BEAM
P	PAINT(ED), PANTRY			TOC	TOP OF CURB, TOP OF CONCRETE
PC	PORTLAND CEMENT			TOF	TOP OF FOOTING, TOP OF FLOOR,
PCC	PRECAST CONCRETE				TOP OF FRAME
PED	PEDESTAL				TOP OF SLAB.
PERF	PERFORATED		TOS		TOP OF STEEL
PERM	PERMANENT				TOP OF WALL
PERP	PERPENDICULAR		TOW		TRANSITION STRIP
PF	PLUMBING FIXTURE		TR		TS
PER	PREPARED FOR PAINT		TS		TELEVISION
PIV	POST INDICATOR VALVE		TV		TEXTILES
PL	PLATE.		TX		TYP
	PROPERTY LINE		TYP		

PLY	PLYWOOD	<u>-U-</u>	
PMTL	PAINTED METAL	UC	UNDERCOUNTER,
PNT	POINT		UNDERCABINET,
PP	POWER POLE		UNDERCUT
PR	PAIR		
PRFAB	PREFABRICATE	UGO	UNDERGROUND
PRELIM	PRELIMINARY	UNO	UNLESS NOTED OTHERWISE
PRKG	PARKING	UP	UTILITY POLE
PROP	PROPERTY	UTIL	UTILITY
PS	PROJECTOR SCREEN		
PSF	POUNDS PER SQUARE FOOT	<u>-V-</u>	
PSI	POUNDS PER SQUARE INCH	V	VOLT(AGE)
PT	PRESERVATIVE TREATED,	V	VENTILATE,
	PRESSURE TREATED,		VENTILATION
	POST TENSIONED	VERT	VERTICAL
PTN	PARTITION	VEST	VESTIBULE
PVC	POLYVINYL CHLORIDE,	VIF	VERIFY IN FIELD
	POLYVINYL CHLORIDE PIPE	VTO	VENT TO OUTSIDE
PVD	PROVIDE	VTR	VENT THROUGH ROOF
PVC	PAVING		
PVMT	PAVEMENT		
PVR	PAVERS	<u>-W-</u>	
PWR	POWER	W	WASHING MACHINE,

Q			WIDE,
QTY	QUANTITY	W/	WIDTH
QTZ	QUARTZ	W/D	WITH
		W/O	WASHER & DRYER
			WITHOUT

RA	RISER	WCO	WALL COVERING
RA	RADIUS	WCO	WINDOW COVERING
RA	RESTROOM ACCESSORY	WDO	WOOD
ROP	REFLECTED CEILING PLAN	WDP	WALL/DOR PROTECTION
RO	ROOF DRAIN	WF	WIDE FLANGE
REBAR	REINFORCING BAR	WH	WATER HEATER
REC	RECESSED	WIC	WALK-IN CLOSET
REF	REFERENCE	WIN	WINDOW
	REFRIGERATOR	WM	WIRE MOLD
REINF	REINFORCE(D)	WM	WATER METER
	REINFORCING		WIRE MESH
RES	RESILIENT	WO	WALK-OFF FLOORING
REQD	REQUIRED	WP	WORK POINT
RET	RETAINING		WATERPROOFING
REV	REVISED		WEATHERPROOF
	REVISION	WPM	WATERPROOF MEMBRANE
RF	RAISED FLOOR(ING)	WR	WATER REPELLENT
RM	ROOM		WATER RESISTANT
RO	ROUGH OPENING	WRB	WATER RESISTANT BARRIER
ROW	RIGHT OF WAY	WSCST	WAINSCOT
RP	RADIUS POINT	WT	WEIGHT
R/S	ROD & SHELF	WWF	WELDED WIRE FABRIC
RS	ROUGH SAWN		
RT	RIGHT		
RVL	REVEAL	-Y-	

- S -	
S	SOUTH, SINK
SAN	SANITARY
SC	SOLID CORE
SCD	SEAT COVER DISPENSER
SCHED	SCHEDULE
SD	STORM DRAIN
SE	SOUTHEAST
SEAL	SEALER, SEALANT
SECT	SECTION
SEP	SEPARATION
SF	SQUARE FEET
SG	SAFETY GLASS, SAFETY GLAZING
SHR	SHOWER
SHTG	SHEATHING, SHEETING
SHLV	SHELVING
SIM	SIMILAR
SM	SHEET METAL
SOG	SLAB ON GRADE

VIEW REFERENCE

BUILDING SECTION

**WALL SECTION
PARTIAL BUILDING
SECTION**

DETAIL SECTION

**EXTERIOR
ELEVATION**

**INTERIOR
ELEVATION**

**ENLARGED PLAN,
DETAIL PLAN**

BREAK LINE

**LEVEL 1
0'-0"**

 
GRAPHIC SCALE

GRID LINE

NORTH ARROW

**REVISION CLOUD
W/ TAG**

SPOT ELEVATION

<u>—LINE STYLES—</u>			
---	BUILDING SETBACK LINE		EXISTING ELEMENT TO REMAIN
- - -	CENTERLINE		DEMOLITION ELEMENT
.....	CLEARANCE		
.....	ELEMENT BEYOND		
---	HIDDEN ELEMENT		NEW CONSTRUCTION ELEMENT
<u>MATCH LINE</u>			
SEE 1/A00.01	MATCH LINE		
---	OVERHEAD ELEMENT		
---	PROPERTY LINE		ALUMINUM
		<u>--MATERIAL SYMBOLS & PATTERNS--</u>	





~TAGS~			
CEILING HEIGHT	CEILING TAG		BLOCKING, SHIM
100A	DOOR TAG, CASED OPENING TAG		BRICK (PLAN VIEW)
FIN-1	FINISH MATERIAL TAG		CONCRETE
F1	FLOOR TAG		CMU (PLAN VIEW)
EQP-1	FURNITURE, FIXTURE, EQUIPMENT TAG		CONTINUOUS WOOD FRAMING
GL-1	GLAZING TAG		EARTH BELOW GRADE
01	KEYNOTE		GLASS (SECTION VIEW)
R1	ROOF TAG		GRAVEL
ROOM NAME 100	ROOM TAG		GYPSUM WALL BOARD, GYPSUM SHEATHING
S1	STOREFRONT TAG		OUT OF PROJECT SCOPE
01A	WALL TAG		PLYWOOD
W1	WINDOW TAG		RIGID INSULATION
			STEEL
			WOOD

DRAWINGS HAVE BEEN PREPARED ON AN ORIGINAL SHEET SIZE OF 24" X 36".
OPENING FORCE FOR INTERIOR SIDE-SWINGING DOORS WITHOUT CLOSERS SHALL NOT EXCEED A 5 POUND FORCE. FOR OTHER SIDE-SWINGING, SLIDING AND FOLDING DOORS, DOOR LATCH SHALL RELEASE WHEN SUBJECTED TO A 15 POUND FORCE APPLIED TO THE LATCH SIDE.
DRAWINGS ARE THE PROPERTY OF RICE FERGUS MILLER AND HAVE BEEN PREPARED FOR THE USE IN THE EXECUTION OF THE ENCLOSED PROJECT. USE OR REPRODUCTION FOR AN OTHER PURPOSE WITHOUT THE WRITTEN PERMISSION OF RICE FERGUS MILLER IS PROHIBITED.


COMPLY WITH CODES, LAWS, ORDINANCES, RULES, AND REGULATIONS OF PUBLIC AUTHORITIES GOVERNING THE WORK. REPORT VARIATIONS, VERY DIMENSIONS AND FIELD CONDITIONS AND CONFIRM THAT WORK IS BUILDABLE AS SHOWN. REPORT ANY CONFLICTS OR OMISSIONS TO THE ARCHITECT AND OWNER FOR CLARIFICATION PRIOR TO BIDDING OR WORKING. SUBMIT REQUESTS FOR SUBSTITUTIONS, REVISIONS, OR CHANGES TO ARCHITECT AND OWNER FOR REVIEW PRIOR TO PURCHASE, FABRICATION OR INSTALLATION. SEE PROJECT SPECIFICATIONS. OWNER WILL PROVIDE WORK NOTED BY "OTHERS" OR "NIC" UNDER SEPARATE CONTRACT. INCLUDE SCHEDULE REQUIREMENTS IN CONSTRUCTION PROGRAM SCHEDULE AND COORDINATE TO ASSURE ORDERLY SEQUENCE OF INSTALLATION. GO TO COORDINATE FURNITURE, SIGNAGE, GRAPHICS, TELECOMMUNICATIONS, DATA AND SECURITY SYSTEM INSTALLATIONS WITH ARCHITECT, OWNER, AND OWNER'S VENDORS TYPICAL. NOTIFY OWNER AND ARCHITECT OF COORDINATION ISSUES PRIOR TO FABRICATION AND INSTALLATION. MAINTAIN WORK AREAS SECURE AND LOCKABLE DURING CONSTRUCTION. COORDINATE WITH TENANT AND LANDLORD TO ENSURE SECURITY. COORDINATE WITH SCALE DRAWINGS. THE WRITTEN DIMENSIONS GOVERN. IN THE CASE OF A CONFLICT, NOTIFY THE ARCHITECT FOR CLARIFICATION. PARTITIONS ARE DIMENSIONED FROM FACE OF STUD TO FACE OF STUD, UNLESS OTHERWISE NOTED. MAINTAIN DIMENSIONS MARKED "CLEAR" ALLOW FOR THICKNESS OF FINISHES. COORDINATE AND PROVIDE BACKING FOR MILLWORK AND EQUIPMENT ITEMS AS ATTACHED, MOUNTED OR BRACED TO WALLS OR CEILINGS. DOORS SHALL BE TRIMMED AT THRESHOLD TO PROVIDE: 1/4" MIN., 3/4" MAX. CLEARANCE (U.O.N.) ABOVE FLOOR FINISH MATERIAL, TO ALLOW FOR FULL DOOR SWING.

A00.01	PROJECT INFORMATION, VICINITY MAP, PROJECT DESIGN TEAM
A00.02	DRAWING INDEX, GENERAL INFORMATION
CIVIL	
C00.10	GENERAL NOTES
C10.00	DEMO AND TESC PLAN
C10.10	TESC DETAILS
C20.00	GRADING AND DRAINAGE PLAN
C20.10	DRAINAGE DETAILS
C30.00	UTILITY PLAN
C30.20	UTILITY PROFILES
C40.00	PAVING PLANS
C40.10	PAVING DETAILS
LANDSCAPE	
L1.00	LANDSCAPE PLAN
L1.01	DETAILS
L1.02	PLANT IMAGES
L2.00	IRRIGATION PLAN
L2.01	IRRIGATION SCHEDULES
L2.02	WATER BUDGET CALCULATOR
L2.03	IRRIGATION DETAILS
L2.04	IRRIGATION DETAILS
ARCHITECTURAL	
A00.03	CODE SUMMARY
A00.04	ENERGY CALCULATIONS
A00.05	ENERGY CALCULATIONS
A00.06	ENERGY CALCULATIONS
A01.01	LIFE SAFETY PLANS
A02.01	AIR BARRIER
A03.01	ASSEMBLY TYPES
A04.01	ACCESSIBILITY GUIDELINES - BUILDING ELEMENTS
A04.02	ACCESSIBILITY GUIDELINES - SITE
A11.01	SITE PLAN
A12.01	SITE DETAILS
A12.02	SITE DETAILS
A22.01	FLOOR PLAN - LEVEL 1
A22.02	FLOOR PLAN - LEVEL 2
A23.01	FINISH PLAN - LEVEL 1, FINISH SCHEDULES
A23.02	FINISH PLAN - LEVEL 2, FINISH SCHEDULES
A24.01	REFLECTED CEILING PLAN - LEVEL 1
A24.02	REFLECTED CEILING PLAN - LEVEL 2
A25.01	ROOF PLAN
A26.00	UNIT EQUIPMENT SCHEDULE
A26.01	TYPICAL 1-BEDROOM UNIT PLANS - ICC A117.1 TYPE B
A26.02	TYPICAL 1-BEDROOM UNIT PLANS - ICC A117.1 TYPE B
A26.03	2-BEDROOM UNIT PLANS - ICC A117.1 TYPE B
A26.04	2-BEDROOM UNIT PLANS - ICC A117.1 TYPE A
A26.05	2-BEDROOM UNIT PLANS - ICC A117.1 TYPE A
A29.01	ENLARGED OVERHANG PLANS
A31.01	EXTERIOR ELEVATIONS
A31.02	EXTERIOR ELEVATIONS
A31.03	EXTERIOR PERSPECTIVES
A32.01	BUILDING SECTIONS
A33.01	WALL SECTIONS
A33.02	WALL SECTIONS
A34.01	INTERIOR ELEVATIONS
A40.01	STAIR PLANS & DETAILS
A40.02	STAIR PLANS & DETAILS
A40.03	VERTICAL CIRCULATION DETAILS
A50.01	EXTERIOR DETAILS
A50.02	EXTERIOR DETAILS
A51.01	EXTERIOR DETAILS
A51.02	EXTERIOR DETAILS
A51.03	EXTERIOR DETAILS
A51.04	EXTERIOR DETAILS
A60.01	DOOR SCHEDULE, DOOR & FRAME TYPES, DOOR DETAILS
A60.02	INTERIOR DOOR DETAILS
A61.01	WINDOW SCHEDULE, WINDOW TYPES, WINDOW DETAILS
A70.01	INTERIOR DETAILS
A71.01	INTERIOR SECTION DETAILS
A72.01	CEILING DETAILS
STRUCTURAL	
S00.00	COVER SHEET
S11.00	GENERAL STRUCTURAL NOTES
S11.01	GENERAL STRUCTURAL NOTES
S11.02	GENERAL STRUCTURAL NOTES
S22.01	FOUNDATION PLAN
S22.02	FLOOR FRAMING PLAN - LEVEL 2
S22.03	ROOF FRAMING PLAN
S30.00	TYPICAL CONCRETE DETAILS
S30.01	FOUNDATION DETAILS
S66.00	TYPICAL WOOD DETAILS
S66.01	WOOD STAIR DETAILS
S66.02	WOOD FLOOR FRAMING DETAILS
S66.03	WOOD ROOF FRAMING DETAILS
S66.04	WOOD SHEAR WALL DETAILS
S66.05	STRAP AND HOLD-DOWN DETAILS
S66.06	CANOPY DETAILS
MECHANICAL	
M0.01	MECHANICAL LEGENDS AND ABBREVIATIONS
M0.02	DUCT MATERIALS
M0.03	GRD AND DUCTWORK ACCESSORIES
M0.04	MECHANICAL SCHEDULES
M0.05	MECHANICAL SCHEDULES
M0.06	MECHANICAL SPECIFICATIONS
M0.07	MECHANICAL BASIS OF DESIGN
M0.08	MECHANICAL CALCULATIONS
M0.09	MECHANICAL CALCULATIONS
M22.01	MECHANICAL PLAN - LEVEL 1
M22.02	MECHANICAL PLAN - LEVEL 2
M25.01	MECHANICAL PLAN - ROOF
M50.01	MECHANICAL DETAILS
PLUMBING	
P0.01	PLUMBING LEGEND AND ABBREVIATIONS
P0.02	PLUMBING CALCS
P0.03	PLUMBING NOTES & MATRICES
P0.04	PLUMBING NOTES & MATRICES
P0.05	PLUMBING EQUIPMENT SCHEDULE
P0.06	PLUMBING FIXTURE SCHEDULE
P11.01	PLUMBING SITE PLAN
P22.00	PLUMBING PLAN - BELOW GRADE
P22.01	PLUMBING PLAN - LEVEL 1




P22.02	PLUMBING PLAN - LEVEL 2
P25.01	PLUMBING PLAN - ROOF
P50.01	PLUMBING DETAILS
P50.02	PLUMBING DETAILS
P50.03	PLUMBING DETAILS
P60.01	PLUMBING DOMESTIC WATER RISER
P60.02	PLUMBING WASTE & VENT RISER
P60.03	PLUMBING WASTE & VENT RISER
ELECTRICAL	
E0.01	ELECTRICAL LEGEND & ABBREVIATIONS
E0.10	POWER RISER
E0.11	TELCOM AND GROUNDING RISERS
E0.12	ELECTRICAL LOAD CALCULATIONS
E0.13	PANEL SCHEDULES
E0.14	PANEL SCHEDULES
E0.15	PANEL SCHEDULES
E0.20	LUMINAIRE SCHEDULE
E0.30	CONTROL SEQUENCE OF OPERATIONS
E0.40	WSEC 2021 ENERGY CODE FORMS
E11.01	ELECTRICAL SITE PLAN
E22.01	P & LV PLAN - LEVEL 1
E22.02	P & LV PLAN - LEVEL 2
E25.01	P & LV PLAN - ROOF
E31.01	LIGHTING SITE PLAN
E32.01	LIGHTING PLAN - LEVEL 1
E32.02	LIGHTING PLAN - LEVEL 2
E36.01	ELECTRICAL DETAILS
E46.00	ENLARGED ELECTRICAL PLANS
E46.01	ENLARGED UNIT PLANS
E46.02	ENLARGED UNIT PLANS
TOTAL NUMBER OF SHEETS: 134	

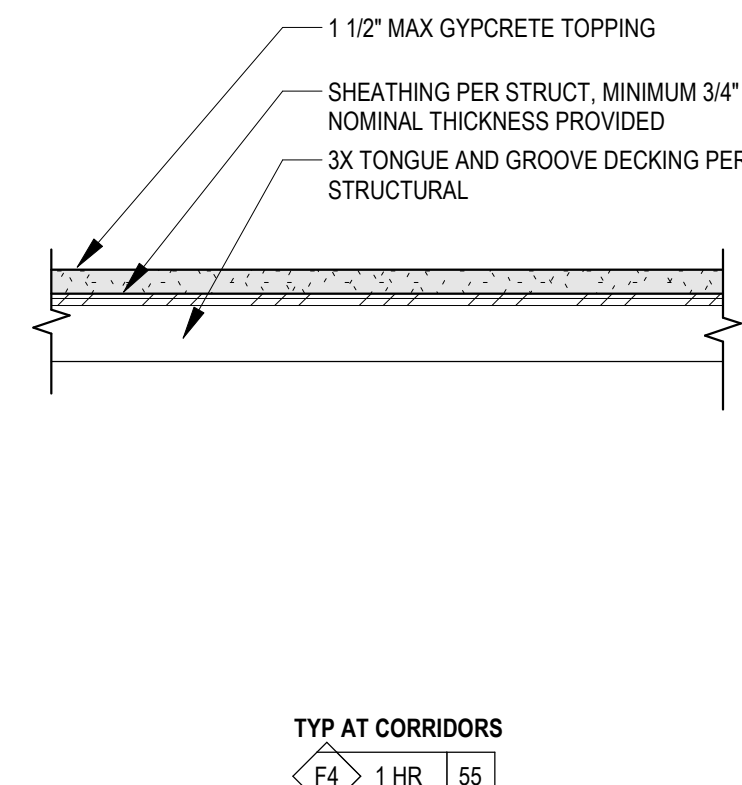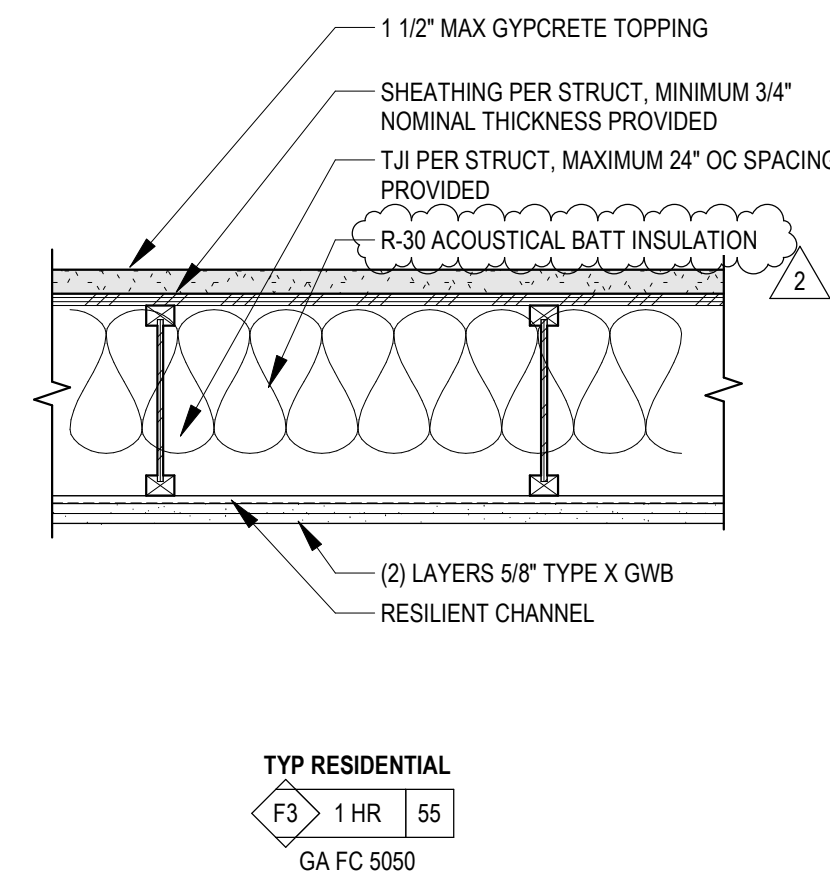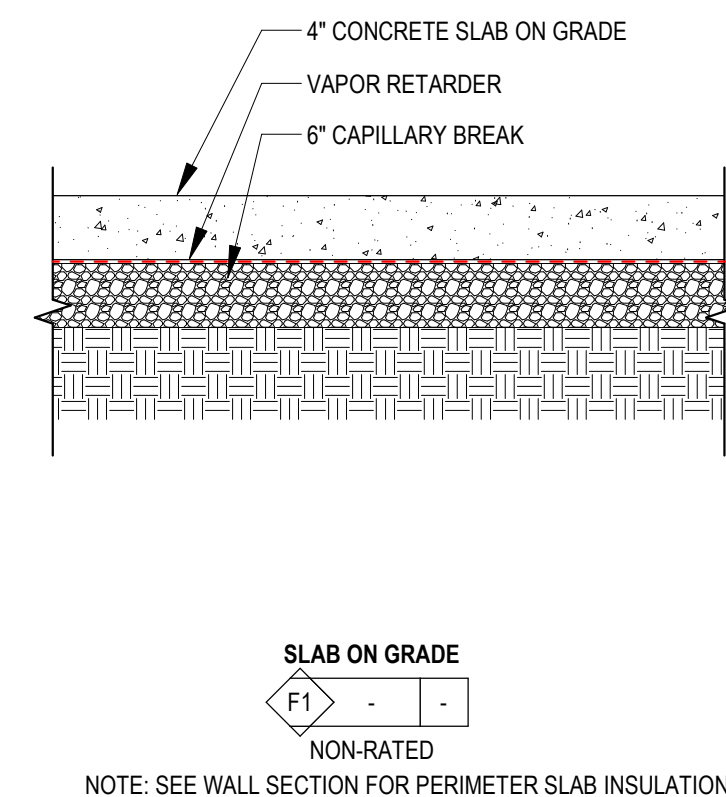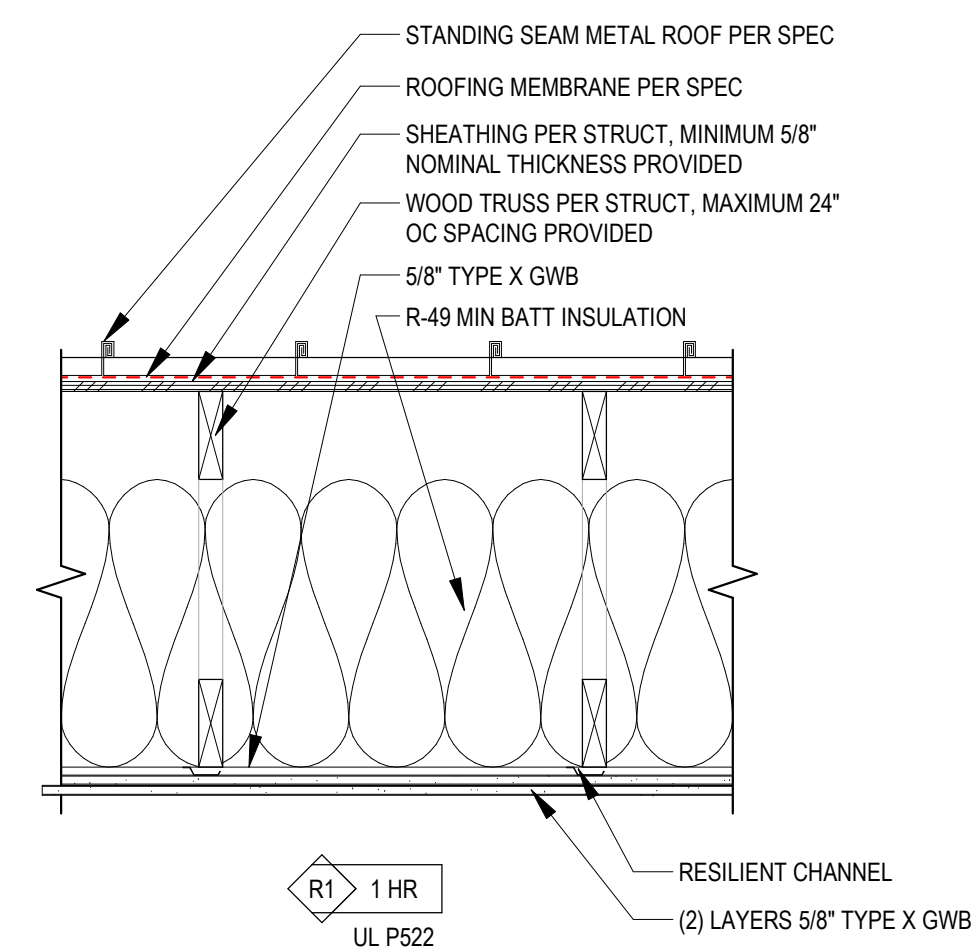

NOTES & LEGEND - ASSEMBLY TYPES





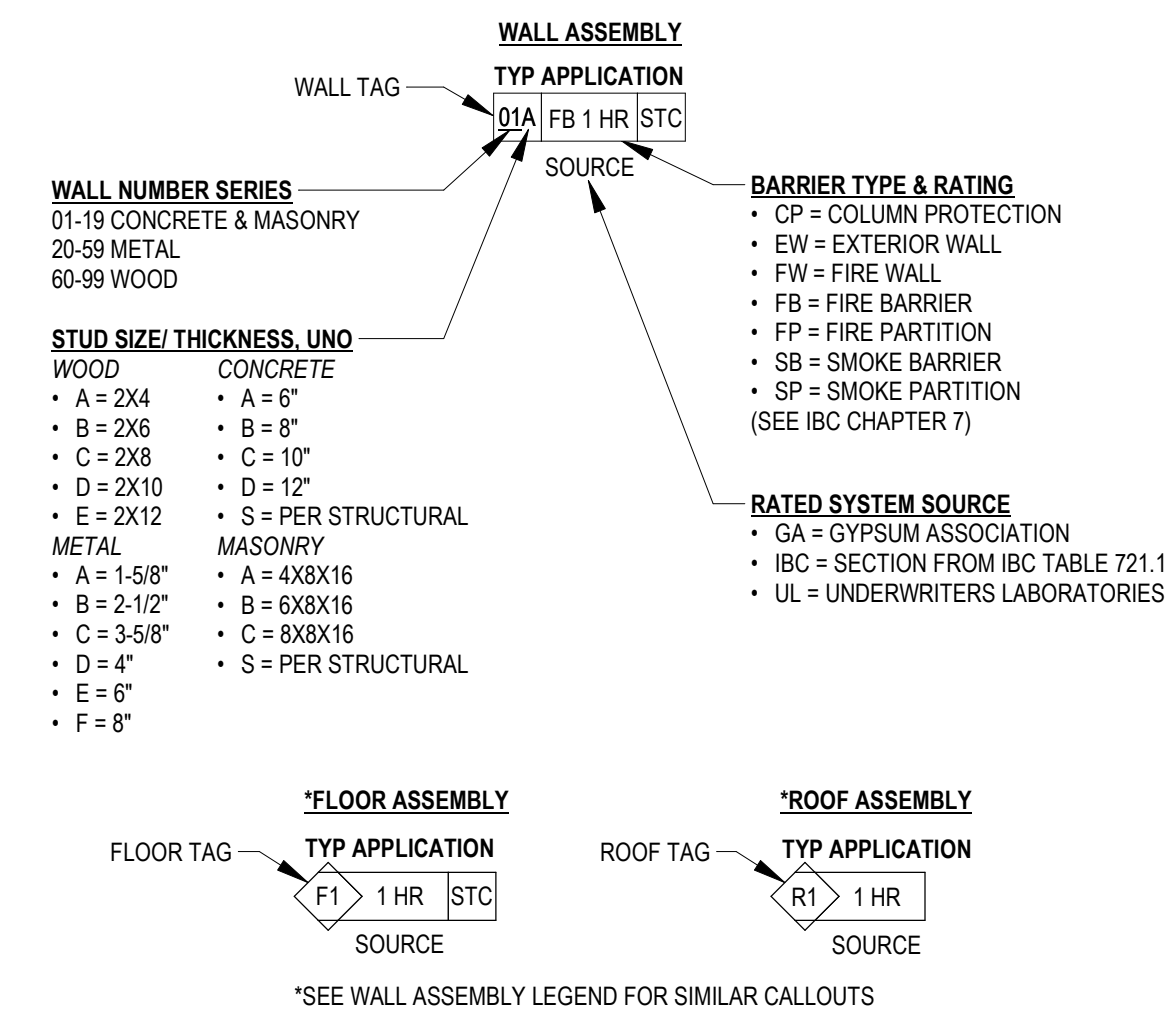


4 ROOF-CEILING TYPES

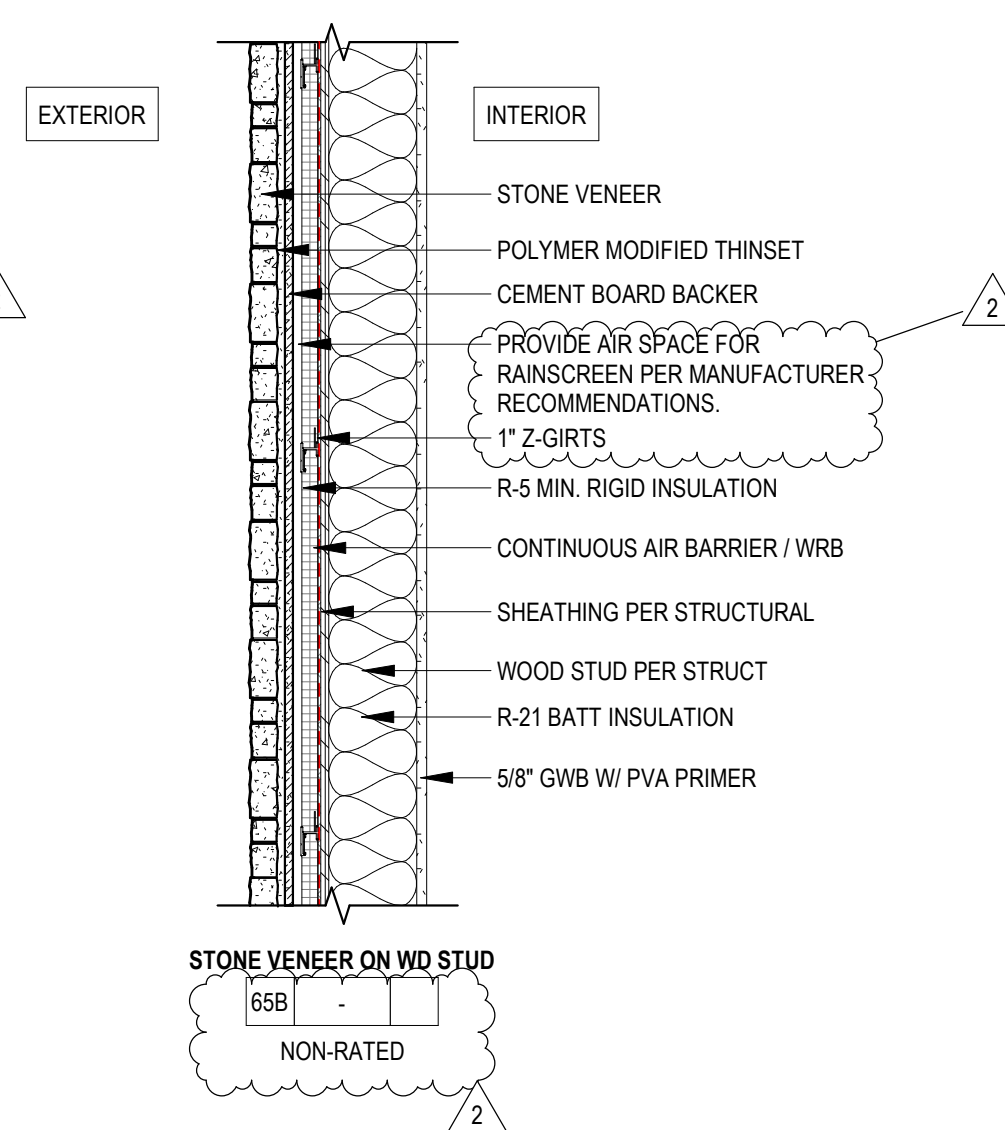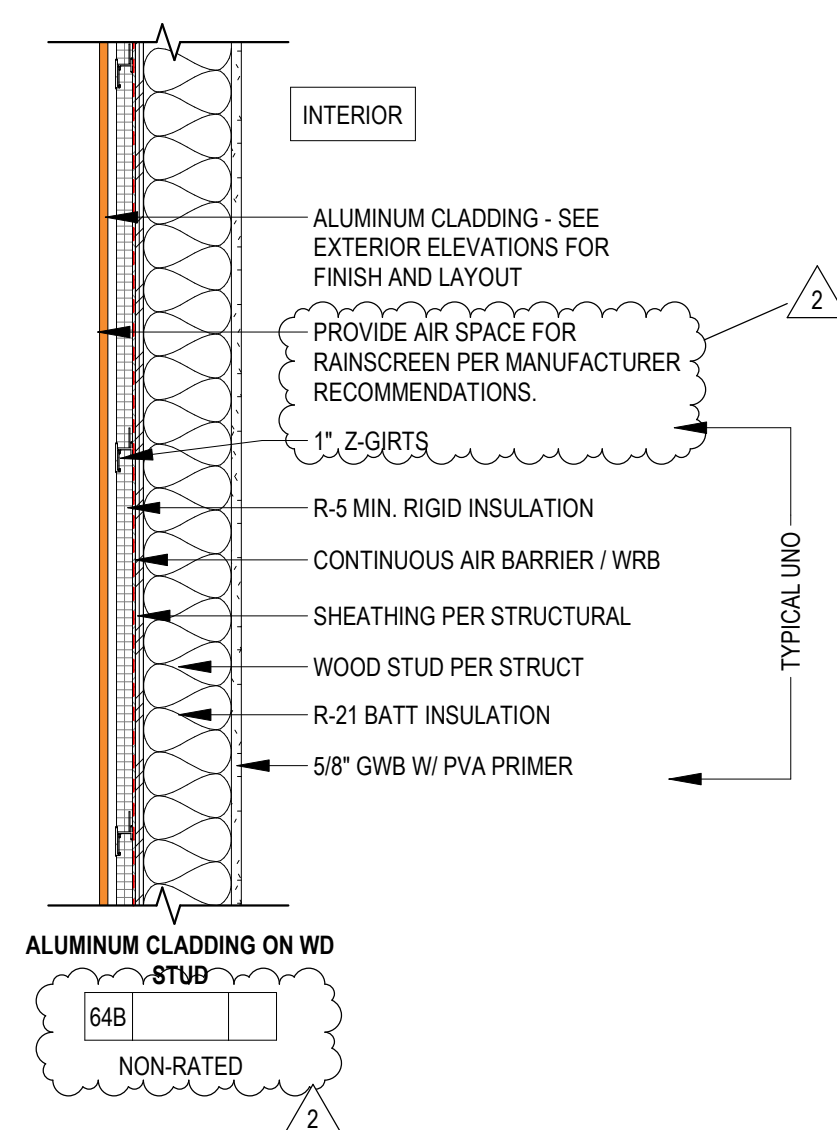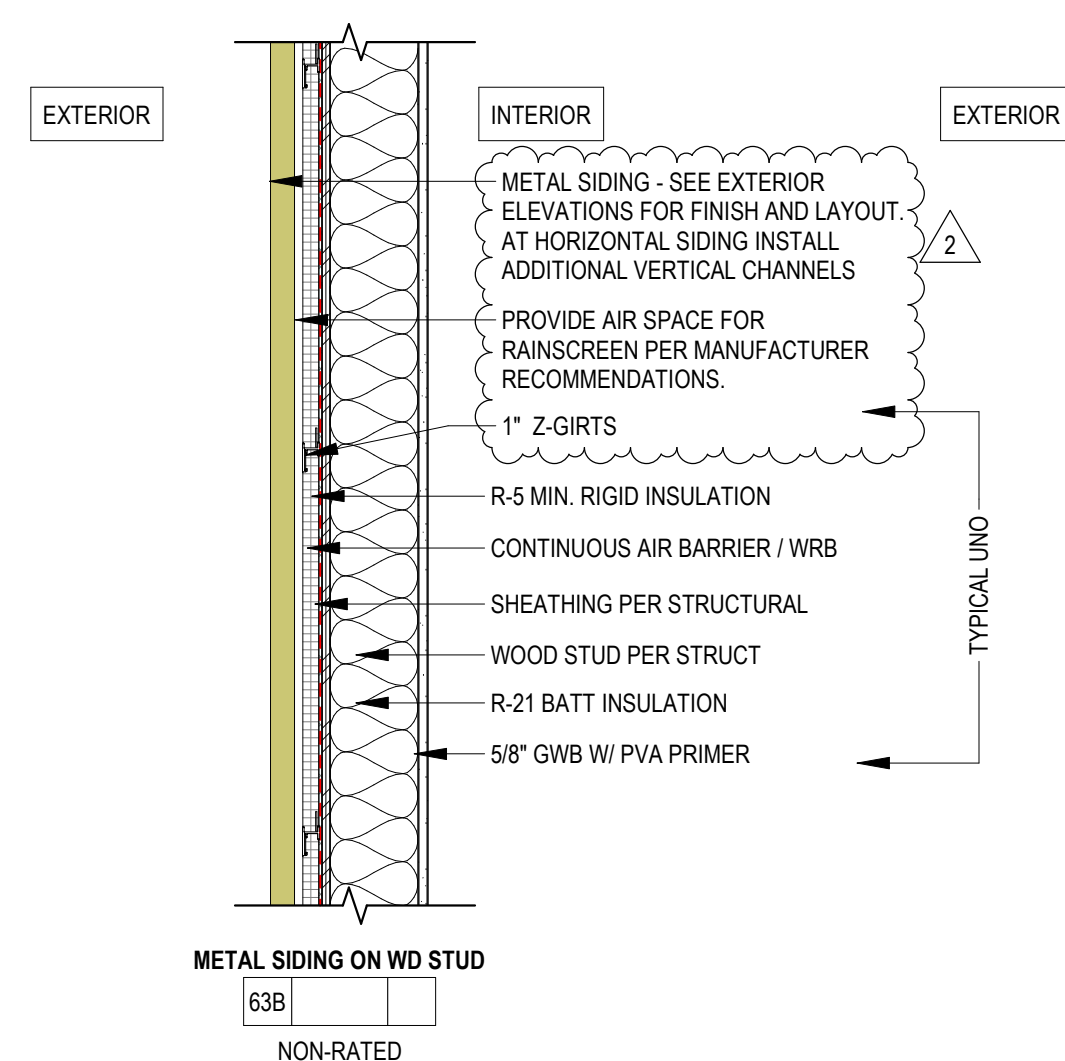

3 FLOOR-CEILING TYPES

2 EXTERIOR WALLS

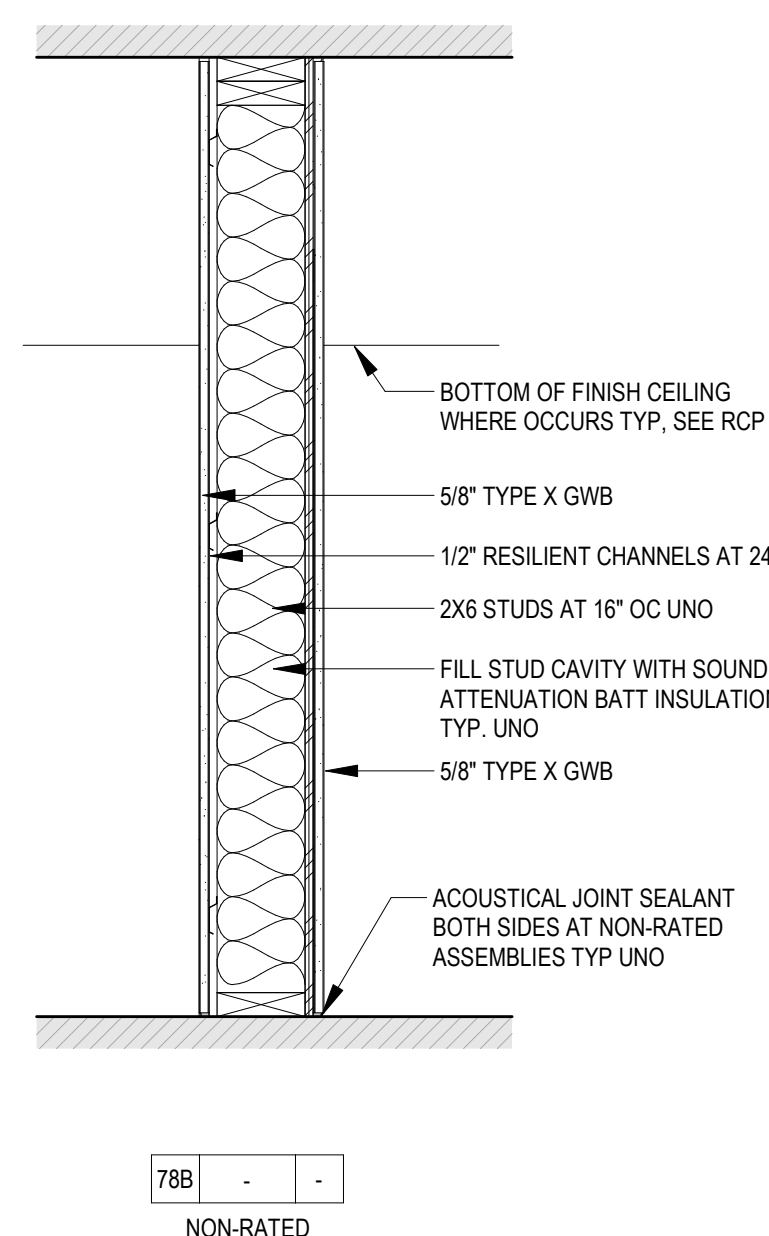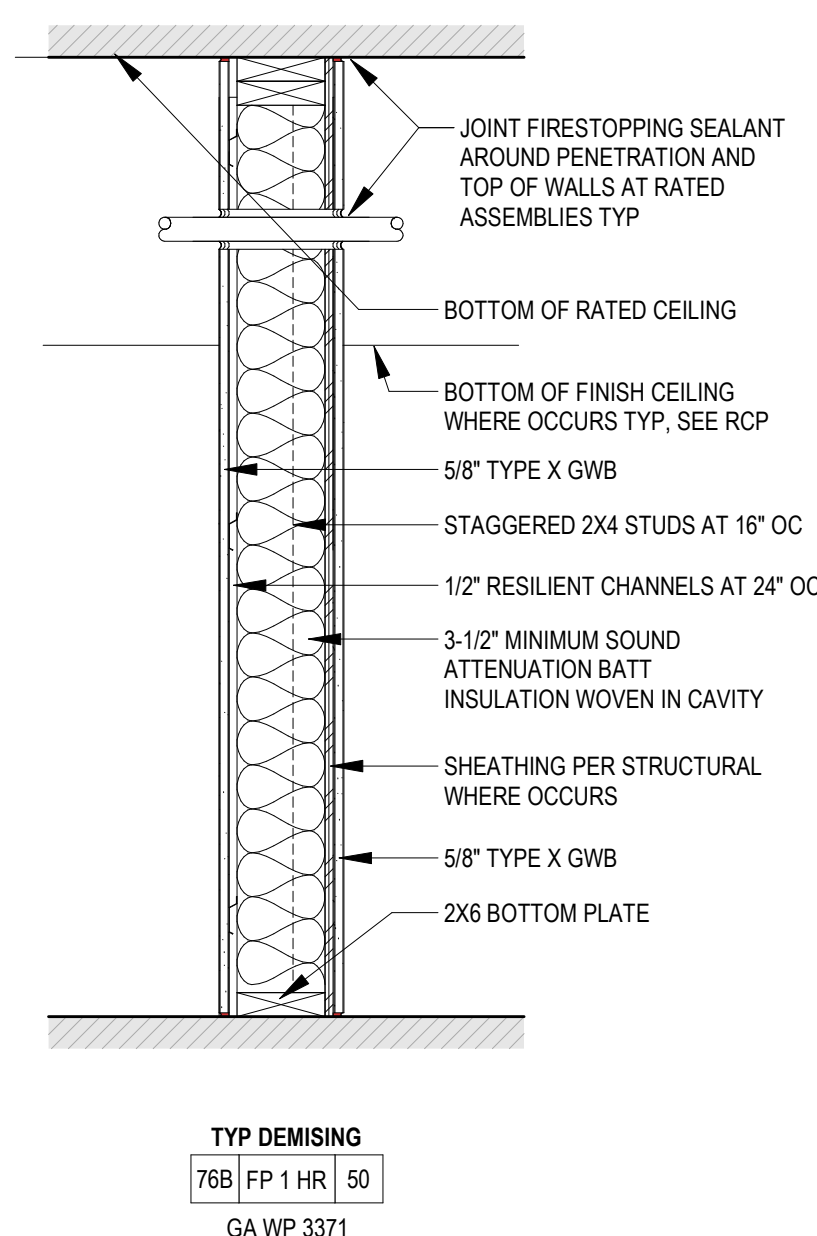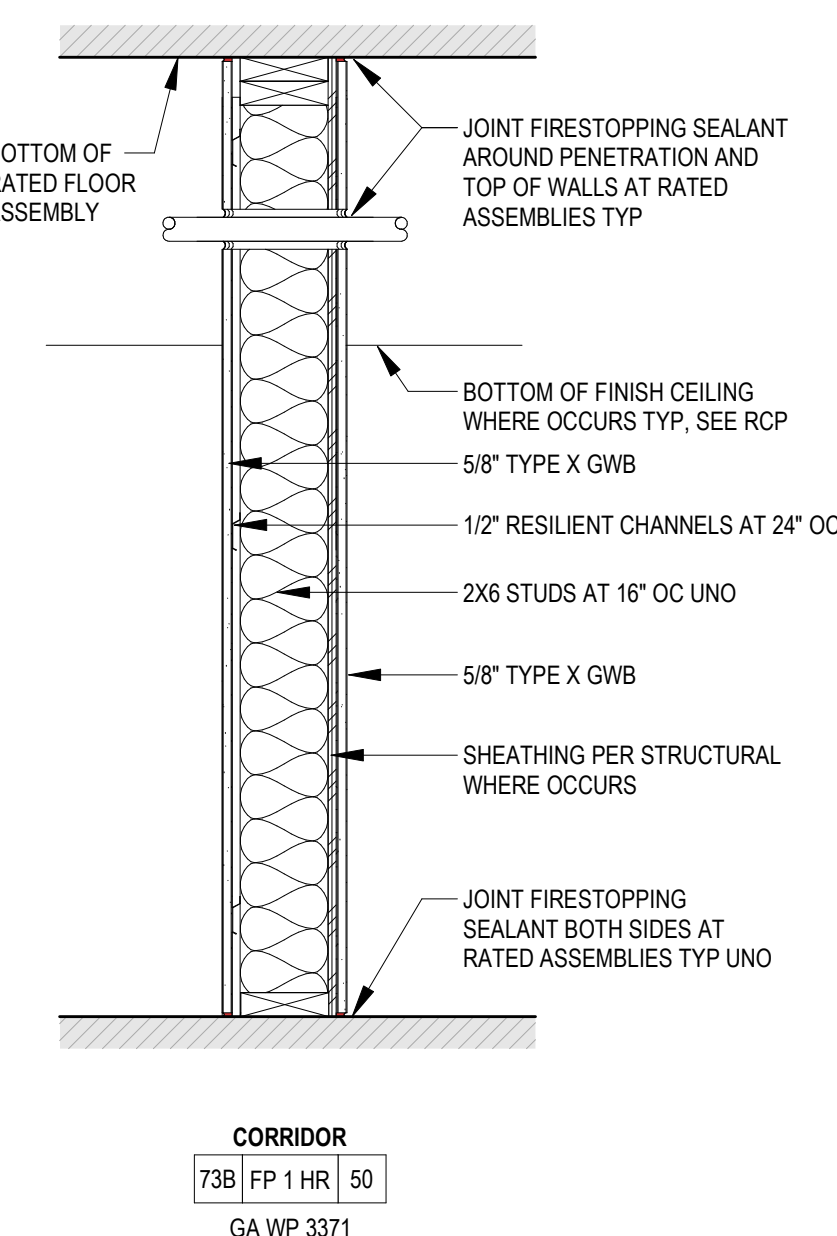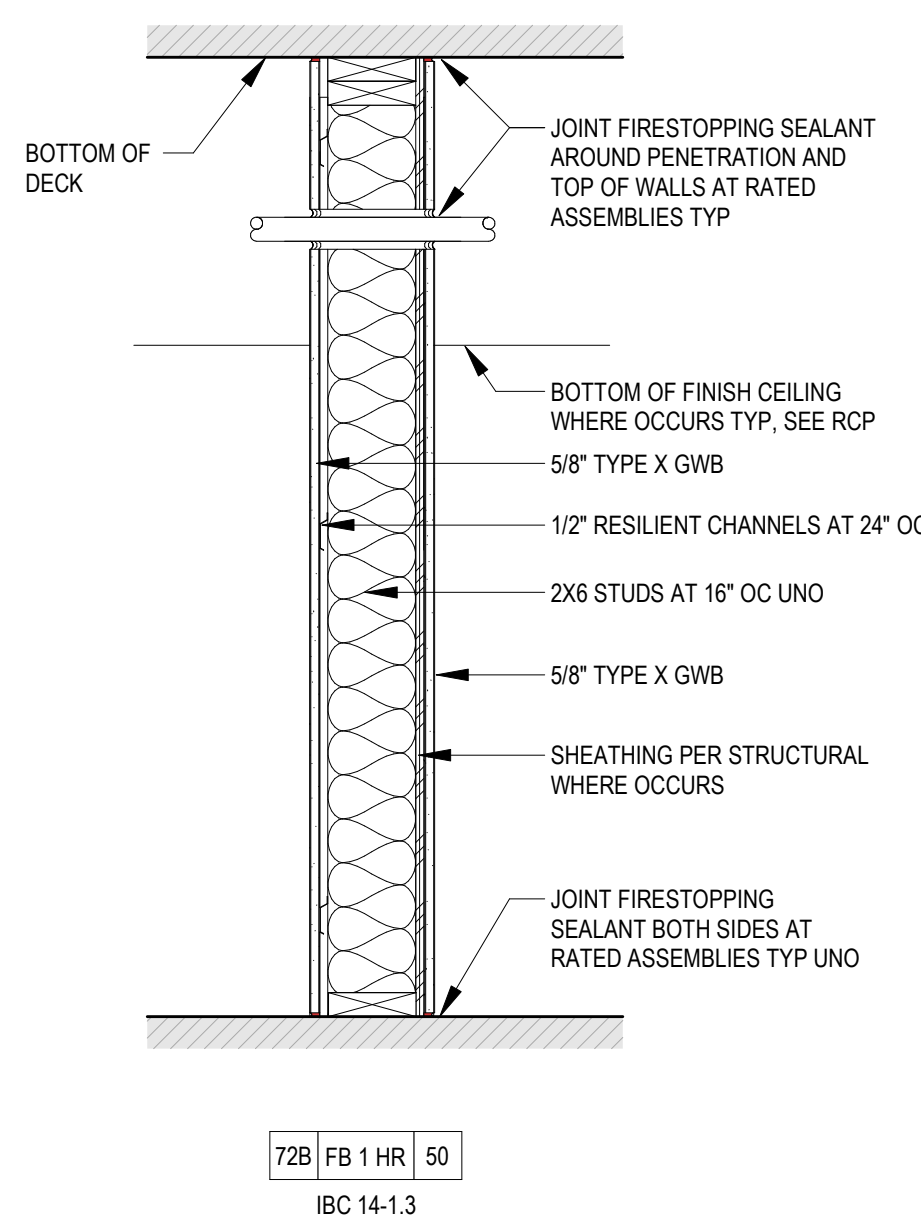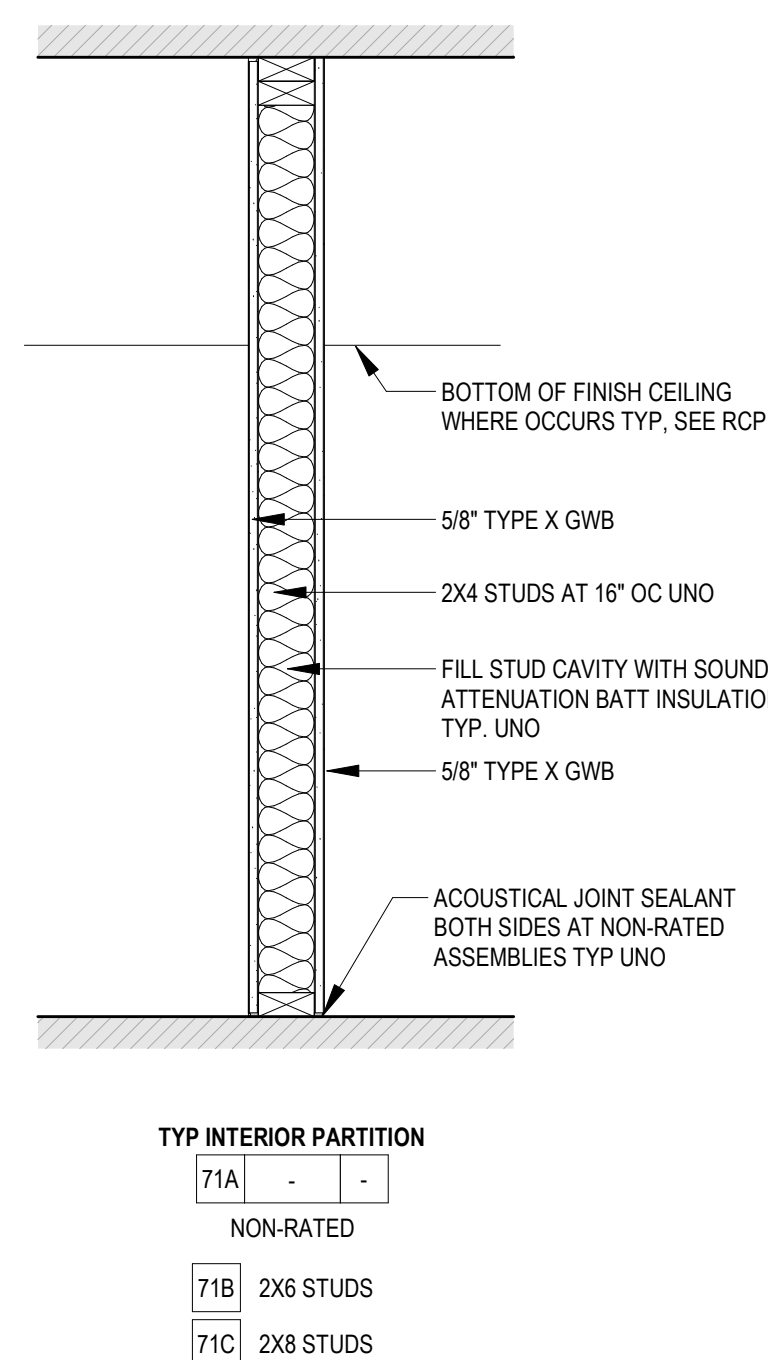


1 PARTITION WALLS

PROJECT #		2023093.02	
PERMIT SET			
ISSUE DATE		JULY 26, 2026	
REVISION SCHEDULE			
2	ADDENDUM #2	08/21/2026	
AHJ APPROVAL STAMP			




- NOTES:**
- 4.06.1 GENERAL:** CURB RAMPS ALONG ACCESSIBLE ROUTES SHALL COMPLY WITH SECTIONS 406, 405.2, 405.3 AND 405.10.
 - 4.06.2 COUNTER SLOPE:** COUNTER SLOPES OF ADJOINING GUTTERS AND ROAD SURFACES IMMEDIATELY ADJACENT TO THE CURB RAMP SHALL NOT BE STEEPER THAN 1:20. THE ADJACENT SURFACES AT TRANSITIONS AT CURB RAMPS TO WALKS, GUTTERS, AND STREETS SHALL BE AT THE SAME LEVEL.
 - 4.06.3 SIDES OF CURB RAMPS:** WHERE PROVIDED, CURB RAMP FLARES SHALL COMPLY WITH SECTION 406.3.
 - 4.06.3.1 SIDES:** FLARES SHALL NOT BE STEEPER THAN 1:10.
 - 4.06.3.2 MARKING:** IF CURB ADJACENT TO THE RAMP FLARES ARE PAINTED, THE PAINTED SURFACE SHALL EXTEND ALONG THE FLARED PORTION OF THE CURB.
 - 4.06.4 WIDTH:** CURB RAMPS SHALL BE 36" MINIMUM IN WIDTH, EXCLUSIVE OF FLARED SIDES.
 - 4.06.5 FLOOR SURFACE:** FLOOR SURFACES OF CURB RAMPS SHALL COMPLY WITH SECTION 302.
 - 4.06.6 LOCATION:** CURB RAMPS AND THE FLARED SIDES OF CURB RAMPS SHALL BE LOCATED SO THEY DO NOT PROJECT INTO VEHICULAR TRAFFIC LANES, PARKING SPACES, OR PARKING ACCESS AISLES. CURB RAMPS AT MARKED CROSSINGS SHALL BE WHOLLY CONTAINED WITHIN THE MARKINGS, EXCLUDING ANY FLARED SIDES.
 - 4.06.7 LANDINGS:** LANDINGS SHALL BE PROVIDED AT THE TOPS OF CURB RAMPS. THE CLEAR LENGTH OF THE LANDING SHALL BE 36" MINIMUM. THE CLEAR WIDTH OF THE LANDING SHALL BE AT LEAST AS WIDE AS THE CURB RAMP, EXCLUDING FLARED SIDES, LEADING TO THE LANDING.
 - 4.06.8 OBSTRUCTIONS:** CURB RAMPS SHALL BE LOCATED OR PROTECTED TO PREVENT THEIR OBSTRUCTION BY PARKED VEHICLES.
 - 4.06.9 HANDRAILS:** HANDRAILS SHALL NOT BE REQUIRED ON CURB RAMPS.

8

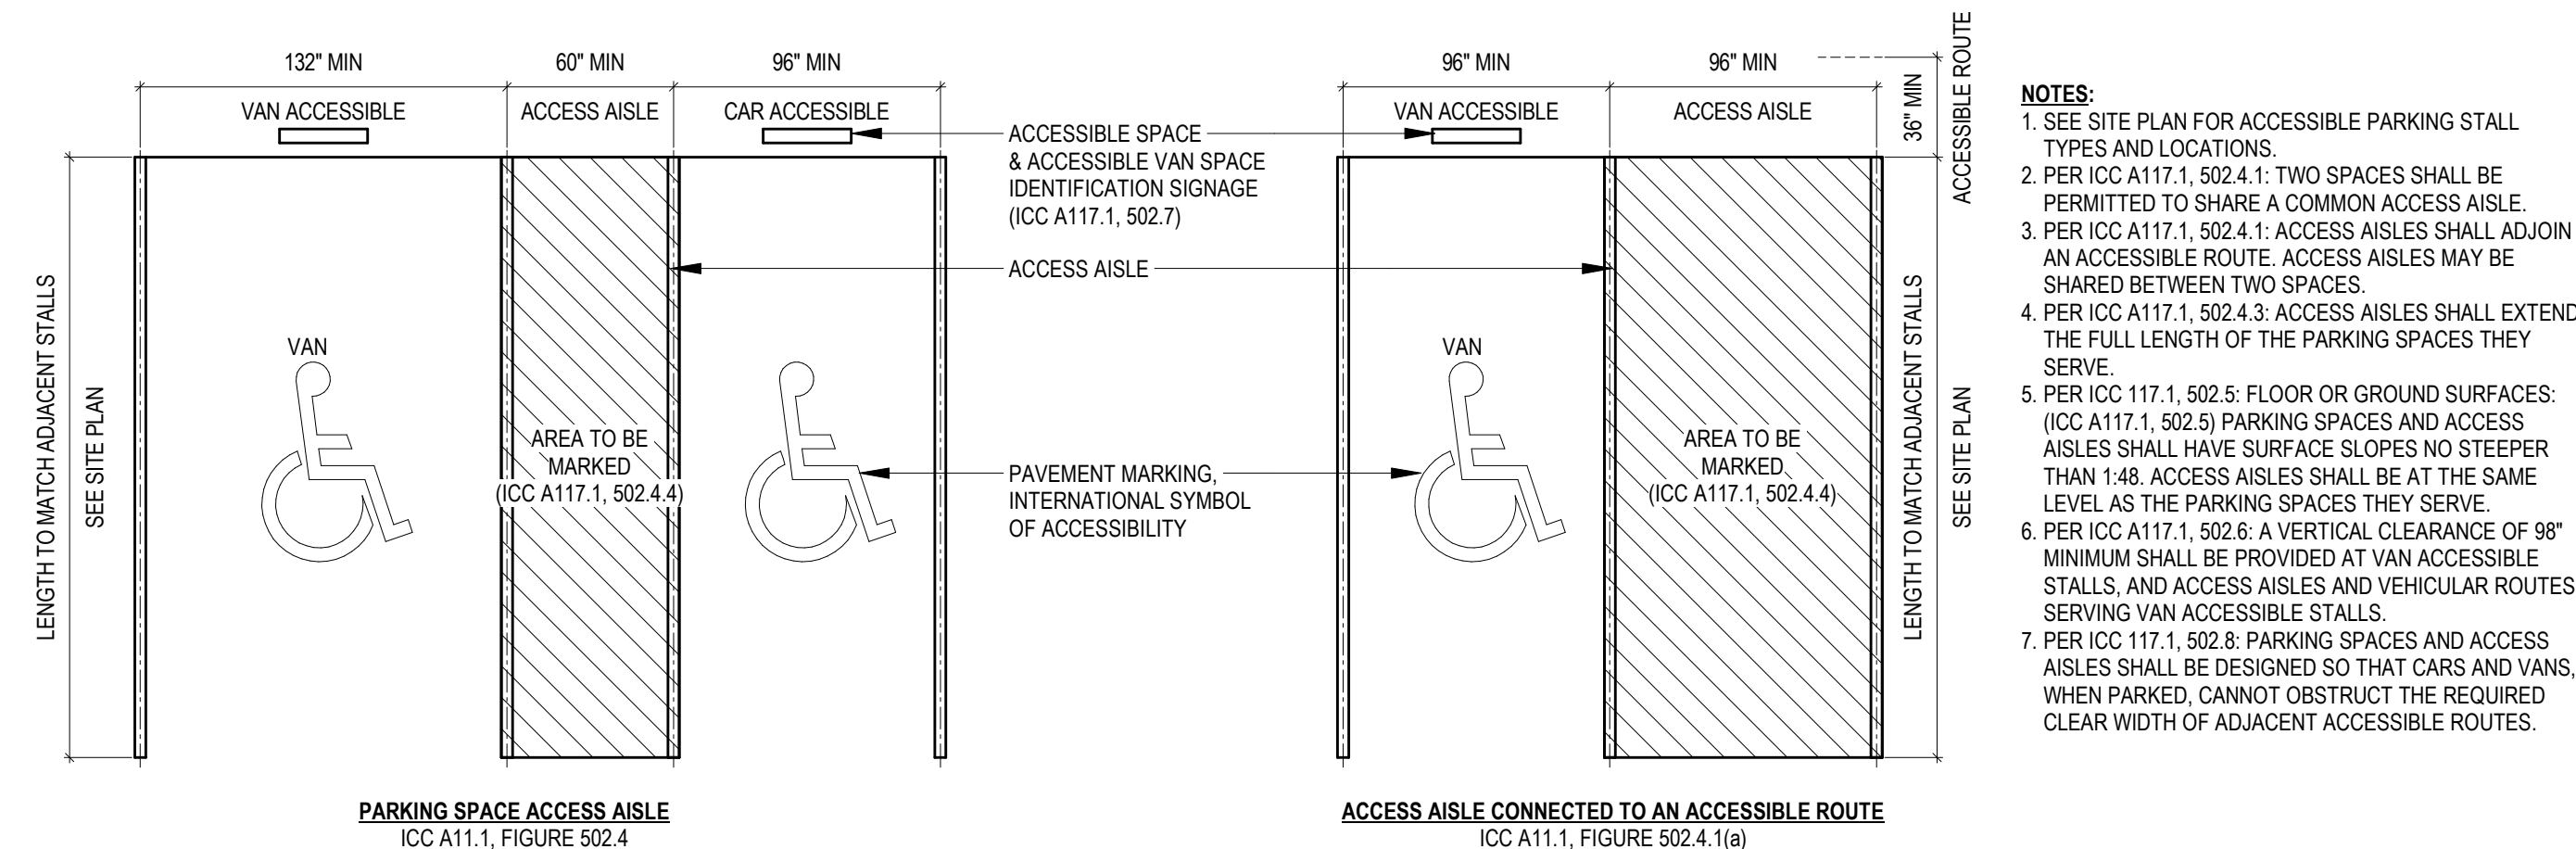


- NOTES:**
1. SEE SITE PLAN FOR ACCESSIBLE PARKING STALL TYPES AND LOCATIONS.
 2. PER ICC A117.1, 502.4.2: TWO SPACES SHALL BE PROVIDED FOR EACH SHARED COMMON ACCESSIBLE SPACE.
 3. PER ICC A117.1, 502.4.1: ACCESS AISLES SHALL ADJOIN AN ACCESSIBLE ROUTE. ACCESS AISLES MAY BE SHARED BETWEEN TWO SPACES.
 4. PER ICC A117.1, 502.4.3: ACCESS AISLES SHALL EXTEND THE FULL LENGTH OF THE PARKING SPACES THEY SERVE.
 5. PER ICC 117.1, 502.5: FLOOR OR GROUND SURFACES: (ICC A117.1, 502.5) PARKING SPACES AND ACCESS AISLES SHALL HAVE SURFACE SLOPES NO STEEPER THAN 1:48. ACCESS AISLES SHALL BE AT THE SAME LEVEL AS THE PARKING SPACES THEY SERVE.
 6. PER ICC A117.1, 502.6: VERTICAL CLEARANCE OF 98" MINIMUM SHALL BE PROVIDED AT VAN ACCESSIBLE STALLS, AND ACCESS AISLES AND VEHICULAR ROUTES SERVING VAN ACCESSIBLE STALLS.
 7. PER ICC 117.1, 502.8: PARKING SPACES AND ACCESS AISLES SHALL BE BEYOND THE REAR OF CARS AND VANS, WHEN PARKED, CANNOT OBSTRUCT THE REQUIRED CLEAR WIDTH OF ADJACENT ACCESSIBLE ROUTES.

7

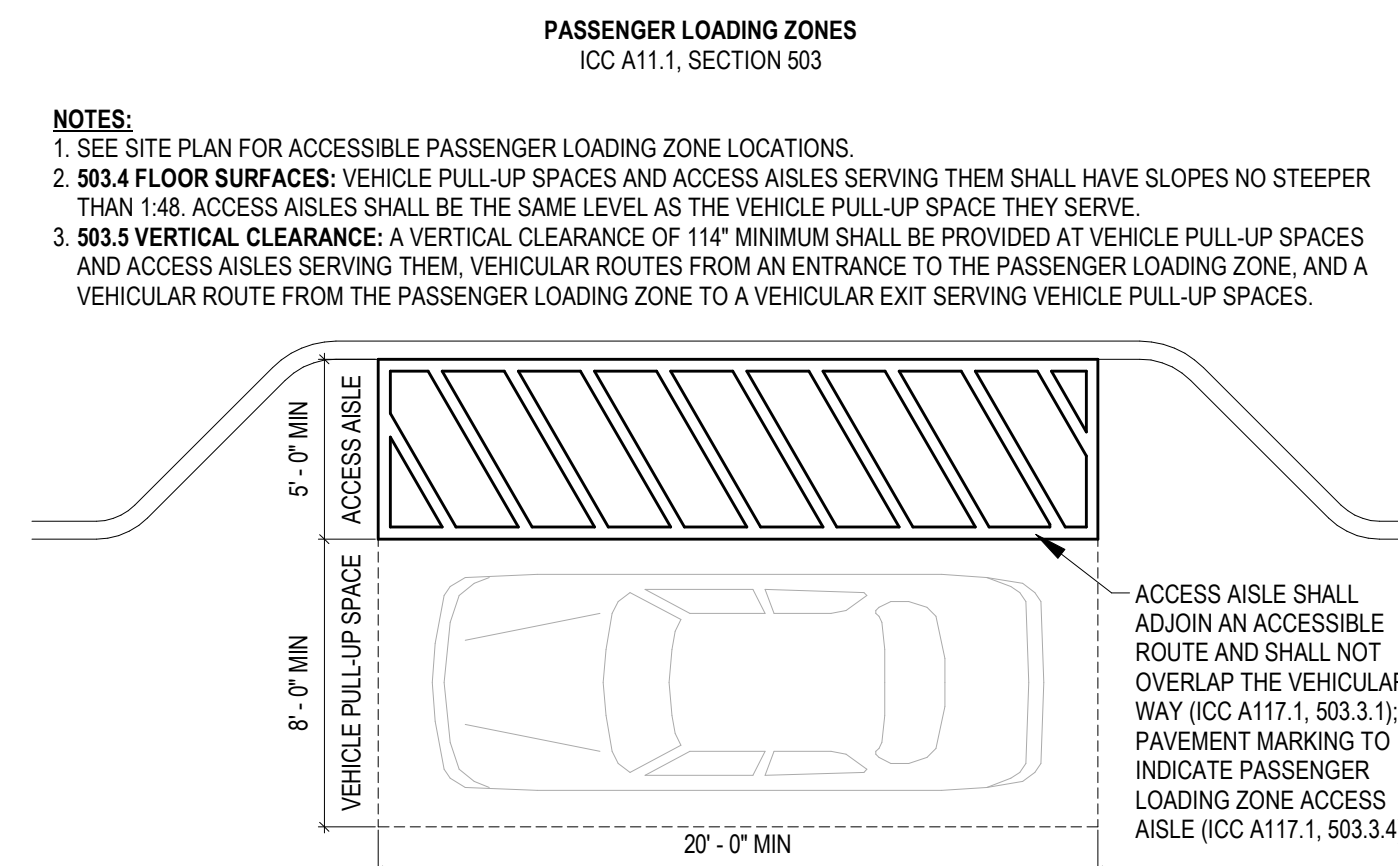

- NOTES:**
1. SEE SITE PLAN FOR ACCESSIBLE PASSENGER LOADING ZONE LOCATIONS.
 2. **503.4 FLOOR SURFACES:** VEHICLE PULL-UP SPACES AND ACCESS AISLES SERVING THEM SHALL HAVE SLOPES NO STEEPER THAN 1:48. ACCESS AISLES SHALL BE THE SAME LEVEL AS THE VEHICLE PULL-UP SPACE THEY SERVE.
 3. **503.5 VERTICAL CLEARANCE:** A VERTICAL CLEARANCE OF 11'4" MINIMUM SHALL BE PROVIDED AT VEHICLE PULL-UP SPACES AND ACCESS AISLES SERVING THEM. VEHICULAR ROUTES FROM AN ENTRANCE TO THE PASSENGER LOADING ZONE, AND A VEHICULAR ROUTE FROM THE PASSENGER LOADING ZONE TO A VEHICULAR EXIT SERVING VEHICLE PULL-UP SPACES.

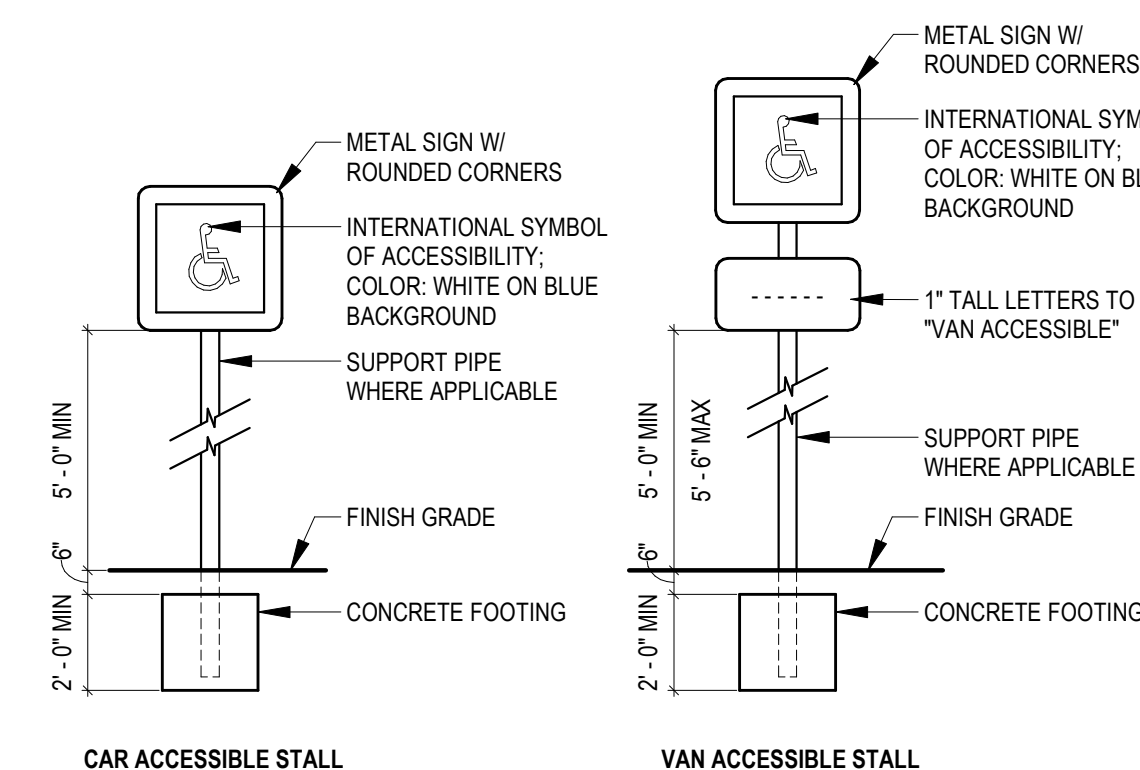

NOTE: CENTER SIGNS ON EACH REQUIRED ACCESSIBLE STALL OR ZONE

NOTE: CENTER SIGNS ON EACH REQUIRED ACCESSIBLE STALL OR ZONE

 
ACCESSIBLE STALL IDENTIFICATION
ICC A11.1, SECTION 502.7

6




- NOTES:**
1. SIGN TO BE MOUNTED 5'-0" AFF.
 2. SIGN MAY BE POST OR WALL MOUNTED.
 3. SIGN TO BE LOCATED AT FRONT END OF EACH ACCESSIBLE STALL.

5




13
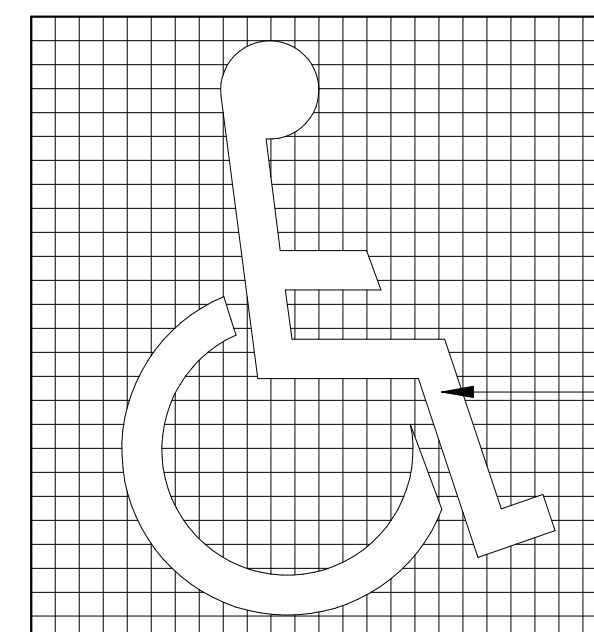
$$1/4'' = 1'-0''$$


INTERNATIONAL SYMBOL OF ACCESSIBILITY
(ICC A117.1, 703.6.3.1)

COLOR: WHITE FIGURE ON BLUE
BACKGROUND PER FEDERAL STANDARDS

1

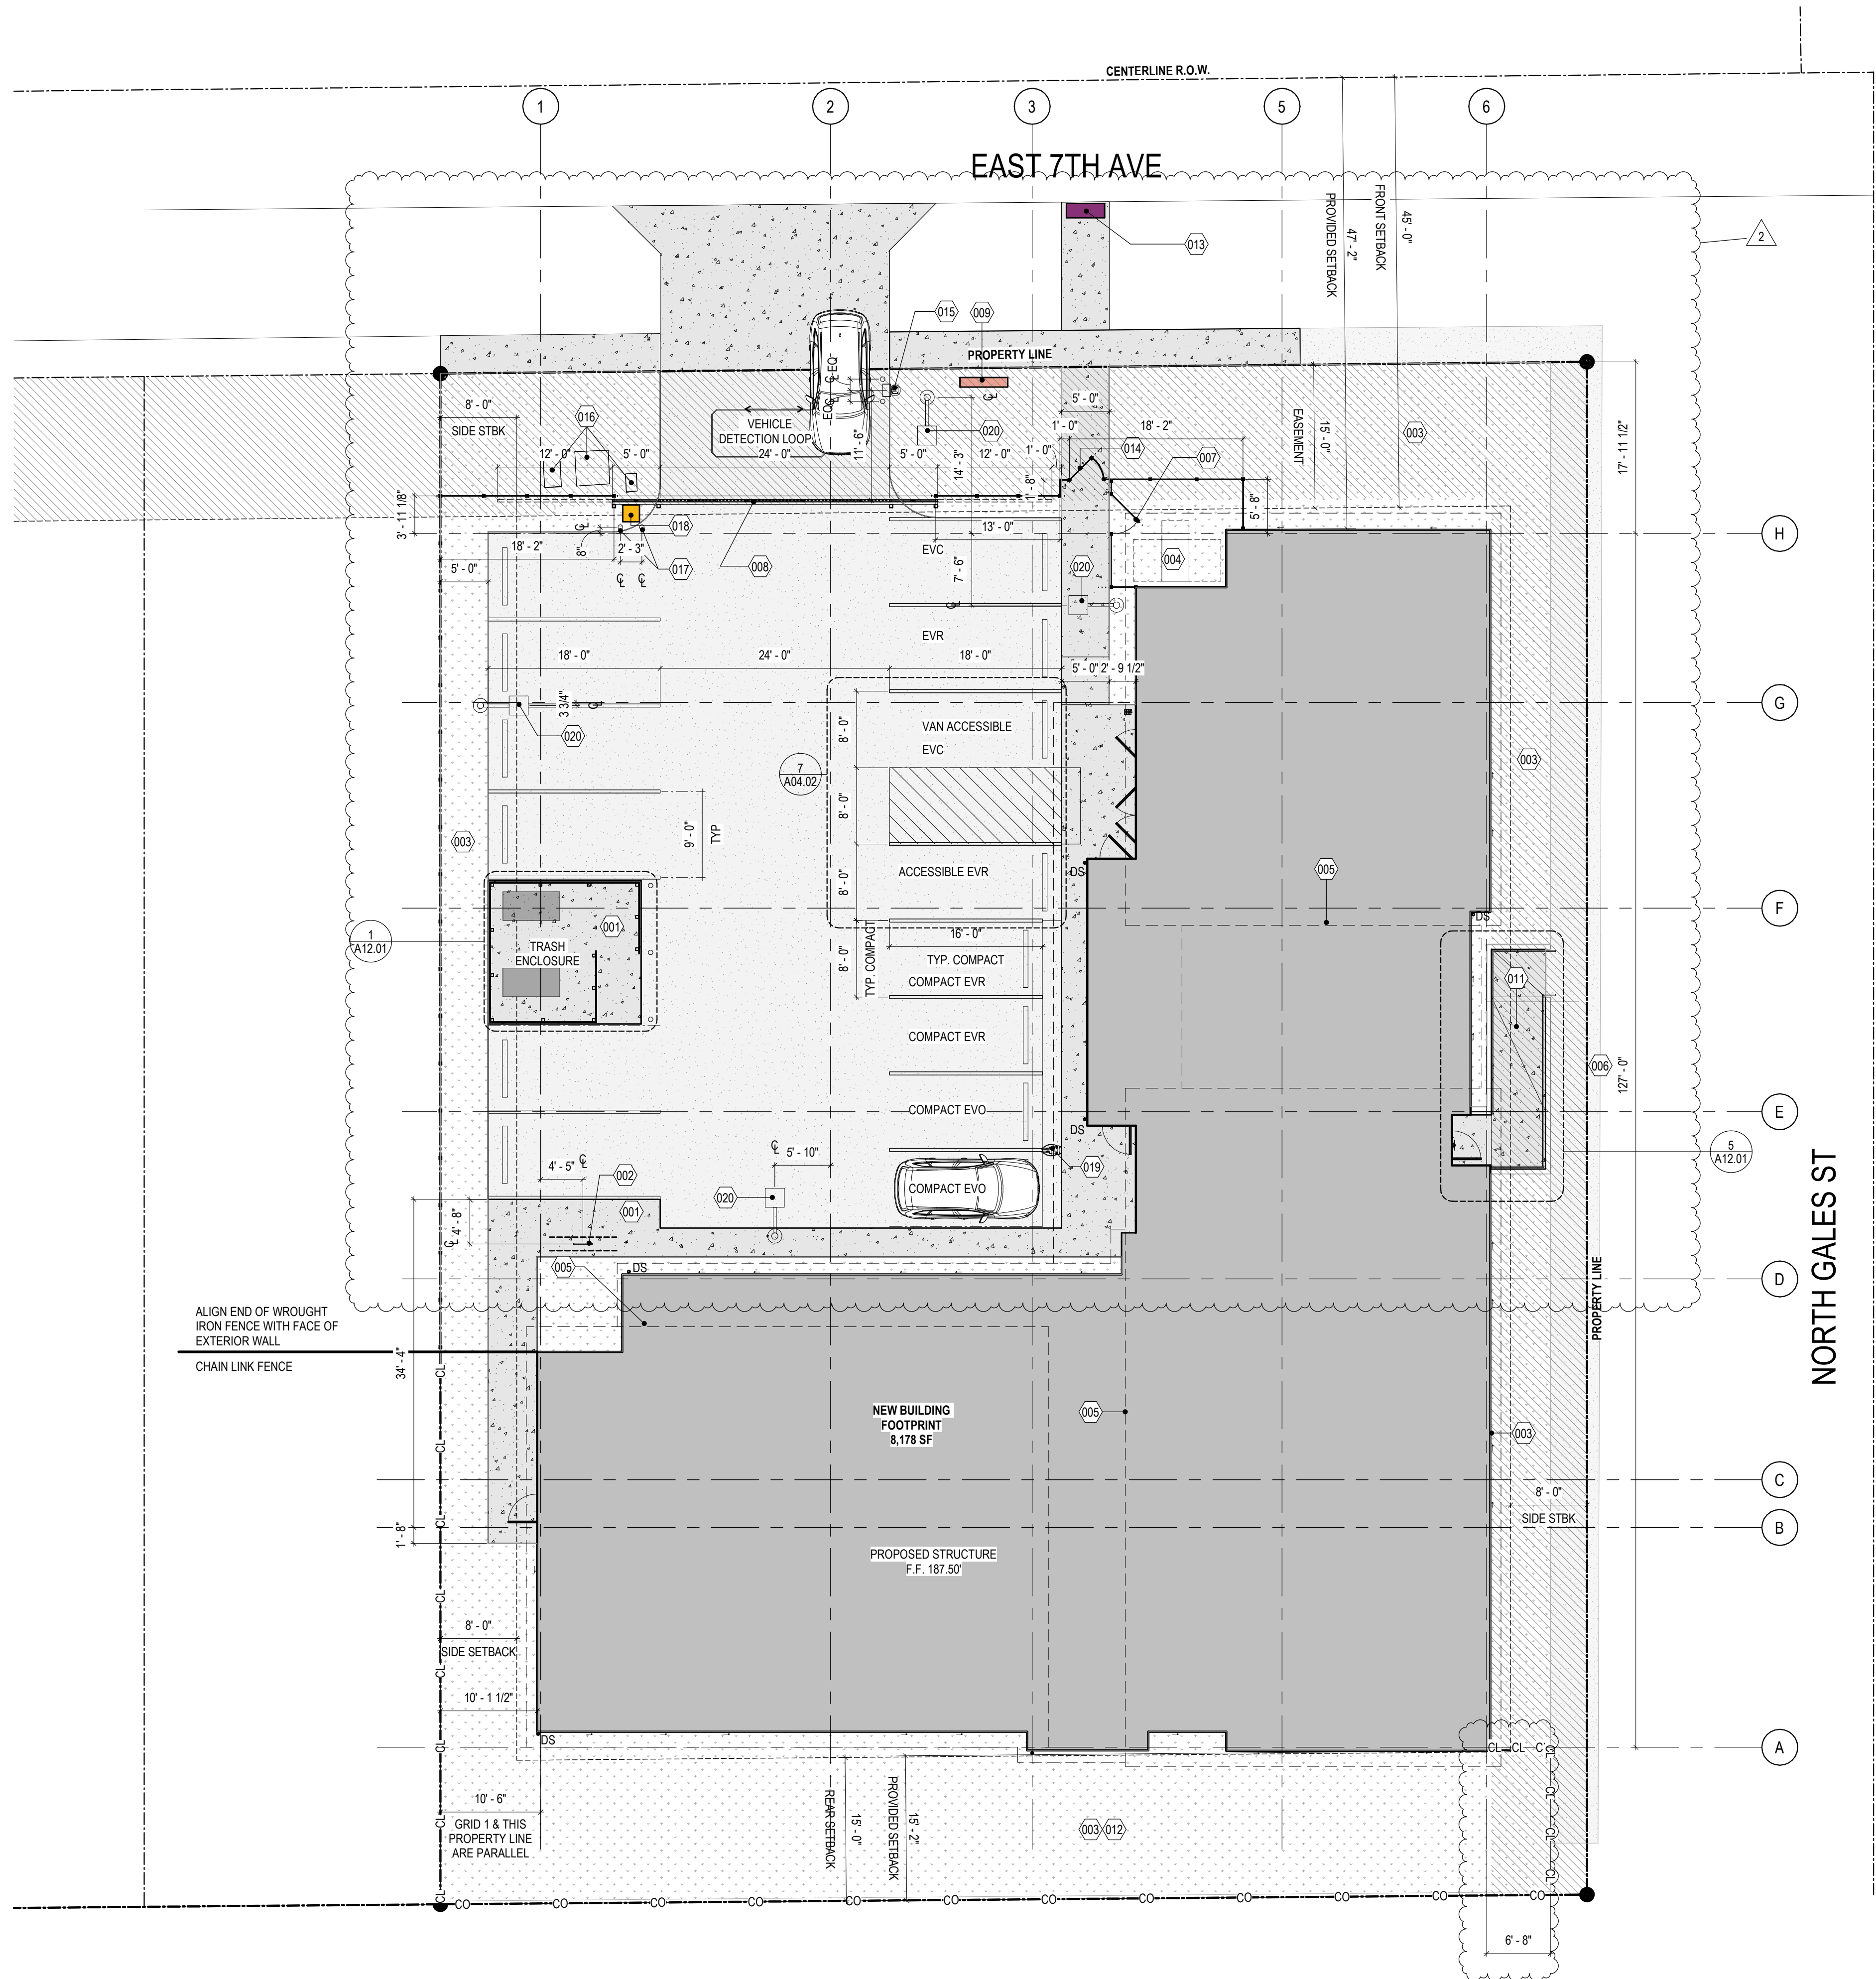

1 SITE PLAN
1" = 10'-0"

NOTES & LEGEND - SITE PLAN

1. REFERENCE CIVIL DRAWINGS FOR ADDITIONAL INFORMATION.
2. FIELD VERIFY LENGTH OF ALL THREE FENCE TYPES. FOLLOW ARCHITECTURAL DRAWINGS FOR LAYOUT.

LANDSCAPING

PARKING LOT- ASPHALT

SIDEWALK, TRASH ENCLOSURE PAD, RAMP - PER PLAN

PROPERTY EASEMENT

WROUGHT IRON FENCE

CHAINLINK FENCE WITH SLATS

CHAINLINK FENCE WITH NO SLATS

PROPERTY LINE

BUILDING SETBACK

BUILDING OUTLINE

ROOF OVERHANG

KEYNOTES LEGEND

#	NOTE DESCRIPTION
001	CONCRETE PAVING
002	SINGLE LOOP BICYCLE RACK
003	LANDSCAPED AREA - SEE LANDSCAPE DRAWINGS
004	AIR-TO-WATER-HEAT-PUMP
005	ROOF OVERHANG
006	EXISTING SIDEWALK
007	EQUIPMENT GATE
008	ENTRY GATE - DOUBLE SLIDER CANTILEVERED GATE WITH CARD READER ACCESS
009	MONUMENT SIGN - DESIGN AND FINAL LOCATION BY OWNER
010	NEW RAMP - SEE CIVIL
011	PICNIC TABLE AND RAISED GARDEN BEDS - LOCATION PER LANDSCAPE DRAWINGS
012	MAILBOXES
013	PEDESTRIAN GATE WITH CARD READER AND KNOX KEY SWITCH
014	ACCESS CONTROL PEDESTAL WITH CARD READER AND KNOX KEY SWITCH
015	EXISTING UTILITIES TO REMAIN - SEE CIVIL DRAWINGS
016	TYP. BOLLARDS
017	GATE OPERATOR ON 21"x21" CONCRETE PAD
018	DUAL CHARGING STATION ON CONCRETE BASE - SEE CIVIL AND ELECTRICAL DRAWINGS FOR ADDITIONAL INFORMATION.
019	AREA LIGHT - SEE ELECTRICAL SITE PLAN
020	

PARKING COUNT:

STANDARD PARKING STALLS --	8
COMPACT PARKING STALLS --	4
ACCESSIBLE PARKING STALLS --	2
TOTAL STALLS --	14

UNIT COUNT:

ONE BEDROOM UNITS --	22
TWO BEDROOM UNITS --	2
TOTAL STALLS --	24

ELECTRIC VEHICLE NOTES:

(8 REQUIRED ELECTRIC VEHICLE STALLS)

(EVO) 2 EV STALLS W/ OPERABLE FAST CHARGERS (10% OF TOTAL)

(EVC) 2 EV CAPABLE STALLS (10% OF TOTAL)

(EVR) 4 EV READY STALLS W/ RACEWAYS FOR FUTURE CABLING & CHARGERS (25% OF TOTAL)

SEE CODE SUMMARY SHEET A00.03 FOR MORE INFORMATION

RICEfergusMILLER
ARCHITECTURE INTERIORS PLANNING VIZLAB
275 FIFTH STREET, SUITE 100
BREMERTON, WA 98337
360-377-8773
RFMARCH.COM

20104600
REGISTERED
ARCHITECT
DEAN E. KELLY
STATE OF WASHINGTON

EKLUND AT GALES
PENINSULA HOUSING AUTHORITY
2372 E 7TH AVENUE
PORT ANGELES, WAS 98362

PROJECT #	2023093.02
PERMIT SET	
ISSUE DATE	JULY 26, 2026
REVISION SCHEDULE	
2	ADDENDUM #2 08/21/2026

AHJ APPROVAL STAMP

SITE PLAN

SHEET #

A11.01



EKLUND AT GALES
PENINSULA HOUSING AUTHORITY
2372 E 7TH AVENUE
PORT ANGELES, WA 98362


[illegible]

FLOOR PLAN - LEVEL 1


SHEET #

A22.01

1. DIMENSIONS ARE TO ROUGH FRAMING OR TO FACE OF EXISTING FINISHES, TYP UNO.
2. DIMENSIONS INDICATED AS "MIN" OR "CLR" ARE FROM NEAREST FINISH SURFACE, INCLUDING TRIM.
3. ROUGH DOOR OPENINGS ARE LOCATED 4" FROM NEAREST INTERSECTING WALL FRAMING, TYP UNO.
4. SEE ENLARGED OVERHANG PLANS ON SHEET A29.01.

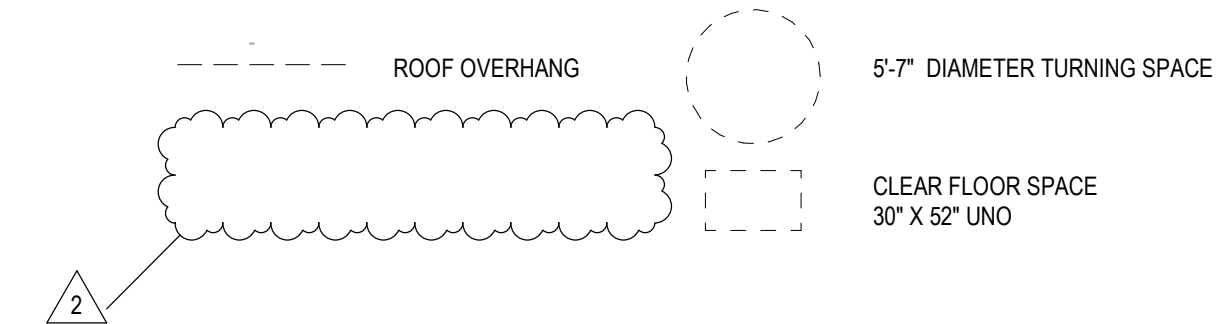


KEYNOTES LEGEND	
#	NOTE DESCRIPTION
201	OUTLINE OF ROOF OVERHANG ABOVE
215	EQUIPMENT SHOWN FOR REFERENCE ONLY. COORDINATE MEP REQUIREMENTS WITH OWNER'S LAUNDRY SUPPLIER.

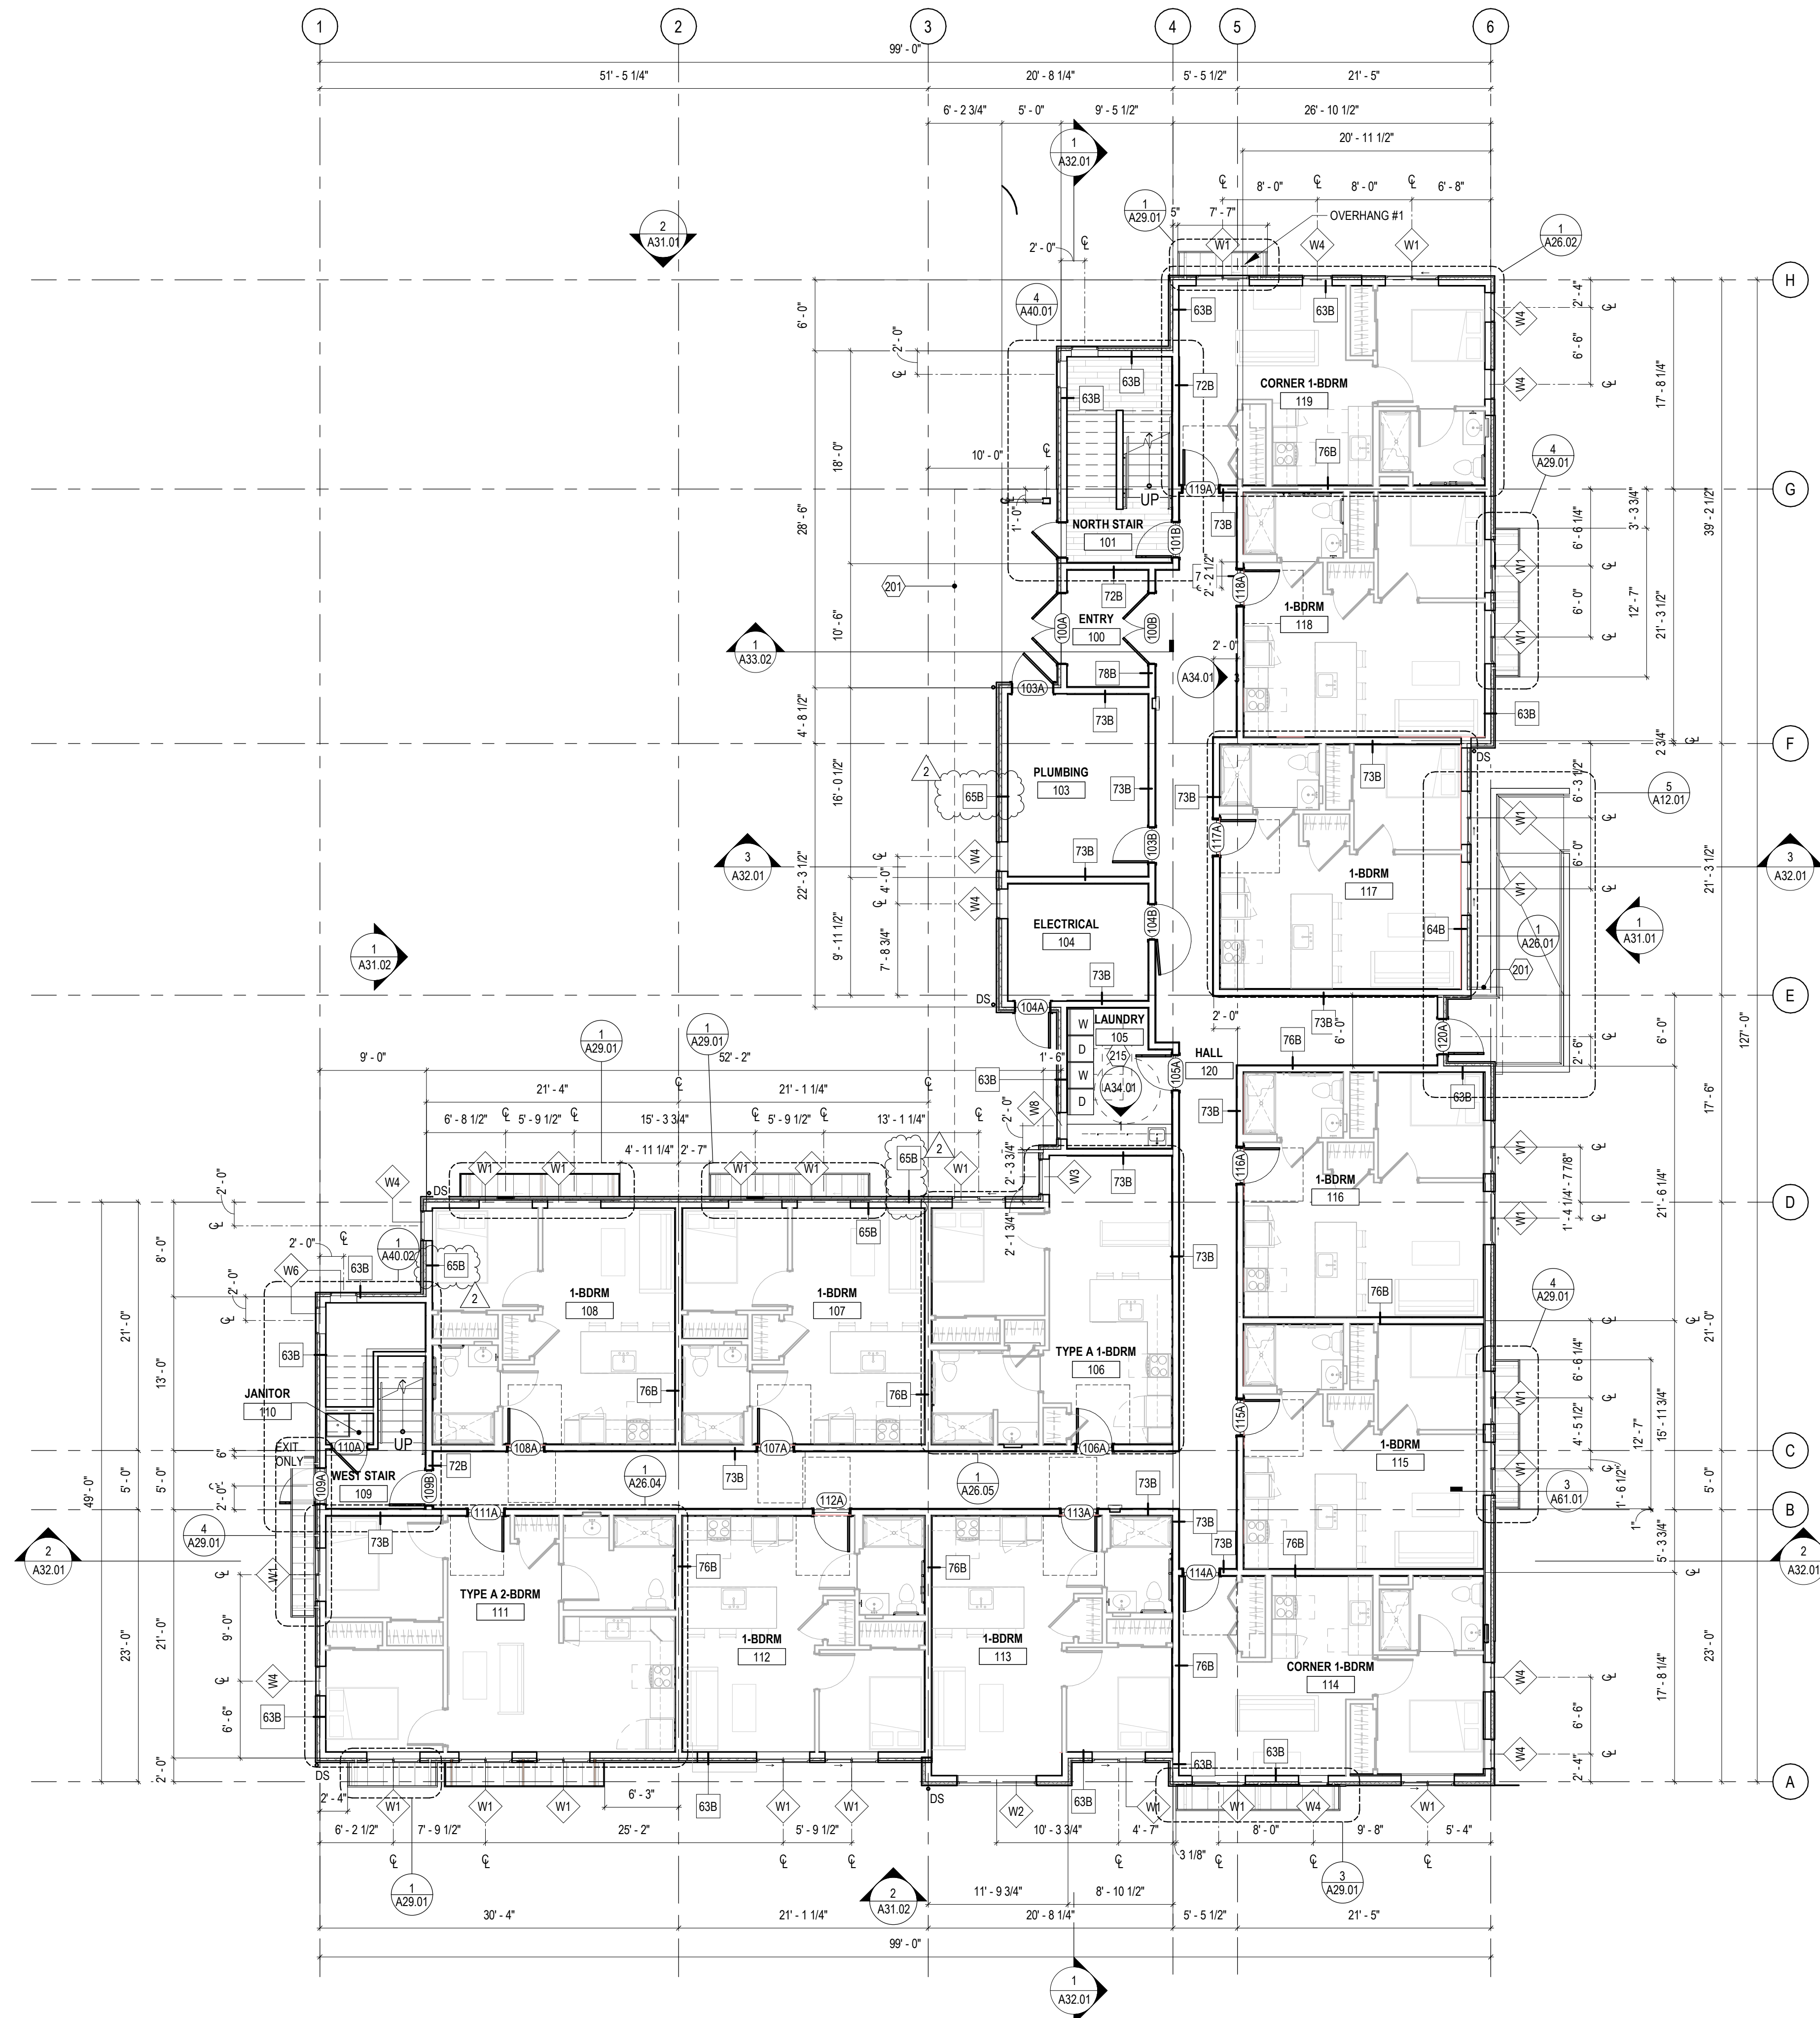

FLOOR PLAN - LEVEL 1

$1/8" = 1'-0"$

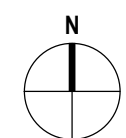

EKLUND AT GALES
PENINSULA HOUSING AUTHORITY
2372 E 7TH AVENUE
PORT ANGELES, WA 98362

[illegible]



AHJ APPROVAL STAMP

FLOOR PLAN - LEVEL 2


SHEET #

A22.02

1. DIMENSIONS ARE TO ROUGH FRAMING OR TO FACE OF EXISTING FINISHES, TYP UNO.
2. DIMENSIONS INDICATED AS "MIN" OR "CLR" ARE FROM NEAREST FINISH SURFACE, INCLUDING TRIM.
3. ROUGH DOOR OPENINGS ARE LOCATED 4" FROM NEAREST INTERSECTING WALL FRAMING, TYP UNO.
4. SEE ENLARGED OVERHANG PLANS ON SHEET A29.01.

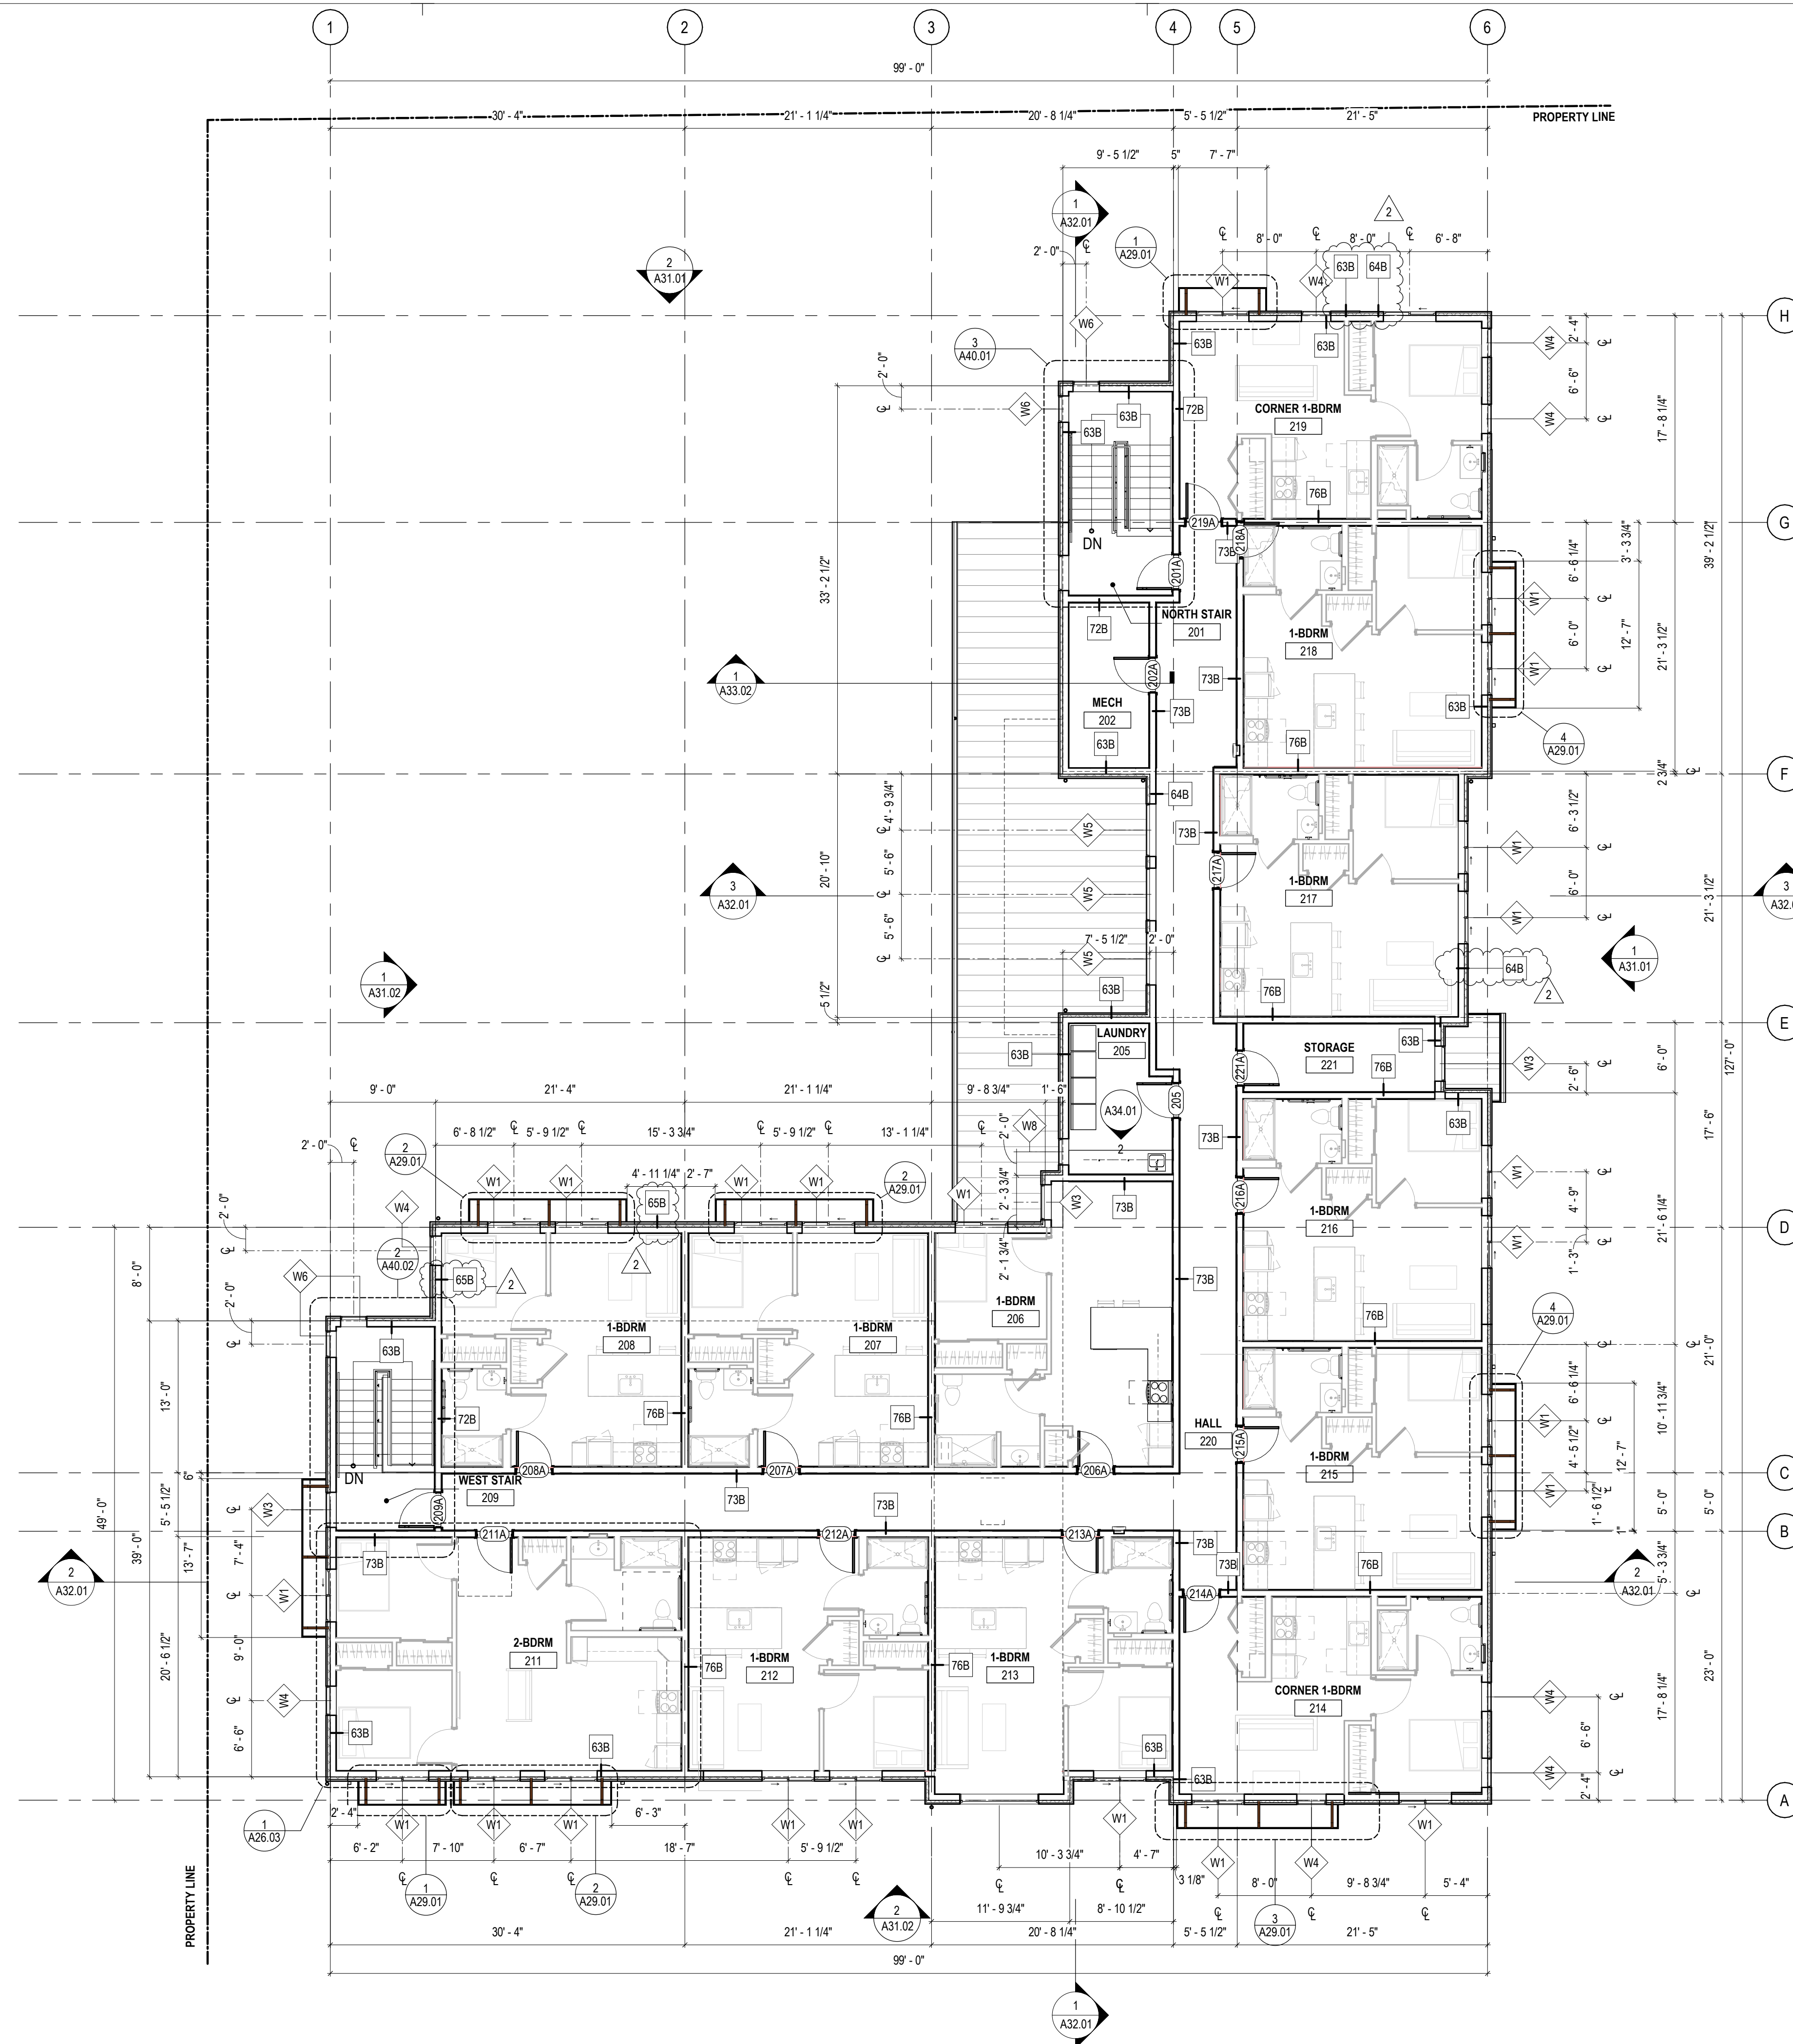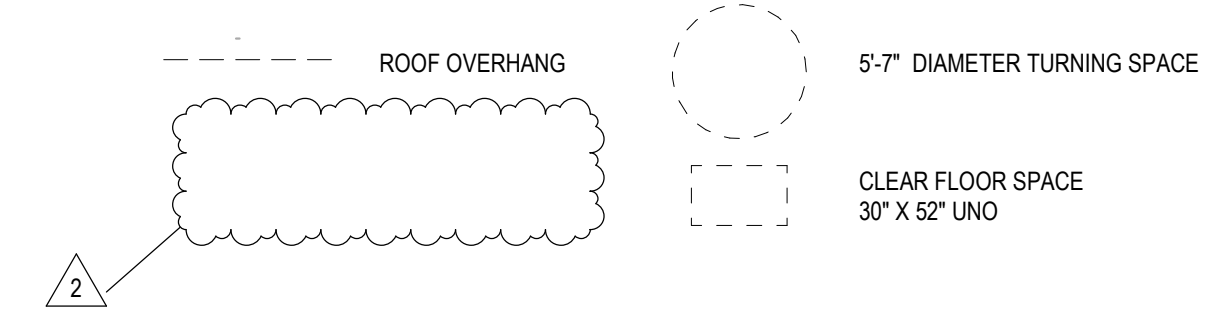


1 FLOOR PLAN - LEVEL 2
1/8" = 1'-0"

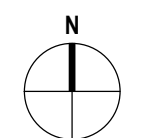

EXTERIOR	TAG	SPEC #	MATERIAL	MANUFACTURER	PRODUCT	FINISH	CODE	CONTACT	NOTES
INTERIOR	CAB-1	00 00 00	WOOD CABINETS	-	WOOD CABINETS	BIRCH STAINED TO MATCH WILSONART WHITE OAK PB WHEATON	-	-	SHAKER STYLE DOOR
INTERIOR	CAB-2	00 00 00	WOOD CABINETS	-	WOOD CABINETS	BIRCH STAINED TO MATCH WILSONART WHITE OAK PB HONEY	-	-	SLAB STYLE DOOR
INTERIOR	LAM-1	VARIES	HIGH PRESSURE LAMINATE	FORMICA	189FX BY FORMICA GROUP 9918-ML BRECCIA MOJAVE	MONOLITH TEXTURE	-	-	COUNTERTOP W/ POSTFORMED DOUBLE-RADIUS EDGE
INTERIOR	LAM-2	09 78 00	HIGH PRESSURE LAMINATE	WILSONART	CALCUTTA MARBLE 4925K-07	TEXTURED GLOSS	-	-	COUNTERTOP W/ POSTFORMED DOUBLE-RADIUS EDGE
INTERIOR	P-1	09 91 00	INTERIOR PAINT	SHERWIN WILLIAMS	SW 7646 FIRST STAR	SEE GENERAL NOTES	-	-	-
INTERIOR	P-2	09 91 00	INTERIOR PAINT	SHERWIN WILLIAMS	SW 7005 PURE WHITE	SEE GENERAL NOTES	-	-	-
INTERIOR	P-3	09 91 00	INTERIOR PAINT	SHERWIN WILLIAMS	SW 7042 SHOJI WHITE	SEE GENERAL NOTES	-	-	-
INTERIOR	RES-1	09 65 00	VINYL SHEET FLOORING	PATCRAFT	1624V SENSE SHEET	00520 ESTEEM	-	-	6" SELF-COVE BASE AT ALL LOCATIONS, UNO
INTERIOR	RES-2	09 65 00	LUXURY VINYL PLANK	EVOKE	COFFEEHOUSE 2.5 COLLECTION	45627 ICED ESPRESSO 2.5	-	-	-
INTERIOR	RES-3	09 65 00	RUBBER BASE	JOHNSONITE	MILLWORK STANCE BASE MW-47-X61	47 BROWN	-	-	-
INTERIOR	RES-4	09 65 00	VINYL VINYL PLANK	EVOKE	COFFEEHOUSE 2.5 COLLECTION	45627 CAFE LATTE 2.5	-	-	-
INTERIOR	RES-5	09 65 00	VINYL SHEET FLOORING	PATCRAFT	1690V HOLISTIC SHADES	00111 RADIANT	-	-	6" SELF COVE BASE AT ALL LOCATIONS, UNO
INTERIOR	RES-6	09 65 00	RUBBER BASE	JOHNSONITE	MILLWORK STANCE BASE MW-08-X61	08 ICICLE W	-	-	-
INTERIOR	RES-7	09 65 00	STAIR TREAD	JOHNSONITE	ANGLE FIT RUBBER STAIR TREADS	47 BROWN	-	-	WITH INTEGRATED RISER AND CONTRASTING GRIT TAPE

1. WALL FINISHES TRANSITION AT INSIDE CORNERS UNO.
2. ALIGN FLOORING TRANSITIONS WITH CENTERLINE OF DOOR LEAF UNO.
3. REFER TO INTERIOR DETAILS FOR FINISH TRANSITIONS.
4. FINISH FINISH TAGS INDICATE MAJORITY FLOOR FINISH. REFER TO FINISH PLANS FOR TRANSITION LOCATIONS.
5. FLOOR FINISH TO CONTINUE UNDER ANY REMOVABLE CABINETS. REFER TO UNIT SHEET ELEVATIONS FOR REMOVABLE CABINET LOCATIONS.
6. WALLS TO BE FINISHED BEHIND ANY REMOVABLE CABINETS. REFER TO UNIT SHEET ELEVATIONS FOR REMOVABLE CABINET LOCATIONS.
7. TYPICAL PAINT FINISHES UNO: WALLS: EGGSHELL; TRIM, SEMI-GLOSS; CEILING: FLAT; DOORS & FRAMES: SEMI-GLOSS. ALL TOILET AND LAUNDRY WALLS AND CEILINGS TO BE WASHABLE EPOXY PAINT.
8. ALL EXPOSED MECHANICAL GRILLES, WALL DIFFUSERS, ELECTRICAL PANELS, ACCESS PANELS, ETC TO BE MATCH ADJACENT WALL SURFACE.
9. ALL RUBBER BASE TO BE ADHERED AT TOP, BOTTOM AND SEAMS.
10. SWITCH PLATES, OUTLET COVERS AND OTHER DEVICES TO BE WHITE, UNO.
11. HANDRAIL TO BE INSTALLED PER PLAN, HANDRAIL TO TERMINATE INTO WALL AT 90 DEGREE ANGLE. COORDINATE HANDRAIL EXTENTS WITH OWNER AND DESIGNER.
12. CORNER GUARDS TO BE INSTALLED AT ALL OUTSIDE CORNERS, UNO. ALL CORNER GUARDS TO BE FULL HEIGHT FROM TOP OF BASE.

KEY NOTES - FINISH PLAN	
#	NOTE DESCRIPTION
201	STAIR TREADS AND RISERS TO BE RES-7. ALL OTHER STAIR FLOOR AREAS INCLUDING LANDINGS TO BE RES-2.

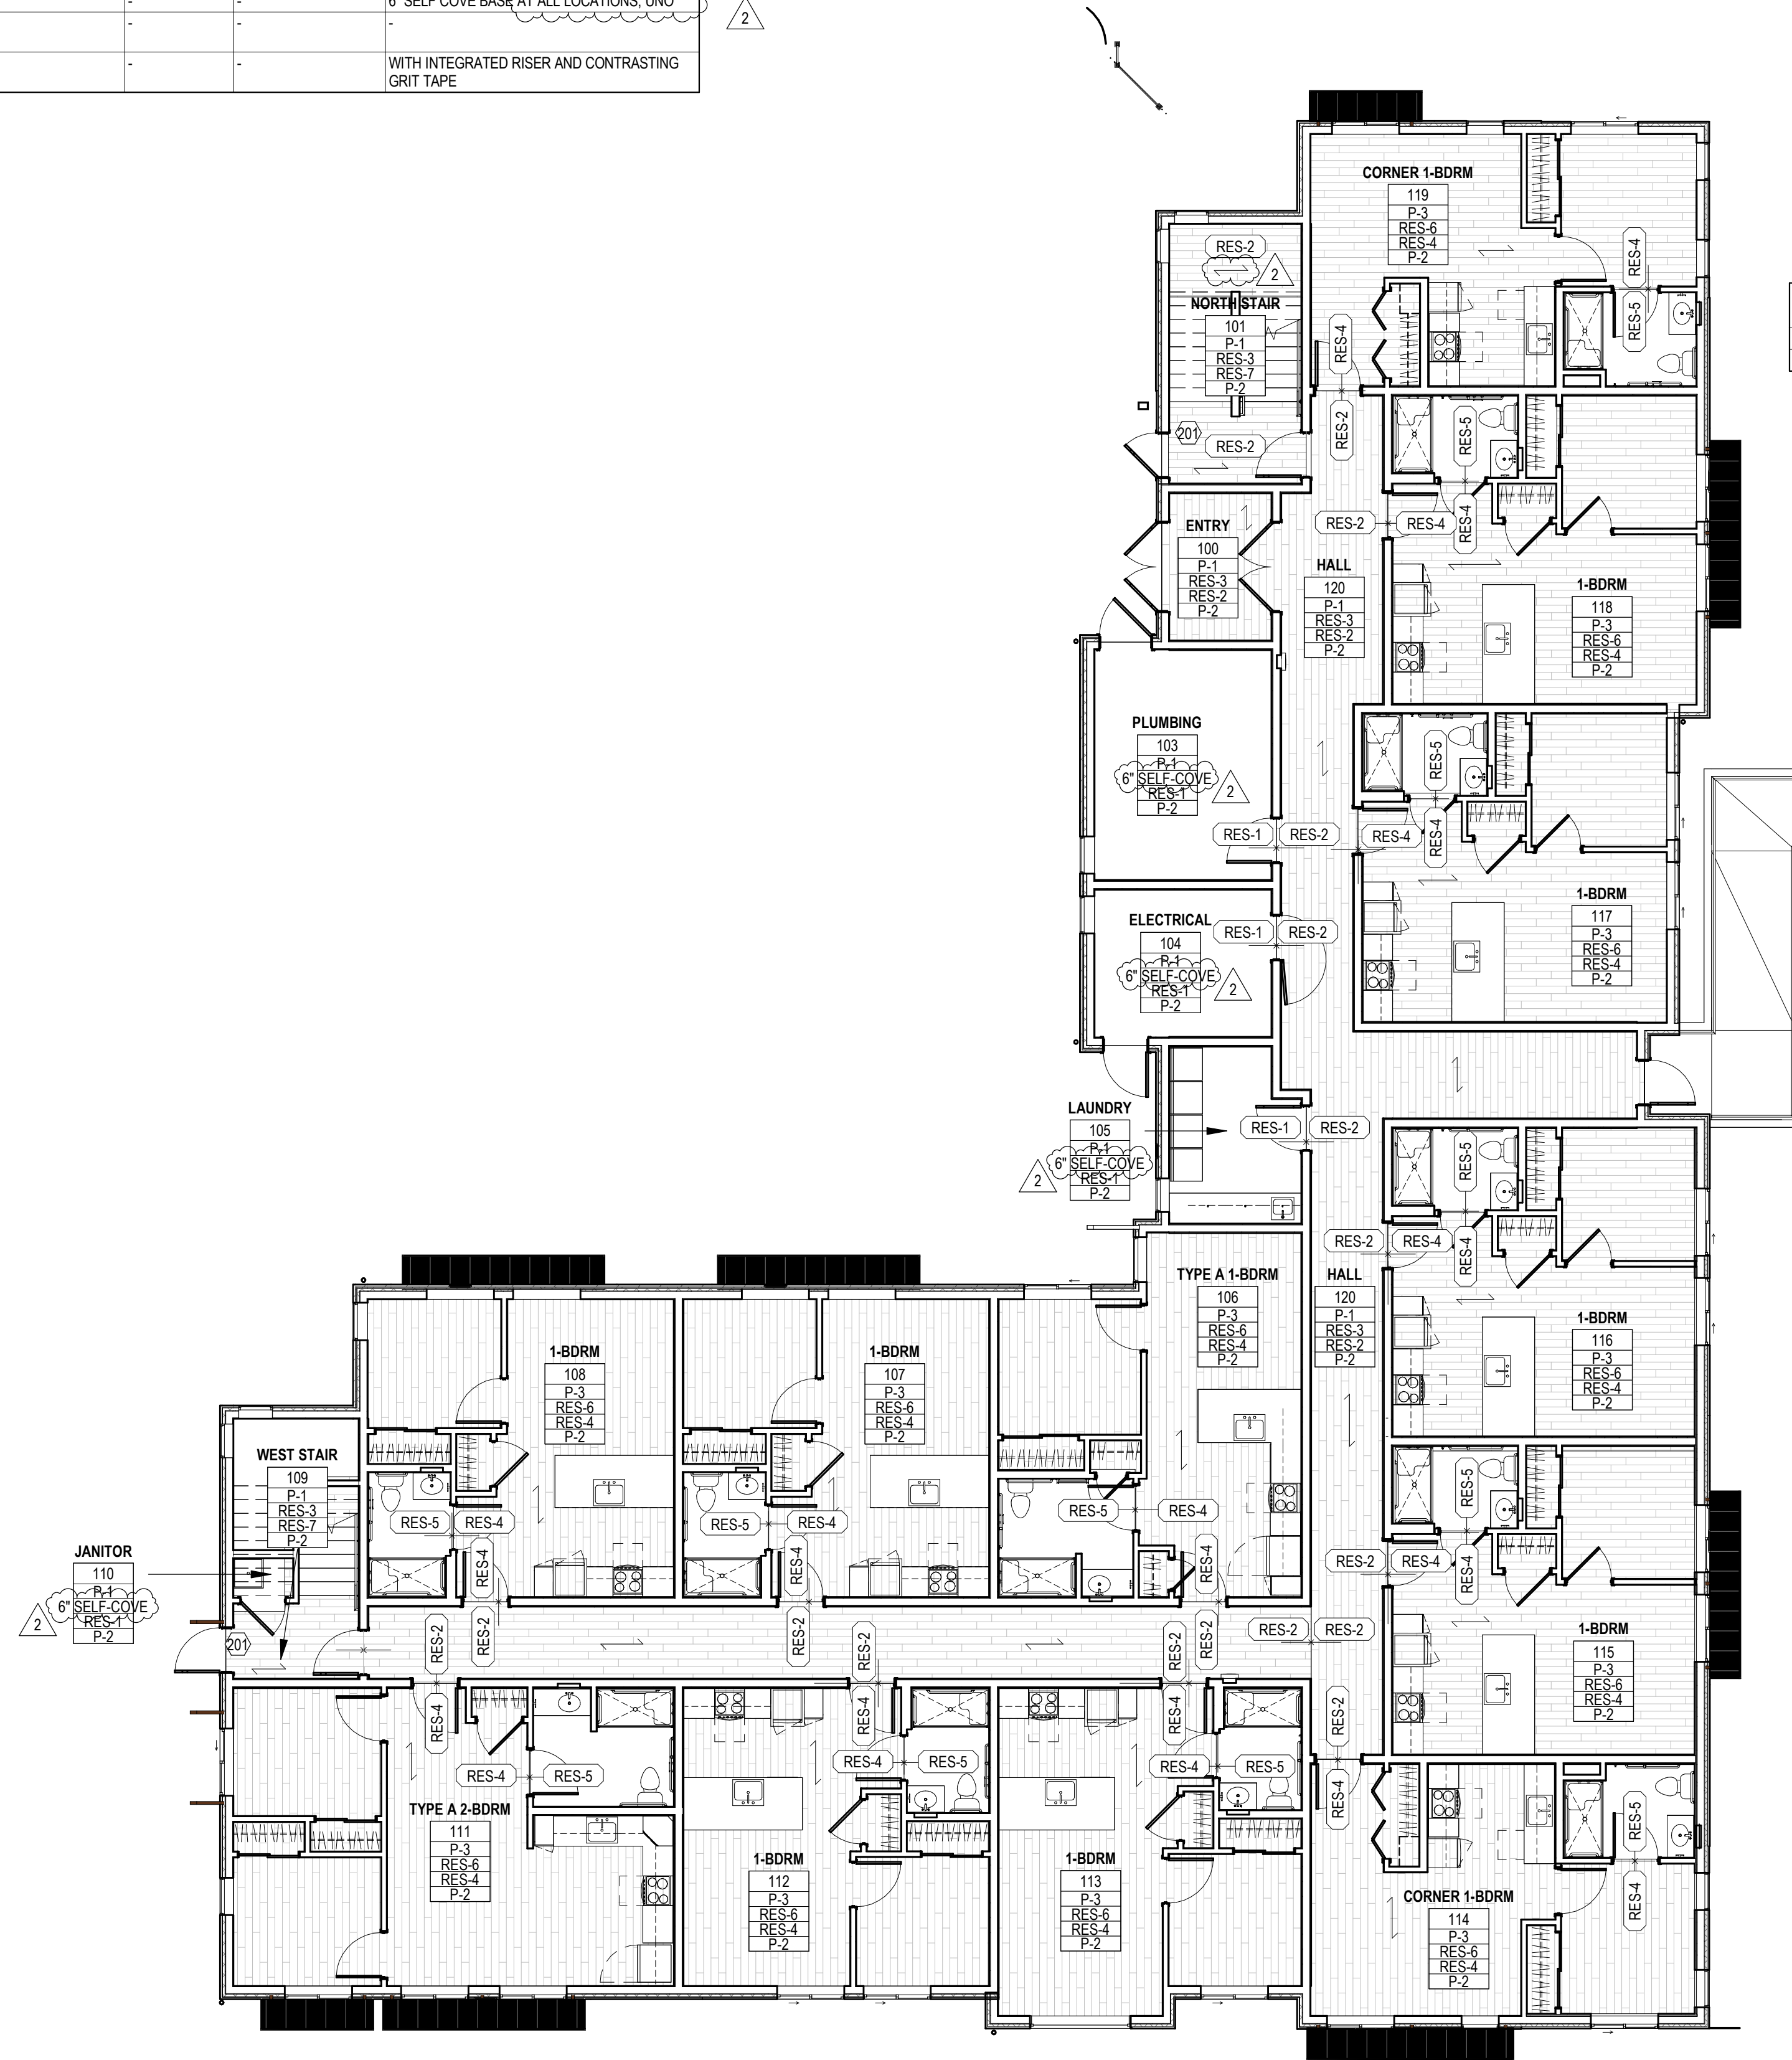

275 FIFTH STREET, SUITE 100
BREMERTON, WA 98337
360-377-8773
RFMARCH.COM

EKLUND AI GALES
PENINSULA HOUSING AUTHORITY
2372 E 7TH AVENUE
PORT ANGELES, WA 98362

 
[illegible]

FINISH PLAN - LEVEL 1, FINISH SCHEDULES

SHEET #

A23.01

1 FINISH PLAN - LEVEL 1
1/8" = 1'-0"



INTERIOR FINISH SCHEDULE									
EXTERIOR	TAG	SPEC #	MATERIAL	MANUFACTURER	PRODUCT	FINISH	CODE	CONTACT	NOTES
INTERIOR	CAB-1	00 00 00	WOOD CABINETS	-	WOOD CABINETS	BIRCH STAINED TO MATCH WILSONART WHITE OAK PB WHEATON	-	-	SHAKER STYLE DOOR
INTERIOR	CAB-2	00 00 00	WOOD CABINETS	-	WOOD CABINETS	BIRCH STAINED TO MATCH WILSONART WHITE OAK PB HONEY	-	-	SLAB STYLE DOOR
INTERIOR	LAM-1	VARIABLES	HIGH PRESSURE LAMINATE	FORMICA	180FX BY FORMICA GROUP 9918-ML BRECCIA MOJAVE	MONOLITH TEXTURE	-	-	COUNTERTOP W/ POSTFORMED DOUBLE-RADIUS EDGE
INTERIOR	LAM-2	09 78 00	HIGH PRESSURE LAMINATE	WILSONART	CALCUTTA MARBLE 4925K-07	TEXTURED GLOSS	-	-	COUNTERTOP W/ POSTFORMED DOUBLE-RADIUS EDGE
INTERIOR	P-1	09 91 00	INTERIOR PAINT	SHERWIN WILLIAMS	SW 7646 FIRST STAR	SEE GENERAL NOTES	-	-	-
INTERIOR	P-2	09 91 00	INTERIOR PAINT	SHERWIN WILLIAMS	SW 7005 PURE WHITE	SEE GENERAL NOTES	-	-	-
INTERIOR	P-3	09 91 00	INTERIOR PAINT	SHERWIN WILLIAMS	SW 7042 SHOJI WHITE	SEE GENERAL NOTES	-	-	-
INTERIOR	RES-1	09 65 00	VINYL SHEET FLOORING	PATCRAFT	1624V SENSE SHEET	00520 ESTEEM	-	-	6" SELF-COVE BASE AT ALL LOCATIONS, UNO
INTERIOR	RES-2	09 65 00	LUXURY VINYL PLANK	EVOKE	COFFEEHOUSE 2.5 COLLECTION	45627 ICED ESPRESSO 2.5	-	-	-
INTERIOR	RES-3	09 65 00	RUBBER BASE	JOHNSONITE	MILLWORK STANCE BASE MW-47-X61	47 BROWN	-	-	-
INTERIOR	RES-4	09 65 00	LUXURY VINYL PLANK	EVOKE	COFFEEHOUSE 2.5 COLLECTION	45627 CAPE LATTE 2.5	-	-	-
INTERIOR	RES-5	09 65 00	VINYL SHEET FLOORING	PATCRAFT	1690V HOLISTIC SHADES	00111 RADIANT	-	-	6" SELF COVE BASE AT ALL LOCATIONS, UNO
INTERIOR	RES-6	09 65 00	RUBBER BASE	JOHNSONITE	MILLWORK STANCE BASE MW-08-X61	08 ICICLE W	-	-	-
INTERIOR	RES-7	09 65 00	STAIR TREAD	JOHNSONITE	ANGLE FIT RUBBER STAIR TREADS	47 BROWN	-	-	WITH INTEGRATED RISER AND CONTRASTING GRIT TAPE

NOTES & LEGEND - FINISH PLAN

1. WALL FINISHES TRANSITION AT INSIDE CORNERS UNO.
2. ALIGN FLOORING TRANSITIONS WITH CENTERLINE OF DOOR LEAF UNO.
3. REFER TO INTERIOR DETAILS FOR FINISH TRANSITIONS.
4. FLOOR FINISH TAGS INDICATE MAJORITY FLOOR FINISH. REFER TO FINISH PLANS FOR TRANSITION LOCATIONS.
5. FLOOR FINISH TO CONTINUE UNDER ANY REMOVABLE CABINETS. REFER TO UNIT SHEET ELEVATIONS FOR REMOVABLE CABINET LOCATIONS.
6. WALLS TO BE FINISHED BEHIND ANY REMOVABLE CABINETS. REFER TO UNIT SHEET ELEVATIONS FOR REMOVABLE CABINET LOCATIONS.
7. TYPICAL PAINT FINISHES UNO, WALLS: EGGSHELL; TRIM: SEMI-GLOSS; CEILING: FLAT; DOORS & FRAMES: SEMI-GLOSS; ALL TOILET AND LAUNDRY WALLS AND CEILINGS TO BE WASHABLE EPOXY PAINT.
8. ALL EXPOSED MECHANICAL GRILLES, WALL DIFFUSERS, ELECTRICAL PANELS, ACCESS PANELS, ETC TO BE PAINTED TO MATCH ADJACENT WALL SURFACE.
9. ALL RUBBER BASE TO BE ADHERED AT TOP, BOTTOM AND SEAMS.
10. SWITCH PLATES, OUTLET COVERS AND OTHER DEVICES TO BE WHITE, UNO.
11. HANDRAIL TO BE INSTALLED PER PLAN. HANDRAIL TO TERMINATE INTO WALL AT 90 DEGREE ANGLE. COORDINATE HANDRAIL EXTENTS WITH OWNER AND DESIGNER.
12. CORNER GUARDS TO BE INSTALLED AT ALL OUTSIDE CORNERS, UNO. ALL CORNER GUARDS TO BE FULL HEIGHT FROM TOP OF BASE.

CONFERENCE ROOM
100
FIN-1
FIN-2
FIN-3
FIN-4


ROOM TAG W/ TYP ROOM FINISHES
WALL
BASE
FLOOR
CEILING

FIN-1 FIN-2
FLOOR FINISH TRANSITION
TRANSITION LINE

FINISH DIRECTION
ACCENT WALL FINISH EXTENT
LVT
RESILIENT SHEET FLOORING

KEY NOTES - FINISH PLAN

#	NOTE DESCRIPTION
201	STAIR TREADS AND RISERS TO BE RES-7, ALL OTHER STAIR FLOOR AREAS INCLUDING LANDINGS TO BE RES-2.

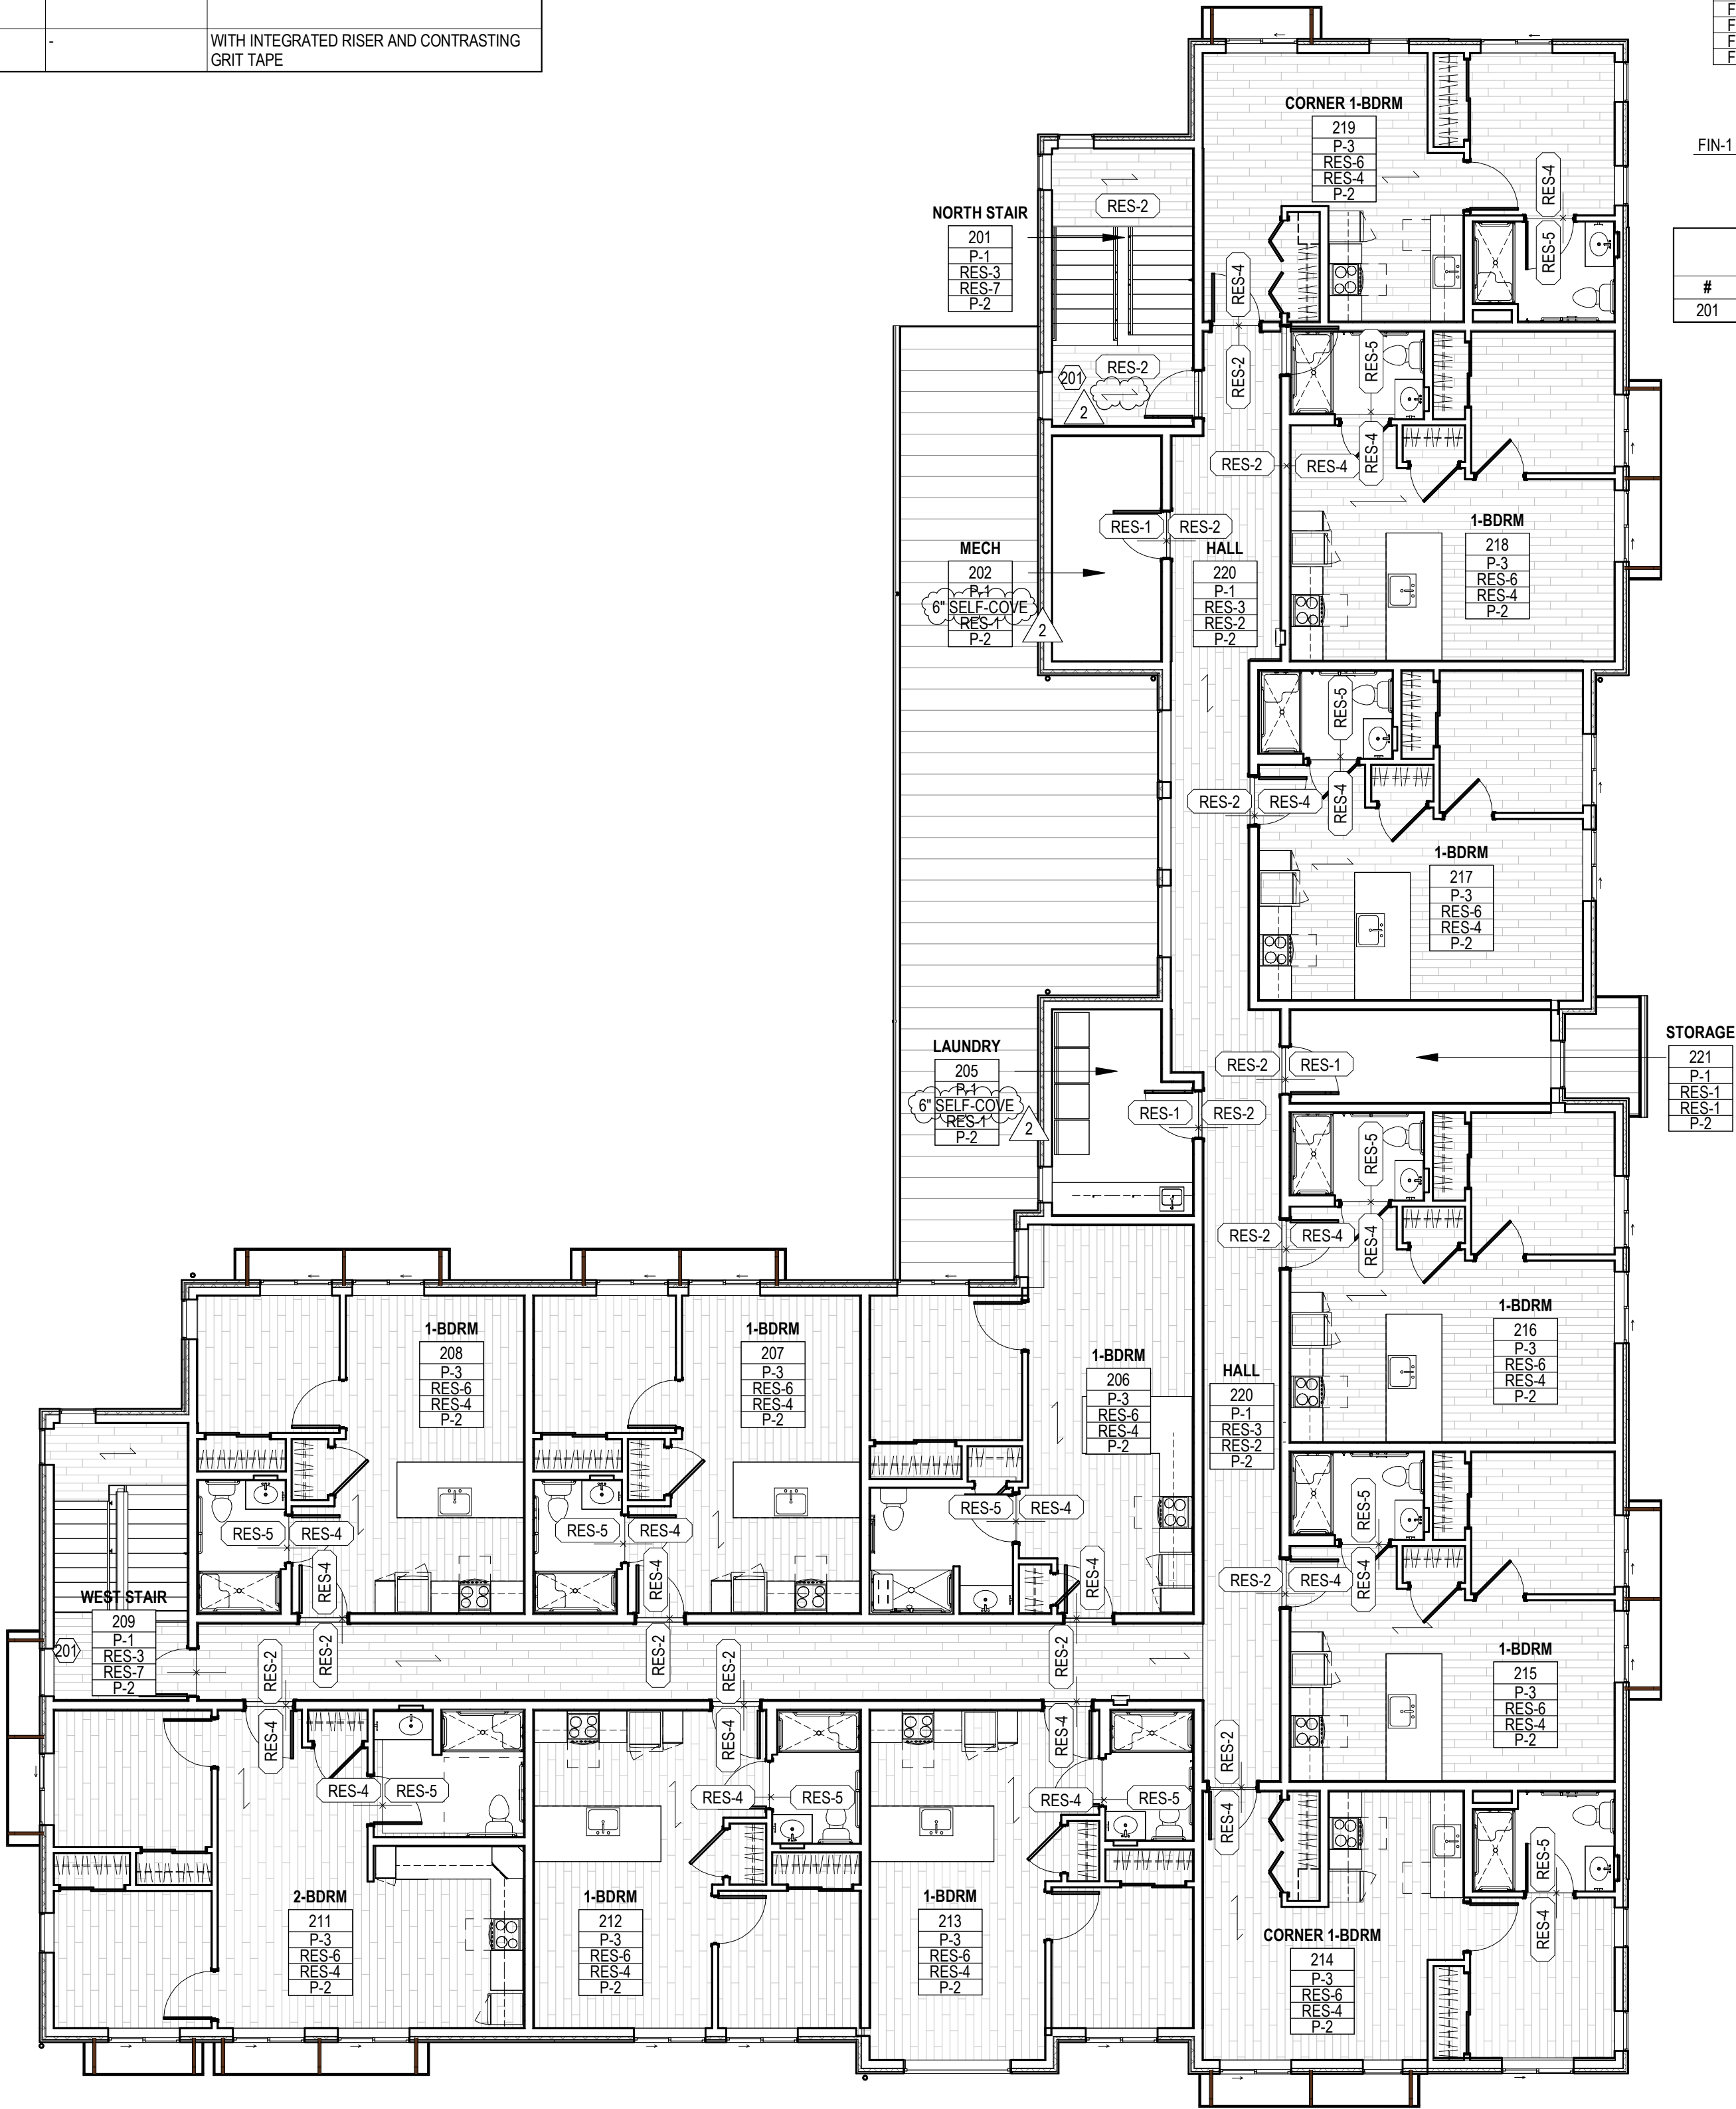

1 FINISH PLAN - LEVEL 2
1/8" = 1'-0"

2	ADDENDUM #2	08/21/2026

NOTES & LEGEND - REFLECTED CEILING PLAN

1. ARCHITECTURAL RCP PROVIDED FOR COORDINATION PURPOSES ONLY. REFER TO MEP DRAWINGS FOR DETAILED SCOPE OF SYSTEMS.
2. CEILING FIXTURES ARE CENTERED IN CEILING TILE OR CENTERED IN ROOM, UNO.
3. DIMENSIONS IN CEILING PLANS ARE TO FACE OF FINISH, UNO.
4. GRAPHIC REPRESENTATION OF LIGHTING TYPES MAY BE NOT TO SCALE.
5. CEILING GRID IS CENTERED IN ROOM, UNO.
6. ALL GWB CEILINGS & SOFFITS TO BE PAINTED P-2, UNO.
7. ALL EXPOSED MECHANICAL GRILLES, WALL DIFFUSERS, ELECTRICAL PANELS, ACCESS PANELS, ETC TO BE PAINTED TO MATCH ADJACENT WALL SURFACE.

CEILING	MEP
ACT 2X2	RECESSED DOWNLIGHT
GYP AT UNDERSIDE OF STRUCTURE	PENDANT LINEAR
EXTERIOR ROOF DECKING	PENDANT ROUND
	SURFACE MOUNT LINEAR
	SURFACE WALL LINEAR
	SURFACE MOUNT ROUND
	SURFACE MOUNT STRIP
	UNDER CABINET
	EXTERIOR LIGHTING
	SEE MECHANICAL, SIZES MAY VARY



[illegible]

AHJ APPROVAL STAMP

REFLECTED CEILING
PLAN - LEVEL 2

SHEET #

A24.02

1. ARCHITECTURAL RCP PROVIDED FOR COORDINATION PURPOSES ONLY. REFER TO MEP DRAWINGS FOR DETAILED SCOPE OF SYSTEMS.
2. CEILING FIXTURES ARE CENTERED IN CEILING TILE OR CENTERED IN ROOM. UNO.
3. DIMENSIONS IN CEILING PLANS ARE TO FACE OF FINISH. UNO.
4. GRAPHIC REPRESENTATION OF LIGHTING FIXTURES MAY BE NOT TO SCALE.
5. CEILING GRID IS CENTERED IN ROOM. UNO.
6. ALL GWB CEILINGS & SOFFITS TO BE PAINTED P-2. UNO.
7. ALL EXPOSED MECHANICAL GRILLES, WALL DIFFUSERS, ELECTRICAL PANELS, ACCESS PANELS, ETC TO BE PAINTED TO MATCH ADJACENT WALL SURFACE.

MEP

ACT 2X2


EXTERIOR ROOF DECKING

SEE MECHANICAL,
SIZES MAY VARY


NOTE DESCRIPTION

#	NOTE DESCRIPTION
230	INSULATED ACCESS DOOR

REFLECTED CEILING PLAN - LEVEL 2
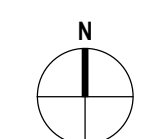
$$1/8" = 1'-0"$$


PHA EKLUND HEIGHTS FIXTURES & EQUIPMENT					
PRODUCT					
KITCHEN PLUMBING					
ITEM	PRODUCT	MANUFACTURER	DESCRIPTION/FINISH		ADDITIONAL DETAILS
Kitchen Faucet	Riley 7402SR5	Moen	One-Handle High Arc Pulldown Kitchen Faucet	Spot Resist Stainless	No Escutcheon Plate No Soap Dispenser
Kitchen Sink	GS181733B	Moen	Prep 25" Drop-in Single Bowl Sink	Stainless Steel	Single Hole - 5.5" deep
BATHROOM PLUMBING					
ITEM	PRODUCT	MANUFACTURER	DESCRIPTION/FINISH		ADDITIONAL DETAILS
Bathroom Faucet	Liso 84540RN	Moen	Single Handle	Spot Resistant Brushed Nickel	No Escutcheon Plate
Bathroom Sink	Aqualyn 0475047.020	American Standard	Single Hole Drop In Sink	White	
Toilet	Edgemere 765AA101.020	American Standard	Edgemere Two-Piece 1.28 gpf/4.8 Lpf Chair Height Elongated Toilet with Seat	White	
Shower Trim	Awaken G110 K-72419-G-BN	Kohler	Three-function showerhead, 1.75 gpm	Vibrant Brushed Nickel	WaterSense
Transfer Valve	Elate K-T35325-4-BN	Kohler	Rite-Temp® valve trim with diverter	Vibrant Brushed Nickel	
Handshower	Awaken G110 K-99242-G-BN	Kohler	30" deluxe three-function handshower kit, 1.75 gpm	Vibrant Brushed Nickel	
Shower Surround	APFQ6233BFF875	Freedom Shower	One-piece ADA Roll-In Shower with Center Drain	White	Shower can be oriented with shower seat on the left or right side. Refer to overall floor plans for shower orientation.
BATHROOM ACCESSORIES					
ITEM	PRODUCT	MANUFACTURER	DESCRIPTION/FINISH		ADDITIONAL DETAILS
Grab/Towel Bar - 24"	Contemporary 24" Towel Bar P5124BN	Moen	24"L	Brushed Nickel	
Toilet Paper Holder	Contemporary Toilet Paper Holder P5050BN	Moen		Brushed Nickel	
Towel Ring	Contemporary Towel Ring P5860BN	Moen		Brushed Nickel	
Vanity Medicine Cabinet	Embark K-55062-NA	Kohler		N/A	
Shower Curtain Rod	#5F2143BN	Moen		Brushed Nickel	
Shower Threshold Adapter	APFSPT36-60IN	Freedom Shower	Semi Permanent Threshold Adapter	White	
Collapsible Water Dam (Type A Units Only)	APFCWRW3	Freedom Shower	Collapsible Water Dam Retainer	White	Size to shower
CABINET HARDWARE					
ITEM	PRODUCT	MANUFACTURER	DESCRIPTION/FINISH		ADDITIONAL DETAILS
Cabinet Pulls		Richelieu	Modern Metal Pull - 873	Brushed Nickel	
APPLIANCES (STANDARD)					
ITEM	PRODUCT	MANUFACTURER	ALL APPLIANCES TO BE PURCHASED FROM METROPOLITAN APPLIANCE. CONTACT: dan@metropolitanappliance.com		ADDITIONAL DETAILS
Refrigerator	FF1088W	SUMMIT	10.1 Cu. Ft. Top-Freezer Refrigerator	White	
Range	REX2421WRT	SUMMIT	ENERGY STAR® 24" Electric Free-Standing Front-Control Electric Range	White	
Dishwasher	DW242WADA	SUMMIT	ENERGY STAR® 24" Top Control	White	
Range Hood	GLA1243WW	BROAN	ENERGY STAR 24" RANGE HOOD	White	Can be installed for ADA compliance with the purchase of model HAWSK3 low voltage wiring and wall switch.
Refrigerator (Type A Units Only)	GBE17HYR	GE	ENERGY STAR®17.7 Cu. Ft. Bottom Freezer Refrigerator Counter Depth	White	

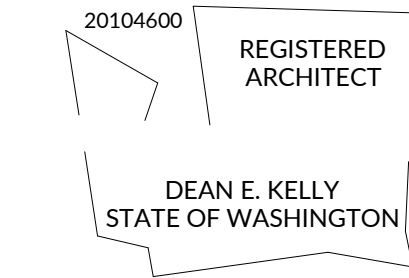

EKLUND AT GALES

PENINSULA HOUSING AUTHORITY

2372 E 7TH AVENUE
PORT ANGELES, WAS 98362

PROJECT #		2023093.02
PERMIT SET		
ISSUE DATE		JULY 26, 2026
REVISION SCHEDULE		
2	ADDENDUM #2	08/21/2026



UNIT EQUIPMENT
SCHEDULE

OPERABLE PARTS OF DOOR
HARDWARE SHALL COMPLY WITH
ANSI 117.1 SECTIONS 308 & 404.2.6,
AND SHALL BE 34" MIN AND 48"
MAX AFF.

2" SEE SCHED 2"

2"

SEE SCHEDULE

FIN FLOOR

FRAME TYPES

01

FIN FLOOR

DOOR TYPES

A
SINGLE FLUSH
DOOR


B
DOUBLE SLIDER
DOOR

C
BI-FOLD DOOR


Diagram illustrating three types of shelving units and their dimensions:

- R/S SINGLE SHELF W/ ROD:** Total height is 7'-0". Shelf height is 1'-0".
- (2) R/S DOUBLE SHELF W/ ROD:** Total height is 7'-0". Shelf spacing is 3'-6". Shelf height is 1'-0".
- 5S FIVE SHELVES:** Total height is 6'-4". Shelf spacing is 1'-4". Shelf height is 1'-4".


NOTE: OMIT BOTTOM SHELF @ ACCESSIBLE UNITS

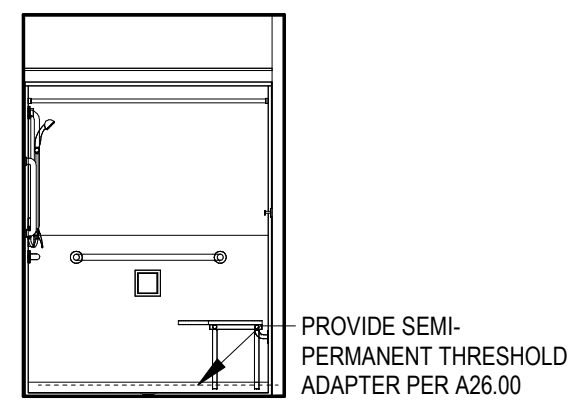


8 TYPICAL UNIT BATHROOM - WEST
1/4" = 1'-0"

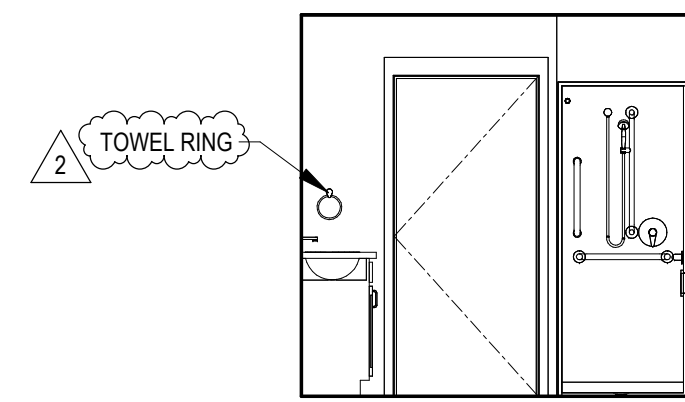


7 TYPICAL UNIT BATHROOM - SOUTH
1/4" = 1'-0"

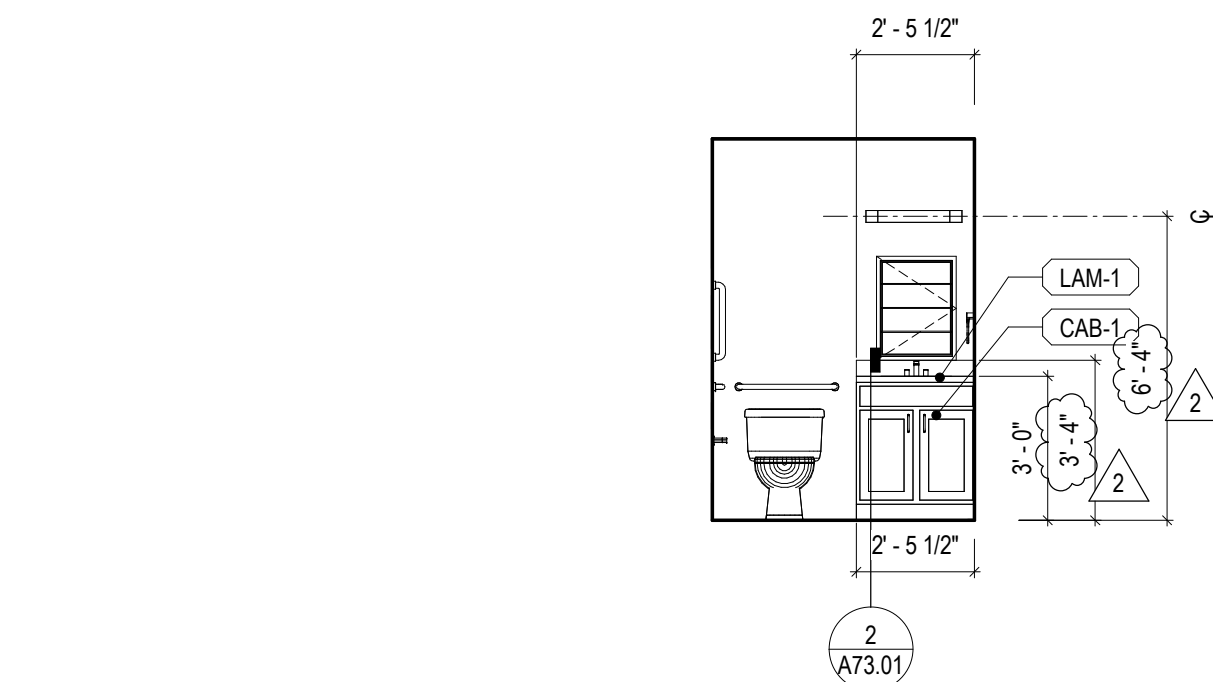


6 TYPICAL UNIT BATHROOM - EAST
1/4" = 1'-0"

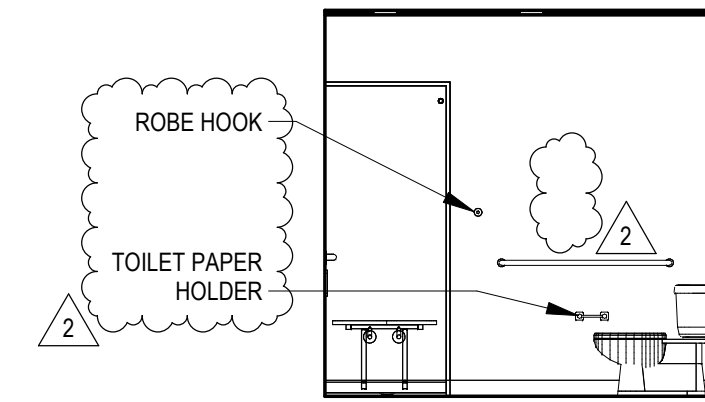


5 TYPICAL UNIT BATHROOM - NORTH
1/4" = 1'-0"

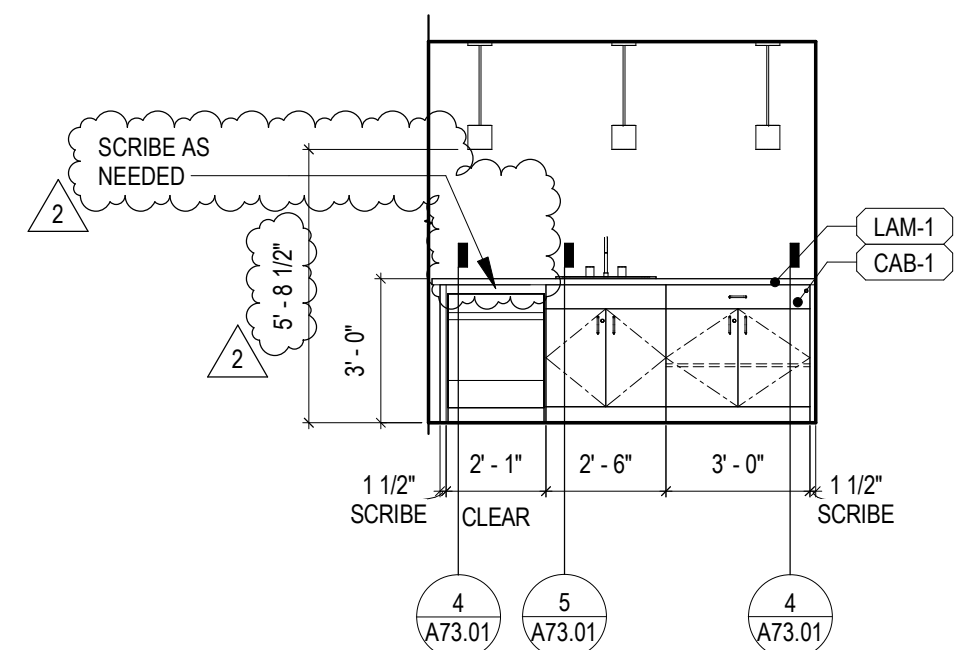


4 TYPICAL UNIT KITCHEN - EAST
1/4" = 1'-0"

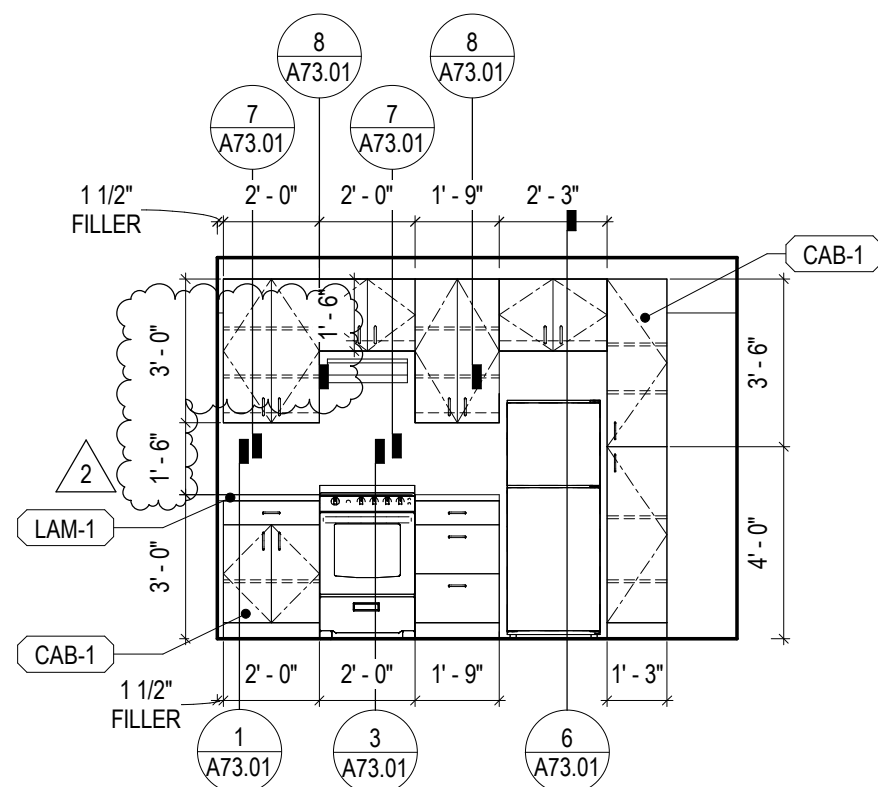

3 TYPICAL UNIT KITCHEN - WEST

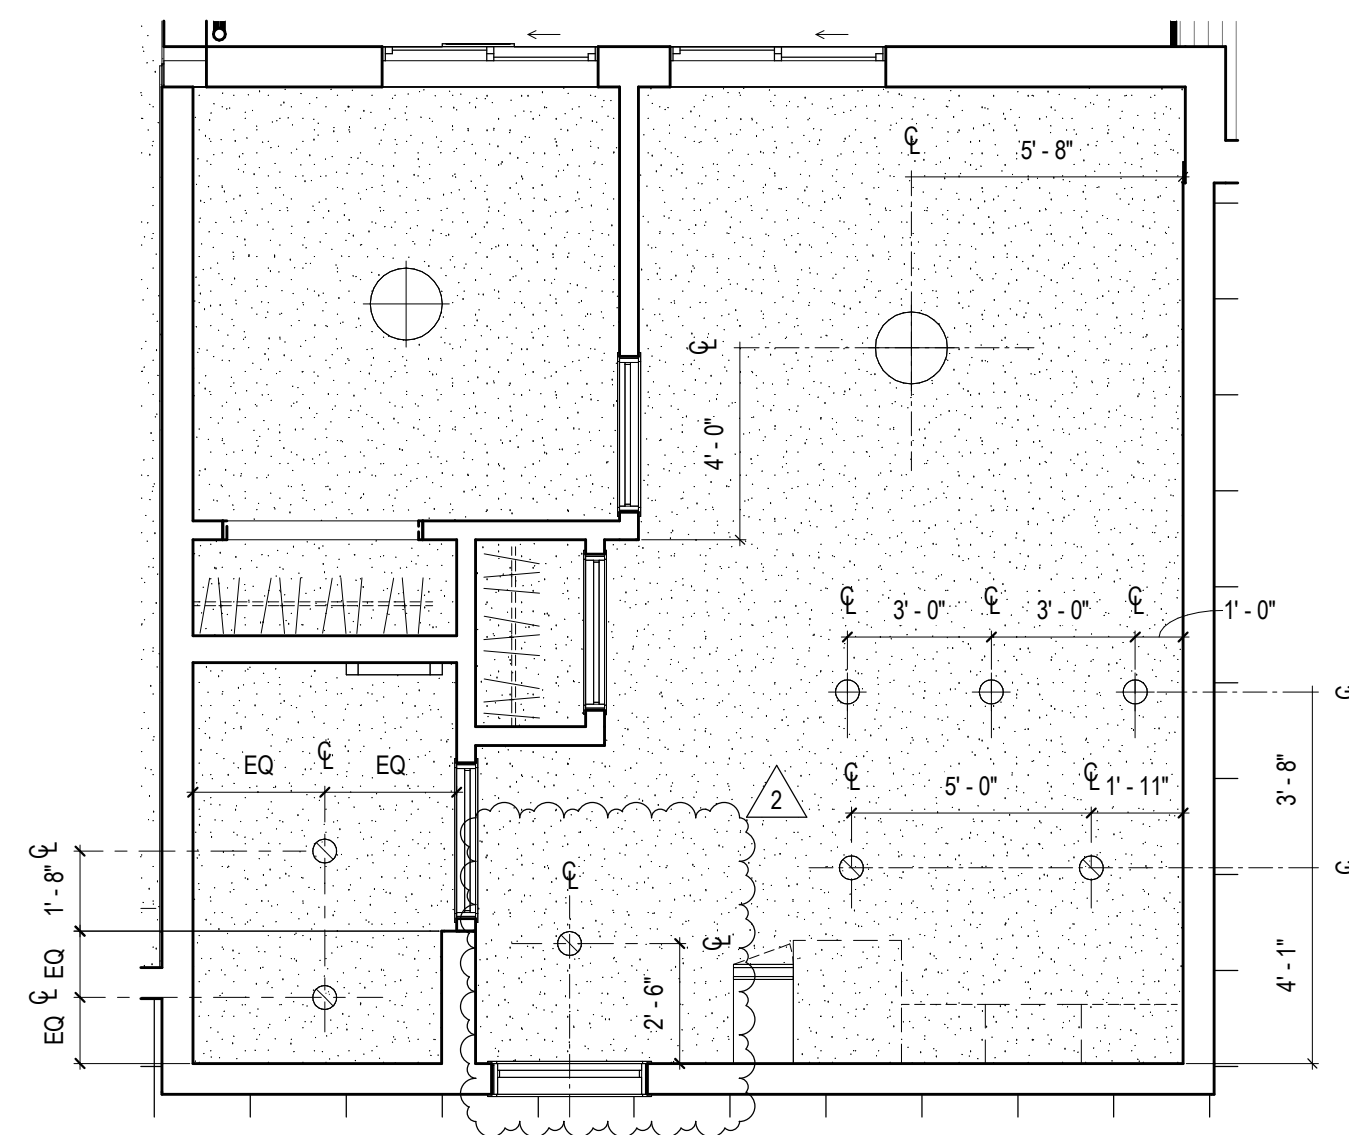

2 TYP. UNIT RCP
1/4" = 1'-0"

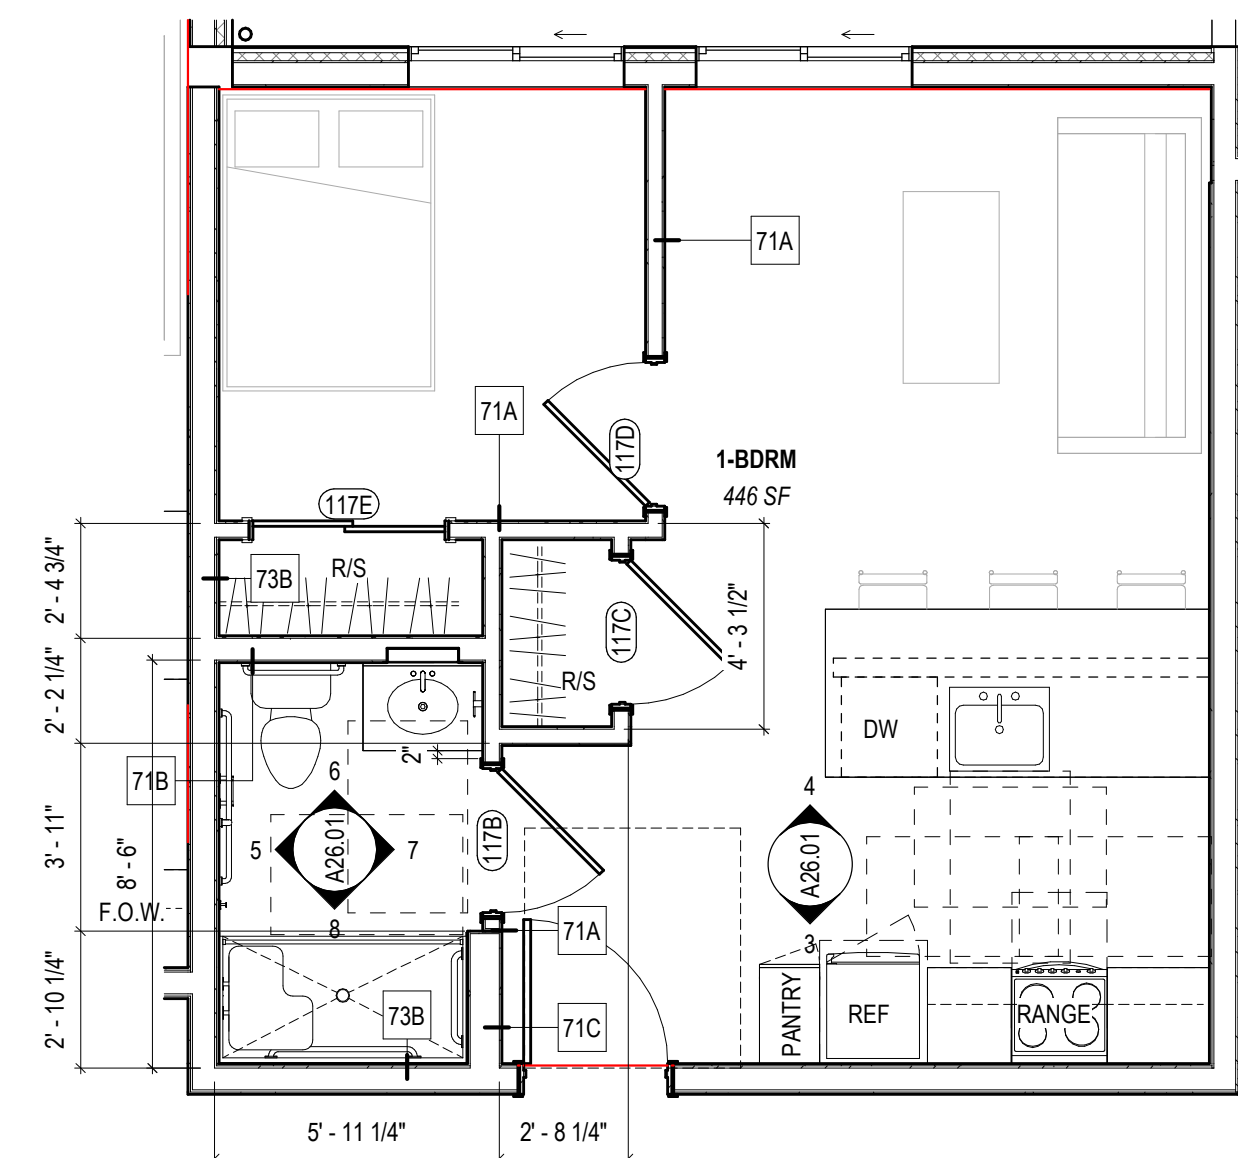

1 TYP. 1-BEDROOM UNIT FLOOR PLAN
1/4" = 1'-0"

PLAN ELEVATION	THERMOSTAT • MOUNTED 48" AFF FROM CENTERLINE, TYP UNO.	PLAN ELEVATION	18" TOWEL BAR • MOUNT 3'-10" AFF FROM CENTERLINE AND 1'-2" AWAY FROM EDGE OF SHOWER ENCLOSURE WALL FROM CENTERLINE, TYP UNO.	PLAN ELEVATION	ROBE HOOK • MOUNT 3'-10" AFF FROM CENTERLINE AND 7" AWAY FROM WALL WALL EDGE FROM CENTERLINE, TYP UNO.
PLAN ELEVATION	DECORATIVE MIRROR/MEDICINE CABINET • MOUNT 3'-4" AFF FROM BOTTOM OF REFLECTIVE SURFACE, TYP UNO. • DECORATIVE WOOD-FRAMED MIRRORS TO MATCH CABINETS, TYP UNO.	PLAN ELEVATION	HAND TOWEL RING • MOUNT 3'-8" AFF FROM CENTERLINE AND 11" AWAY FROM EDGE OF VANITY, TYP UNO.	PLAN ELEVATION	TOILET PAPER HOLDER • MOUNT 1'-8" AFF FROM CENTERLINE AND 2'-8" AWAY FROM FACE OF TOILET WALL FROM CENTERLINE, TYP UNO.
PLAN ELEVATION	ELECTRICAL PANEL - • MOUNT 2'-0" AFF FROM BOTTOM OF PANEL, TYP UNO.	PLAN ELEVATION	RECESSED MEDICINE CABINET - • MOUNT 4'-6" AFF FROM CENTERLINE AND 11" AWAY FROM EDGE OF VANITY, TYP UNO. • INSTALL WITH HINGE SIDE ON INSIDE CORNER OF THE WALL.		

DOOR #	ROOM NAME	DOOR INFORMATION						FRAME INFORMATION				FIRE RATING	HARDWARE GROUP	COMMENTS
		TYPE	MATERIAL	FINISH	GLAZING	HEIGHT	WIDTH	THICKNESS	FRAME TYPE	MATERIAL	FINISH			
117B	1-BDRM	A	WD	P-2	N/A	6'-8"	3'-0"	1 3/8"	01	WD	P-2	U-2.0		
117C	1-BDRM	A	WD	P-2	N/A	6'-8"	3'-0"	1 3/8"	01	WD	P-2	U-3.0		
117D	1-BDRM	A	WD	P-2	N/A	6'-8"	3'-0"	1 3/8"	01	WD	P-2	U-2.0		
117E	1-BDRM	B	WD	P-2	N/A	6'-8"	4'-0"	1 3/8"	01	WD	P-2	U-5.0		

1. SEE SHEET A02.00 GENERAL NOTES FOR DIMENSIONING, GRAPHICS, ABBREVIATIONS, AND OTHER STANDARDS.

2. SEE SHEET A23.01 AND A23.02 FOR FINISH TRANSITION LOCATIONS.

3. SEE SHEET A26.00 FOR UNIT FIXTURE AND EQUIPMENT SCHEDULE.

4. DIMENSIONS ARE TO ROUGH FINISHES OR TO FACE OF EXISTING FINISHES, TYP. UNL.

5. DIMENSIONS INDICATED AS "MIN" OR "CLR" ARE FROM NEAREST FINISH SURFACE, INCLUDING TRIM.

6. ROUGH DOOR OPENINGS ARE LOCATED 6" FROM NEAREST INTERSECTING WALL FRAMING OR CENTERED BETWEEN NEAREST ADJACENT INTERSECTING WALLS.

7. PROVIDE BLOCKING FOR GRAB BAR INSTALLATION. REFER TO SHEET A41.01 FOR GRAB BAR LOCATIONS.

8. FLOOR FINISH TO CONTINUE UNDER ANY REMOVABLE CABINETS. REFER TO UNIT ELEVATIONS FOR REMOVABLE CABINET LOCATIONS.

9. PROVIDE 1/2" TO 3/4" UNFINISHED BENCH OR SILL UNDER SINKS. PROVIDE 1/2" TO 3/4" UNFINISHED BENCH OR SILL UNDER CABINETS.

10. FLOOR DRAINS TO BE PROVIDED IN BATHROOMS AND UNDER DISHWASHER. COORDINATE LOCATIONS WITH PLUMBING.

1. ARCHITECTURAL RCP PROVIDED FOR COORDINATION PURPOSES ONLY. REFER TO MEP DRAWINGS FOR DETAILED SCOPE OF SYSTEMS.

2. CEILING FIXTURES ARE CENTERED IN CEILING TILE OR CENTERED IN ROOM, UNO.


3. DIMENSIONS IN CEILING PLANS ARE TO FACE OF FINISH, UNO.

4. GRAPHIC REPRESENTATION OF LIGHTING TYPES MAY BE NOT TO SCALE.

5. CEILING GRID IS CENTERED IN ROOM, UNO.

6. ALL GWB CEILINGS & SOFFITS TO BE PAINTED P-2, UNO.

7. ALL EXPOSED MECHANICAL, GRILLES, WALL DIFFUSERS, ELECTRICAL PANELS, ACCESS PANELS, ETC TO BE PAINTED TO MATCH ADJACENT WALL SURFACE.

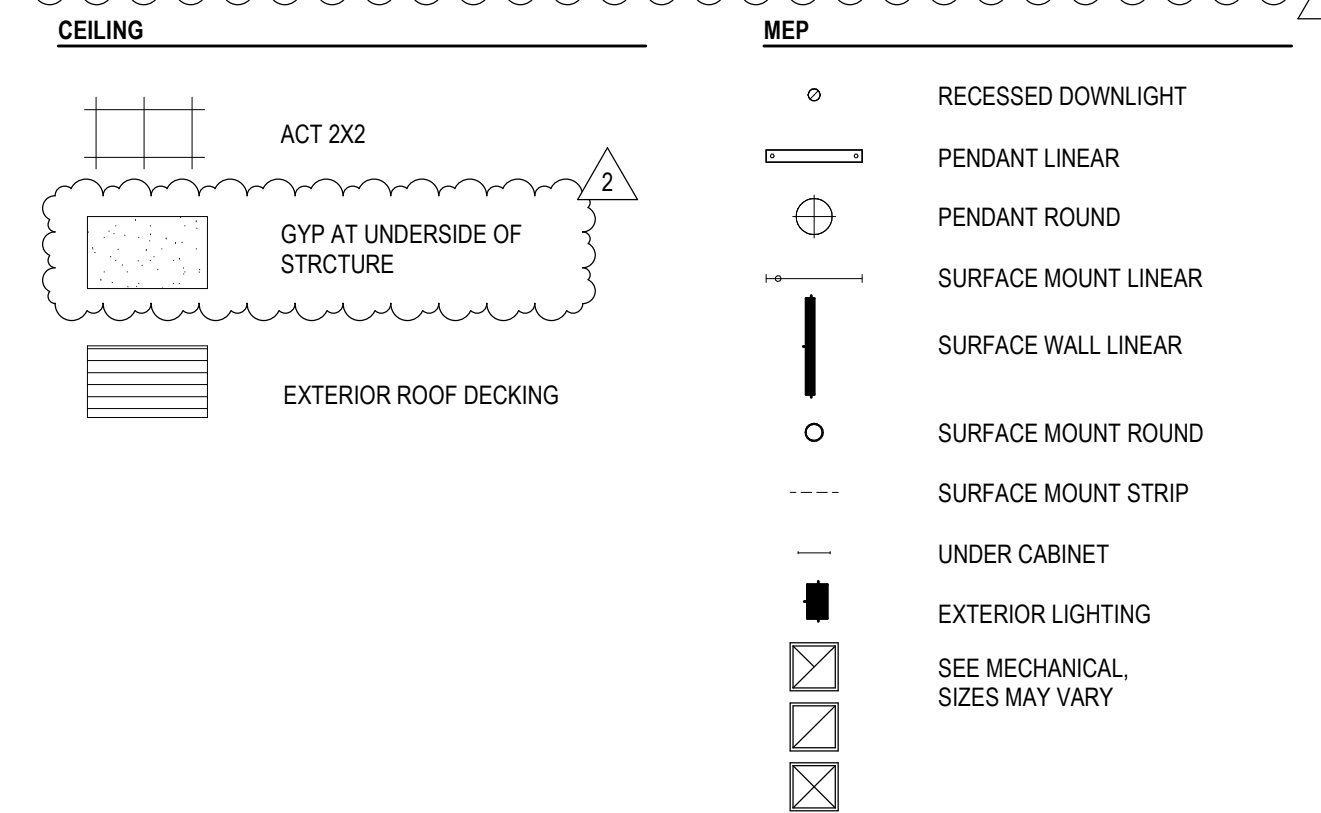

OPERABLE PARTS OF DOOR
HARDWARE SHALL COMPLY WITH
ANSI 117.1 SECTIONS 308 & 404.2.6,
AND SHALL BE 34" MIN AND 48"
MAX AFF.

Diagram of a single door frame. The top width is labeled "2\" SEE SCHED 2\"". The left height is labeled "2\" SEE SCHEDULE". The frame is shown on a "FIN FLOOR" line. Below the diagram is the label "FRAME TYPES 01".

Diagram of three door types labeled A, B, and C, shown on a "FIN FLOOR" line.

- A SINGLE LEAF**: A single door leaf with a diagonal dashed line indicating the swing.
- B DOUBLE SLIDER**: Two door leaves with a horizontal arrow indicating the sliding direction.
- C SLIDING DOOR**: A door system with multiple vertical panels and diagonal dashed lines indicating the swing.

CEILING HEIGHT

7'-0"

1'-0"

3'-6"

3'-6"

1'-0"

6'-4"

1'-4"

1'-4"

1'-4"

1'-4"

2'-0"





OMIT
BOTTOM
SHELF @
ACCESSIBLE
UNITS

R/S
SINGLE SHELF
w/ ROD





(2) R/S
DOUBLE SHELF
w/ ROD

5S
FIVE SHELVES

PROVIDE BLOCKING 3'-0" OC AT ALL SHELF LOCATIONS, TYP

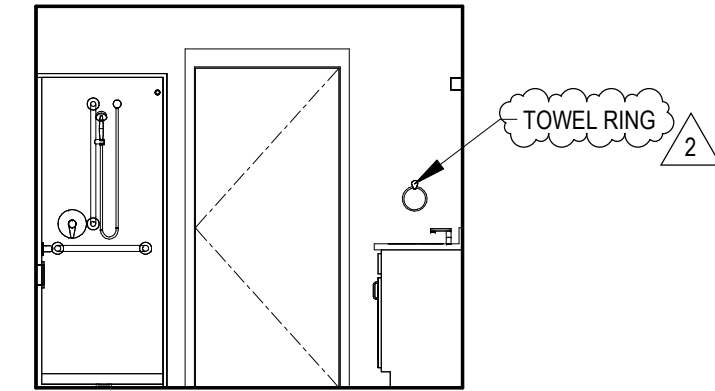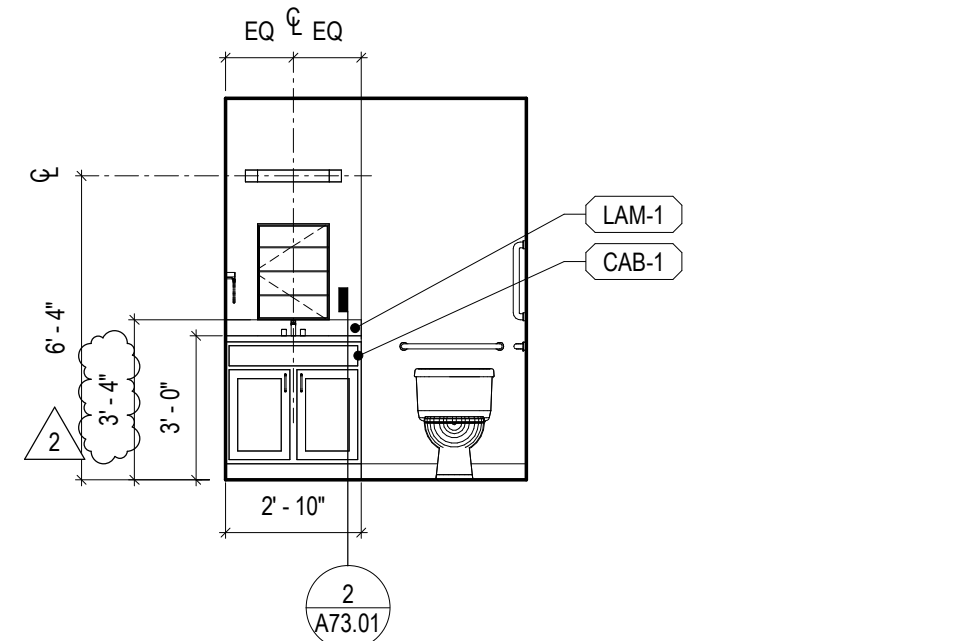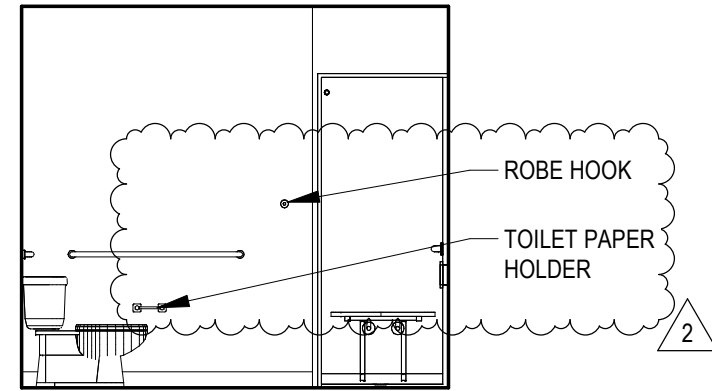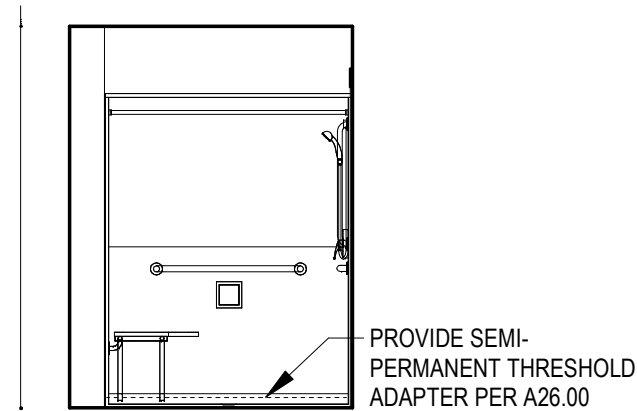

5 CORNER UNIT BATHROOM - NORTH
1/4" = 1'-0"

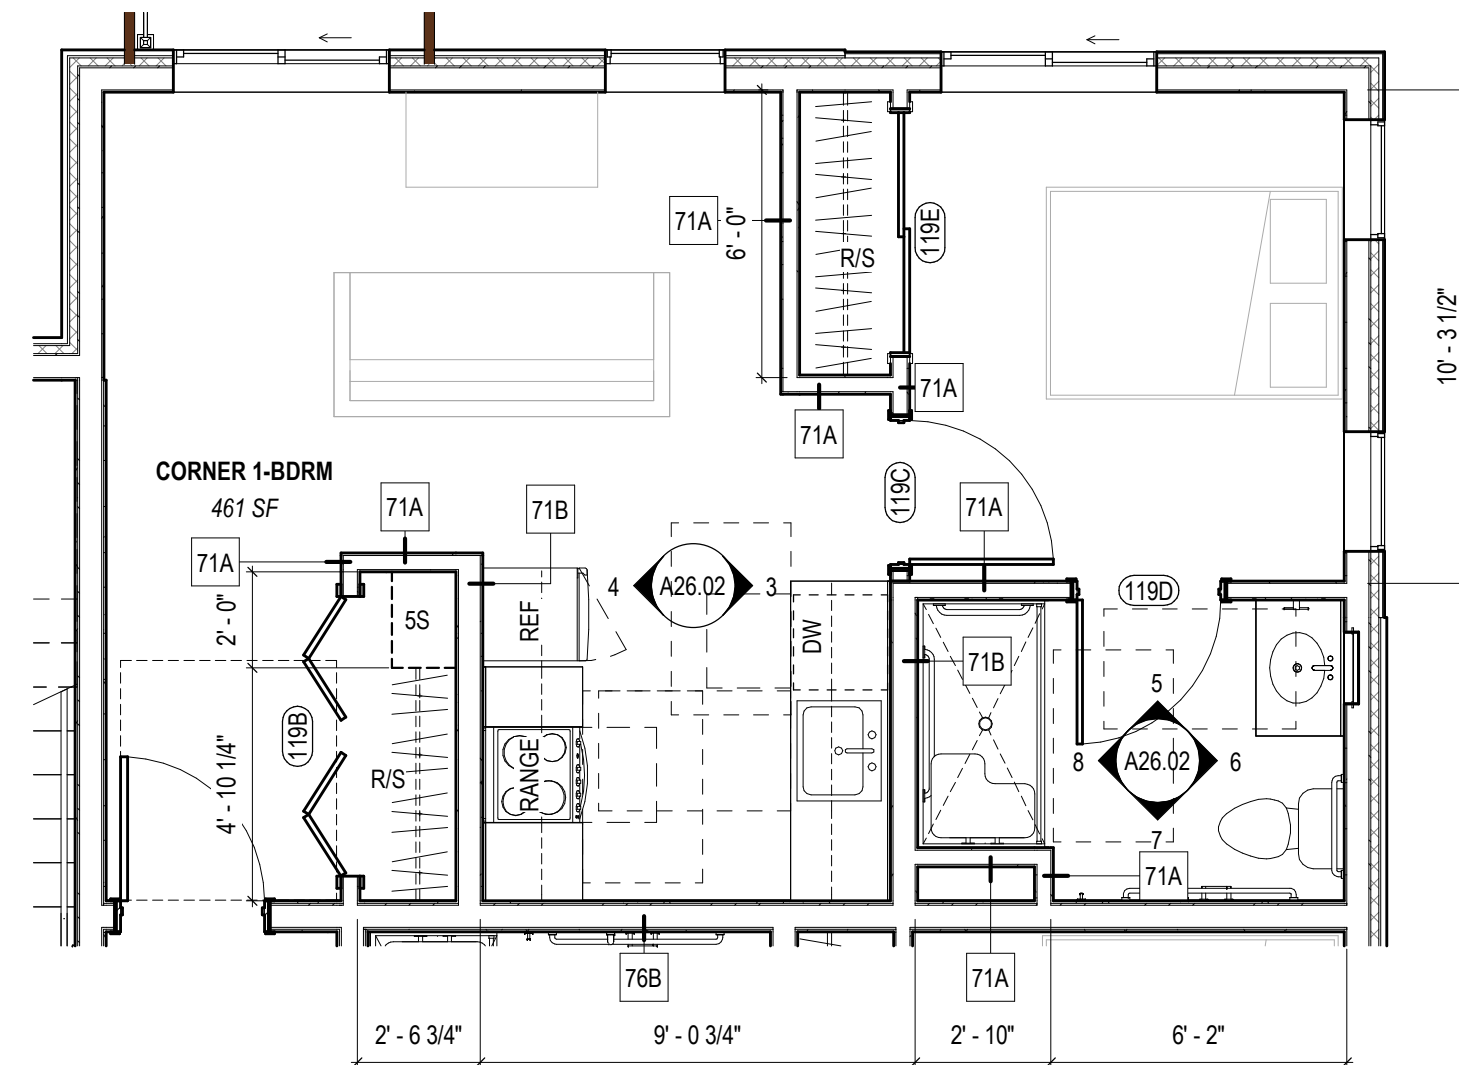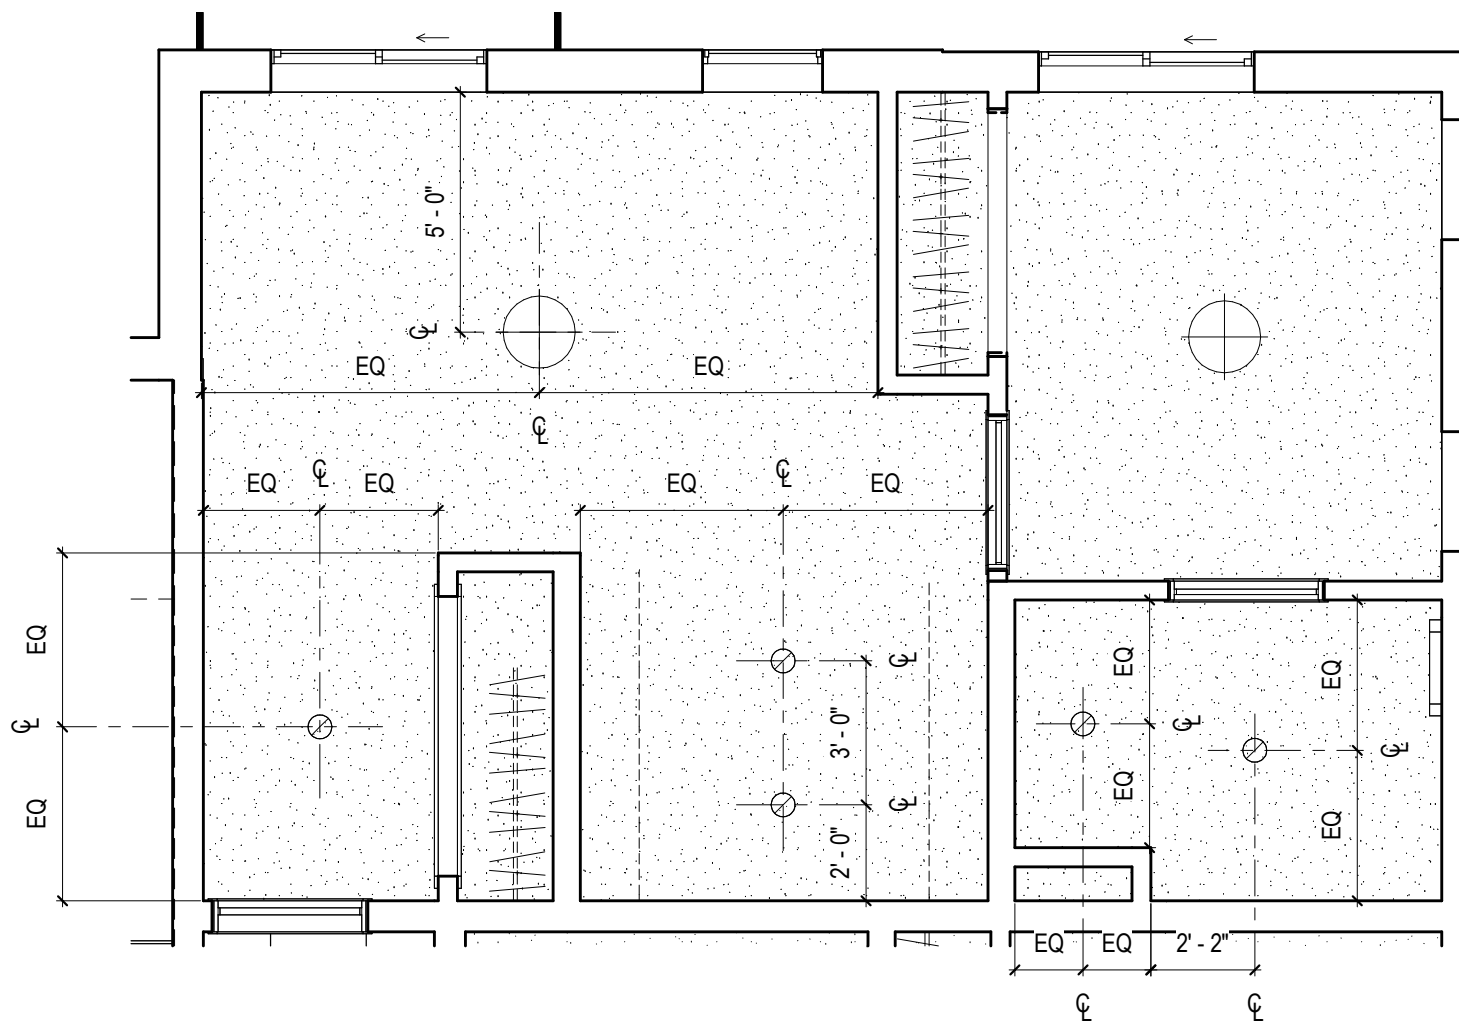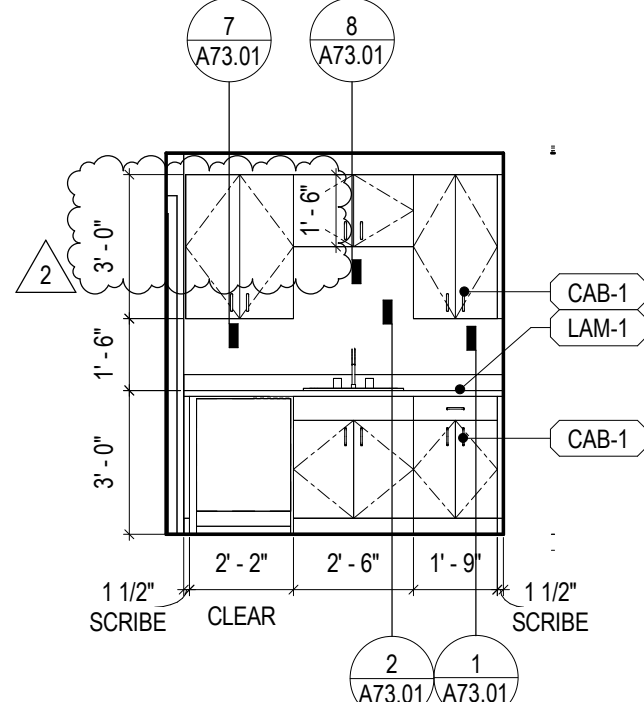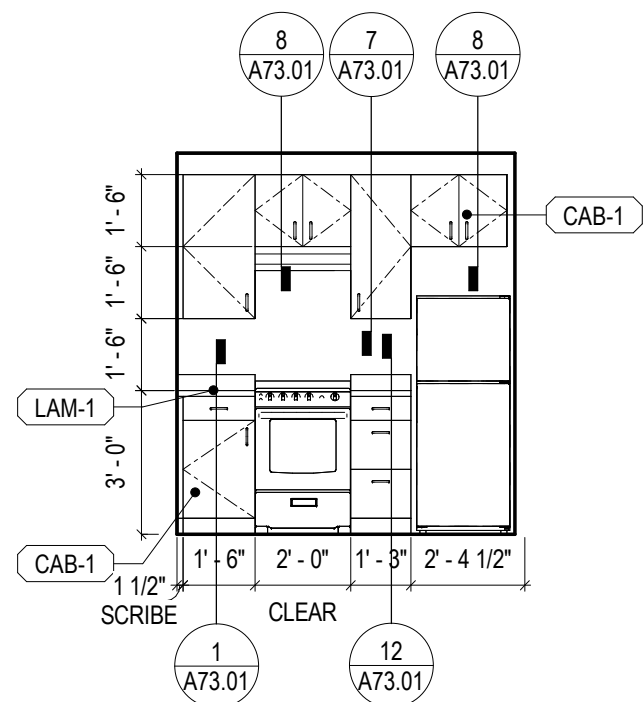


1 CORNER 1-BEDROOM UNIT
1/4" = 1'-0"

	THERMOSTAT • MOUNTED 48" AFF FROM CENTERLINE, TYP UNO.		18" TOWEL BAR • MOUNT 3'-10" AFF FROM CENTERLINE AND 1'-2" AWAY FROM EDGE OF SHOWER ENCLOSURE WALL FROM CENTERLINE, TYP UNO.		ROBE HOOK • MOUNT 3'-10" AFF FROM CENTERLINE AND 7" AWAY FROM WALL WALL EDGE FROM CENTERLINE, TYP UNO.
	DECORATIVE MIRROR/MEDICINE CABINET • MOUNT 3'-4" AFF FROM BOTTOM OF REFLECTIVE SURFACE, TYP UNO. • DECORATIVE WOOD-FRAMED MIRRORS TO MATCH CABINETS, TYP UNO.		HAND TOWEL RING • MOUNT 3'-8" AFF FROM CENTERLINE AND 11" AWAY FROM EDGE OF VANITY, TYP UNO.		TOILET PAPER HOLDER • MOUNT 1'-8" AFF FROM CENTERLINE AND 2'-8" AWAY FROM FACE OF TOILET WALL FROM CENTERLINE, TYP UNO.
	ELECTRICAL PANEL - • MOUNT 2'-0" AFF FROM BOTTOM OF PANEL, TYP UNO.		RECESSED MEDICINE CABINET - • MOUNT 4'-6" AFF FROM CENTERLINE AND 11" AWAY FROM EDGE OF VANITY, TYP UNO. • INSTALL WITH HINGE SIDE ON INSIDE CORNER OF THE WALL.		

ROOM		DOOR INFORMATION							FRAME INFORMATION			FIRE RATING	HARDWARE GROUP	COMMENTS
#	NAME	TYPE	MATERIAL	FINISH	GLAZING	HEIGHT	WIDTH	THICKNESS	FRAME TYPE	MATERIAL	FINISH			
119B	CORNER 1-BDRM	C	WD	P-2	N/A	6'-8"	5'-10"	1 3/8"	01	WD	P-2	U-4.0		
119C	CORNER 1-BDRM	A	WD	P-2	N/A	6'-8"	3'-0"	1 3/8"	01	WD	P-2	U-2.0		
119D	CORNER 1-BDRM	A	WD	P-2	N/A	6'-8"	3'-0"	1 3/8"	01	WD	P-2	U-2.0		
119E	CORNER 1-BDRM	B	WD	P-2	N/A	6'-8"	5'-0"	1 3/8"	01	WD	P-2	U-5.0		

SEE SHEET A00.02 GENERAL NOTES FOR DIMENSIONING, GRAPHICS, ABBREVIATIONS, AND OTHER STANDARDS.
SEE SHEET A23.01 AND A23.02 FOR FINISH TRANSITION LOCATIONS.
SEE SHEET A26.01 FOR UNIT FIXTURE AND EQUIPMENT SCHEDULE.
DIMENSIONS ARE TO ROUGH FRAMING OR TO FACE OF EXISTING FINISHES, TYP UNO.
DIMENSIONS INDICATED AS "MIN" OR "CLR" ARE FROM NEAREST FINISH SURFACE, INCLUDING TRIM.
RADIUSED CORNERS ARE LOCATED 12" FROM NEAREST INTERSECTING WALL FRAMING OR CENTERED BETWEEN NEAREST
ADJACENT INTERSECTING WALLS, TYP UNO.
PROVIDE BLOCKING FOR GRAB BAR INSTALLATION. REFER TO SHEET A4.01 FOR GRAB BAR LOCATIONS.
FLOOR FINISH TO CONTINUE UNDER ANY REMOVABLE CABINETS. REFER TO UNIT ELEVATIONS FOR REMOVABLE CABINET LOCATIONS.
FLOOR FINISH TO BE PROVIDED UNDER ALL REMOVABLE CABINETS. REFER TO UNIT ELEVATIONS FOR REMOVABLE CABINET LOCATIONS.
FLOOR DRAINS TO BE PROVIDED IN BATHROOMS AND UNDER DISHWASHER. COORDINATE LOCATIONS WITH PLUMBING.

1. ARCHITECTURAL RCP PROVIDED FOR COORDINATION PURPOSES ONLY. REFER TO MEP DRAWINGS FOR DETAILED SCOPE OF SYSTEMS.
2. CEILING FIXTURES ARE CENTERED IN CEILING TILE OR CENTERED IN ROOM, UNO.
3. DIMENSIONS IN CEILING PLANS ARE TO FACE OF FINISH, UNO.
4. CRASHING REPRESENTATION OF LIGHTING FIXTURES MAY NOT BE NOTED TO SCALE.
5. CEILING GRID IS CENTERED IN ROOM, UNO.
6. ALL GWB CEILINGS & SOFFITS TO BE PAINTED P-2, UNO.
7. ALL EXPOSED MECHANICAL GRILLES, WALL DIFFUSERS, ELECTRICAL PANELS, ACCESS PANELS, ETC TO BE PAINTED TO MATCH ADJACENT WALL SURFACE.

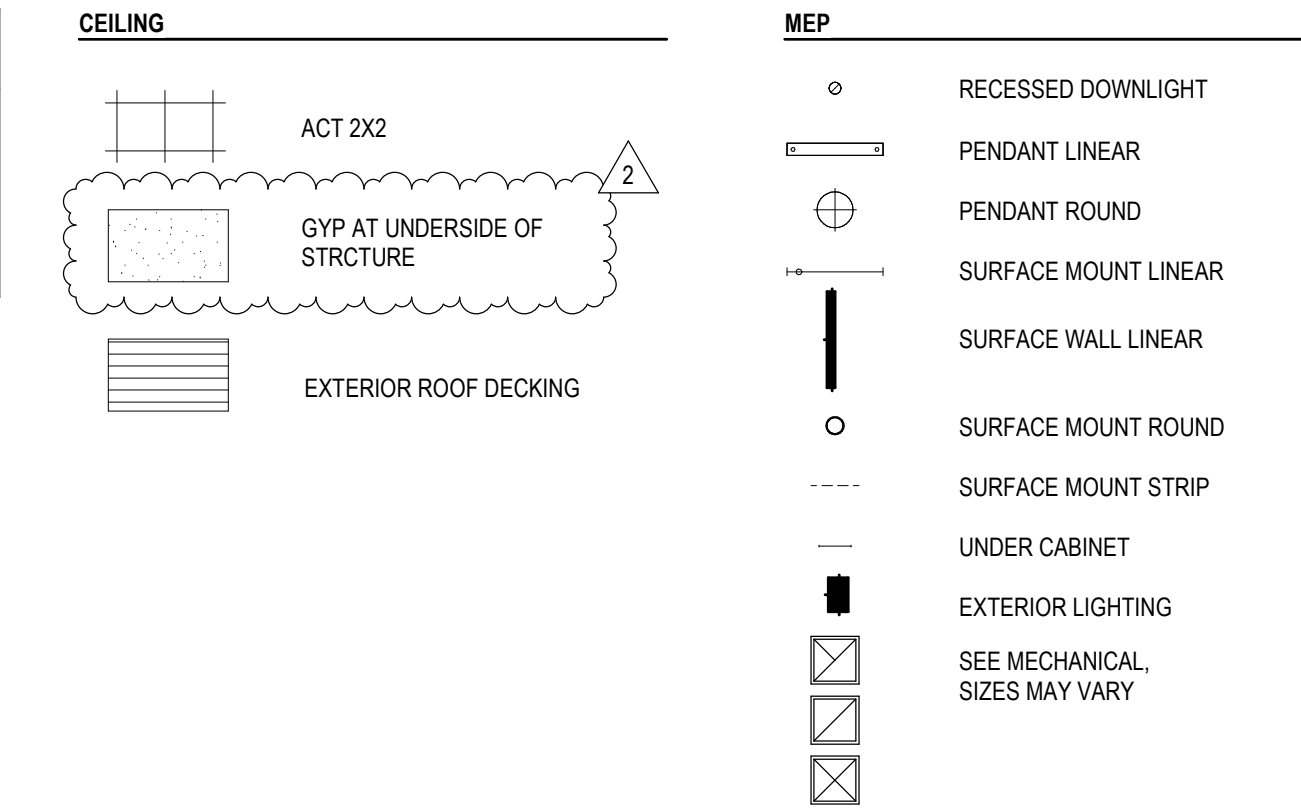

OPERABLE PARTS OF DOOR
HARDWARE SHALL COMPLY WITH
ANSI 117.1 SECTIONS 308 & 404.2.6,
AND SHALL BE 34" MIN AND 48"
MAX OFF.

2" SEE SCHED 2"

2" SEE SCHEDULE

FIN FLOOR

FRAME TYPES 01

DOOR TYPES

A
SINGLE FLUSH
DOOR


B
DOUBLE SLIDER
DOOR

C
BI-FOLD DOOR

Diagram illustrating three types of shelving units and their dimensions:

- R/S SINGLE SHELF W/ ROD:** Total height is 7'-0". Shelf height is 1'-0".
- (2) R/S DOUBLE SHELF W/ ROD:** Total height is 7'-6". Shelf heights are 3'-6" and 1'-0".
- 5S FIVE SHELVES:** Total height is 6'-4". Shelf heights are 1'-4", 1'-4", 1'-4", 1'-4", and 2'-0". The 2'-0" shelf is labeled "OMIT BOTTOM SHELF @ ACCESSIBLE UNITS".



Common dimension: PROVIDE BLOCKING 3'-0" OC AT ALL SHELF LOCATIONS, TYP

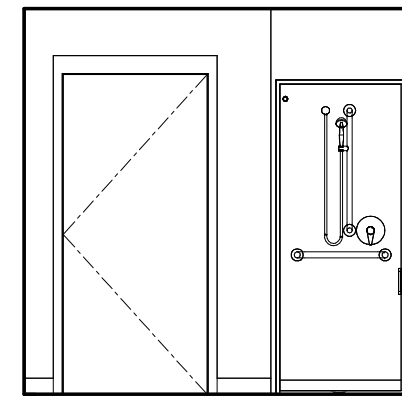

3 TYPE B 2-BED KITCHEN - NORTH
1/4" = 1'-0"

PLAN ELEVATION	THERMOSTAT • MOUNT 4'-0" AFF FROM CENTERLINE, TYP UNO.	PLAN ELEVATION	18" TOWEL BAR • MOUNT 3'-10" AFF FROM CENTERLINE AND 1'-2" AWAY FROM EDGE OF SHOWER ENCLOSURE WALL FROM CENTERLINE, TYP UNO.	PLAN ELEVATION	ROBE HOOK • MOUNT 3'-10" AFF FROM CENTERLINE AND 1" AWAY FROM WALL WALL EDGE FROM CENTERLINE, TYP UNO.
PLAN ELEVATION	DECORATIVE MIRROR/MEDICINE CABINET • MOUNT 3'-4" AFF FROM BOTTOM OF REFLECTIVE SURFACE, TYP UNO. • DECORATIVE WOOD-FRAMED MIRRORS TO MATCH CABINETS, TYP UNO.	PLAN ELEVATION	HAND TOWEL RING • MOUNT 3'-8" AFF FROM CENTERLINE AND 11" AWAY FROM EDGE OF VANITY, TYP UNO.	PLAN ELEVATION	TOILET PAPER HOLDER • MOUNT 1'-8" AFF FROM CENTERLINE AND 2'-8" AWAY FROM FACE OF TOILET WALL FROM CENTERLINE, TYP UNO.
PLAN ELEVATION	ELECTRICAL PANEL • MOUNT 2'-0" AFF FROM BOTTOM OF PANEL, TYP UNO.	PLAN ELEVATION	RECESSED MEDICINE CABINET • MOUNT 4'-6" AFF FROM CENTERLINE AND 11" AWAY FROM EDGE OF VANITY, TYP UNO. • INSTALL WITH HINGE SIDE ON INSIDE CORNER OF THE WALL.		



DOOR #	ROOM NAME	DOOR INFORMATION						FRAME INFORMATION				FIRE RATING	HARDWARE GROUP	COMMENTS
		TYPE	MATERIAL	FINISH	GLAZING	HEIGHT	WIDTH	THICKNESS	FRAME TYPE	MATERIAL	FINISH			
111B	TYPE A 2-BDRM	A	WD	P-2	N/A	6' - 8"	3' - 0"	1 3/8"	01	WD	P-2	U-3.0		
111C	TYPE A 2-BDRM	A	WD	P-2	N/A	6' - 8"	3' - 0"	1 3/8"	01	WD	P-2	U-2.0		
111D	TYPE A 2-BDRM	A	WD	P-2	N/A	6' - 8"	3' - 0"	1 3/8"	01	WD	P-2	U-2.0		
111E	TYPE A 2-BDRM	B	WD	P-2	N/A	6' - 8"	4' - 0"	1 3/8"	01	WD	P-2	U-5.0		
111F	TYPE A 2-BDRM	A	WD	P-2	N/A	6' - 8"	3' - 0"	1 3/8"	01	WD	P-2	U-2.0		
111G	TYPE A 2-BDRM	B	WD	P-2	N/A	6' - 8"	4' - 0"	1 3/8"	01	WD	P-2	U-5.0		

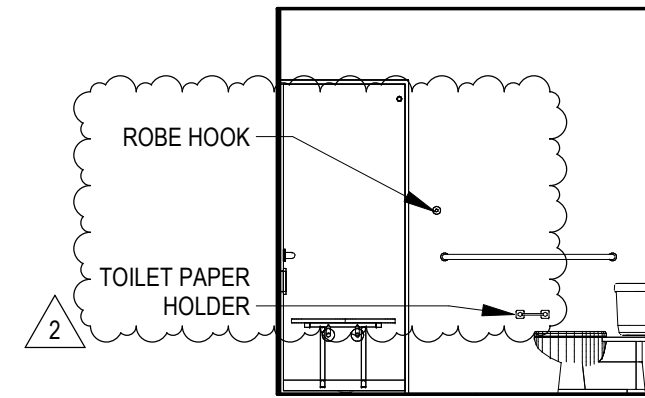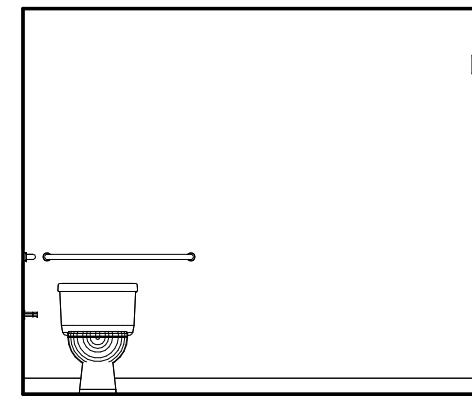

3 TYPE B 2-BED KITCHEN - NORTH
1/4" = 1'-0"


1. SEE SHEET A20.00 GENERAL NOTES FOR DIMENSIONING, GRAPHICS, ABBREVIATIONS, AND OTHER STANDARDS.
2. SEE SHEET A23.01 AND A23.02 FOR FINISH TRANSITION LOCATIONS.
3. SEE SHEET A26.00 FOR FLOOR FINISHES AND EQUIPMENT SCHEDULES.
4. DIMENSIONS ARE TO ROUGH FRAMING OR TO FACE OF EXISTING FINISHES, TYPE UNO.
5. DIMENSIONS INDICATED AS "MIN" OR "CLR" ARE FROM NEAREST FINISH SURFACE, INCLUDING TRIM.
6. POLYURETHANE SPRINGS ARE LOCATED 10" FROM NEAREST INTERSECTING WALL FRAMING OR CENTERED BETWEEN NEAREST ADJACENT INTERSECTING WALLS, TYPE UNO.
7. PROVIDE BLOCKING FOR GRAB BAR INSTALLATION, REFER TO SHEET A4.01 FOR GRAB BAR LOCATIONS.
8. FOR FINISH TO CONTINUE UNDER ANY REMOVABLE CABINETS, REFER TO ELEVATIONS FOR REMOVABLE CABINET LOCATIONS.
9. FOR FINISH TO BEHIND ANY REMOVABLE CABINETS, REFER TO ELEVATIONS FOR REMOVABLE CABINET LOCATIONS.
10. DRAIN PLAINS TO BE PROVIDED IN BATHROOMS AND UNDER DISHWASHER. COORDINATE LOCATIONS WITH PLUMBING.

1. ARCHITECTURAL RCP PROVIDED FOR COORDINATION PURPOSES ONLY. REFER TO MEP DRAWINGS FOR DETAILED SCOPE OF SYSTEMS.
2. CEILING FIXTURES ARE CENTERED IN CEILING TILE OR CENTERED IN ROOM, UNO.
3. DIMENSIONS IN CEILING PLANS ARE TO FACE OF FINISH, UNO.
4. SPRINKLER REPRESENTATION OF LIGHTING FIXES MAY BE NOT TO SCALE.
5. CEILING GRID IS CENTERED IN ROOM, UNO.
6. ALL GWB CEILINGS & SOFFITS TO BE PAINTED P-2, UNO.
7. ALL EXPOSED MECHANICAL GRILLES, WALL DIFFUSERS, ELECTRICAL PANELS, ACCESS PANELS, ETC TO BE PAINTED TO MATCH ADJACENT WALL SURFACE.



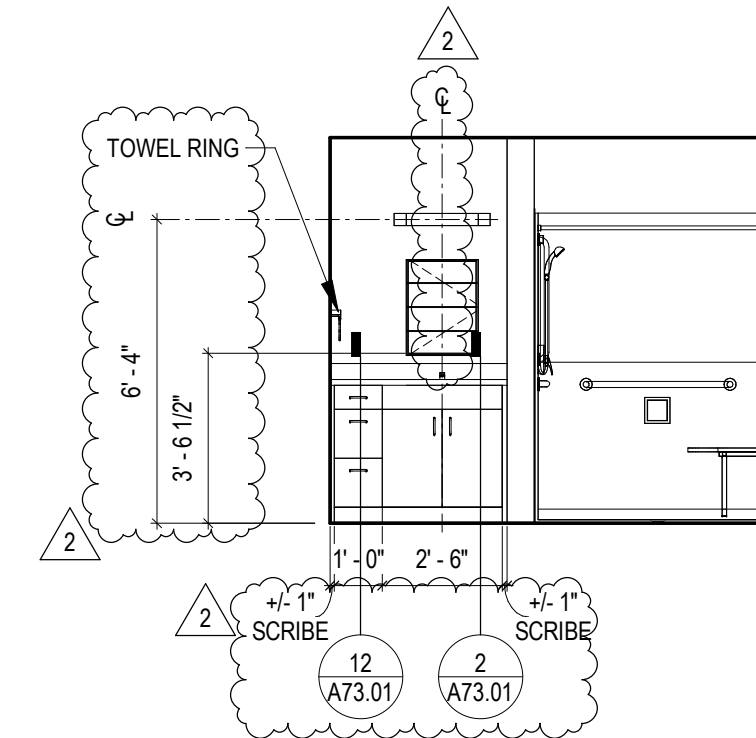
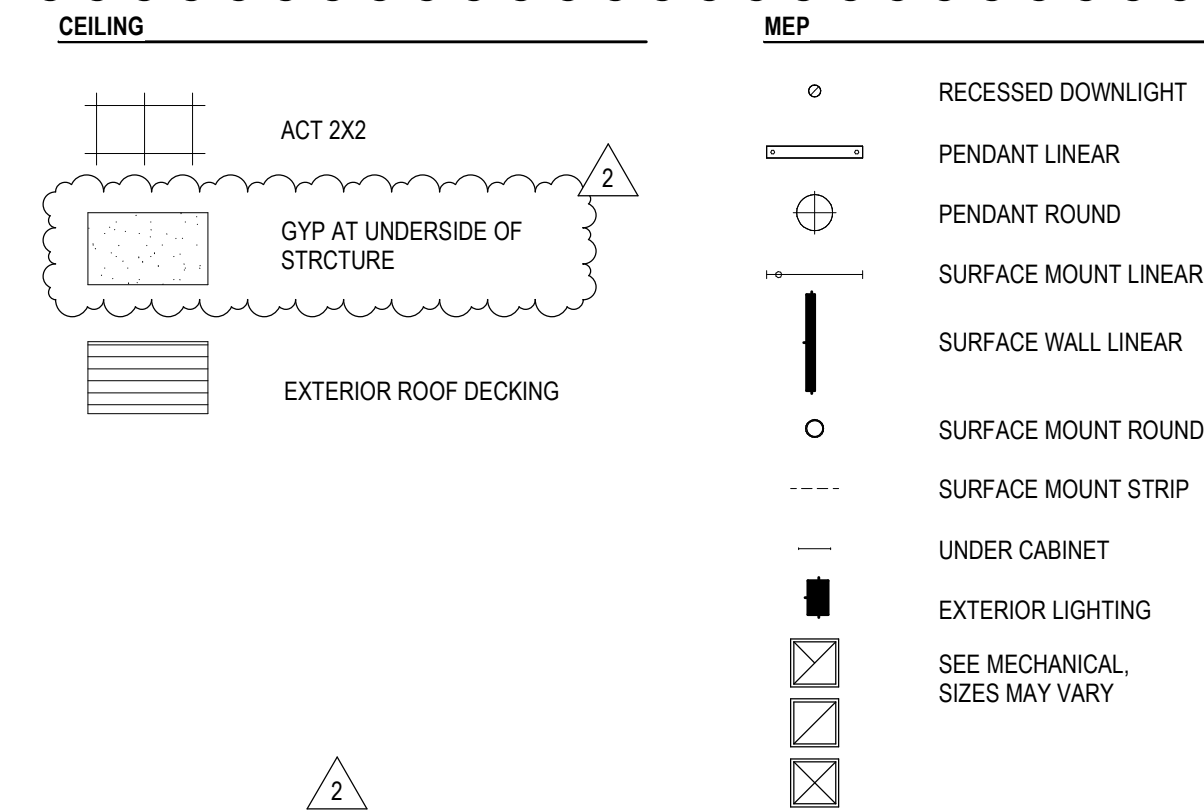


1 TYPE B 2-BEDROOM UNIT
1/4" = 1'-0"

UNIT - DOOR & FRAME TYPES

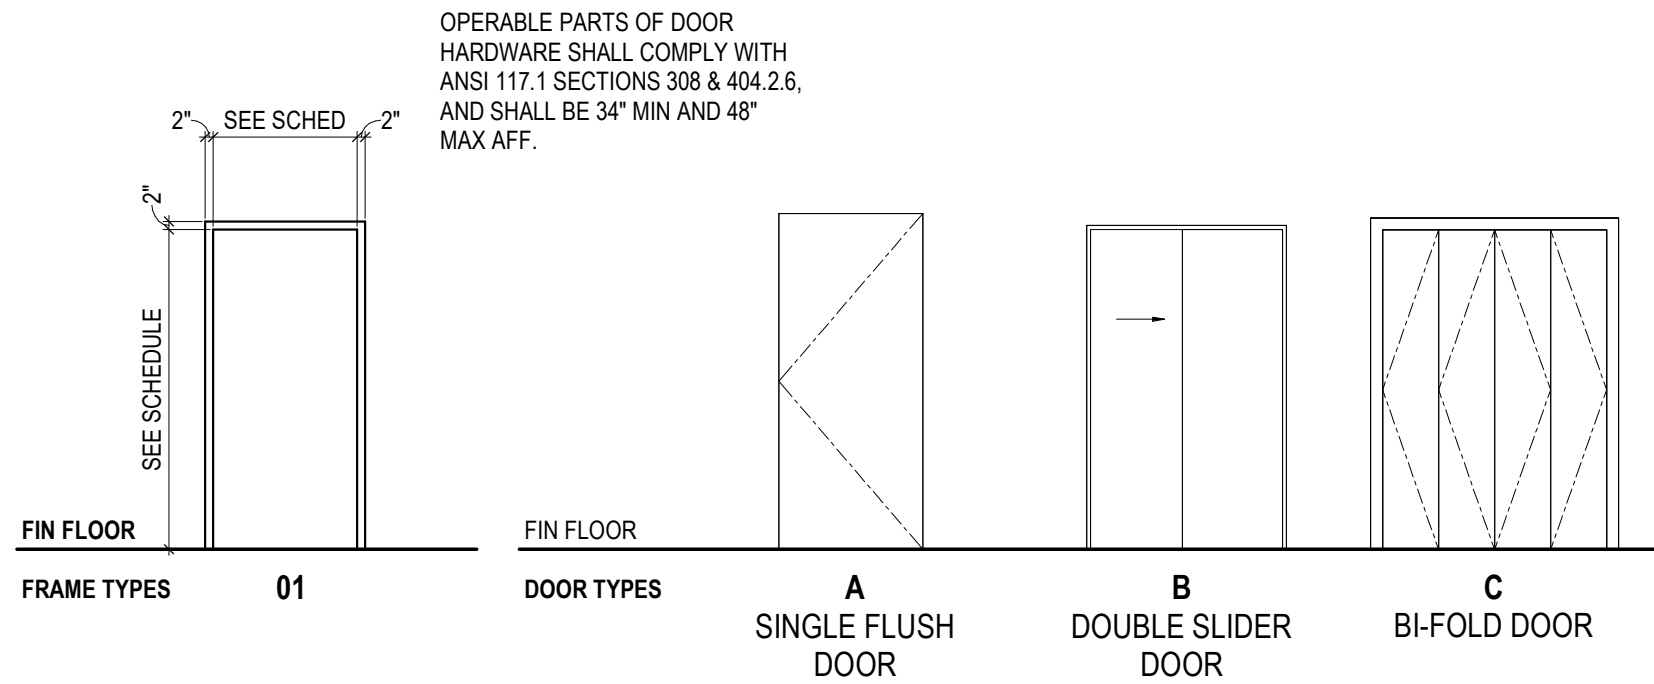

UNIT - TYPICAL SHELVING TYPES & MOUNTING HEIGHTS

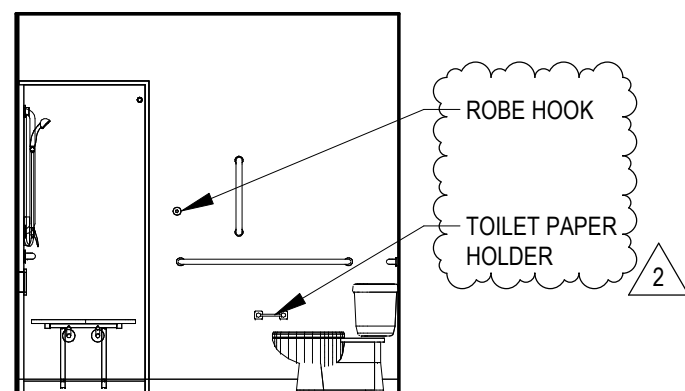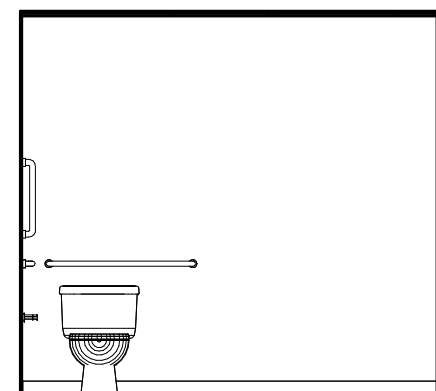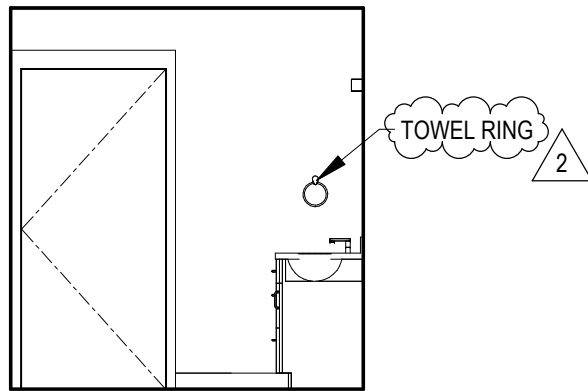
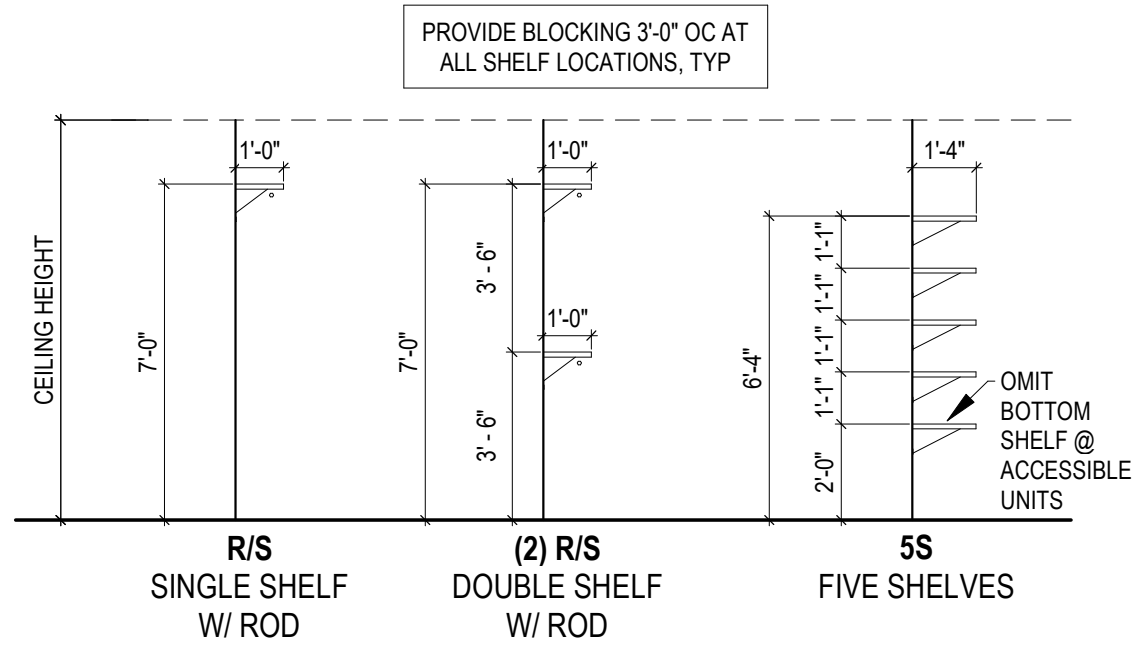


NOTES & LEGEND - UNIT PLANS

- SEE SHEET A00.02 GENERAL NOTES FOR DIMENSIONING, GRAPHICS, ABBREVIATIONS, AND OTHER STANDARDS.
- SEE SHEET A23.01 AND A23.02 FOR FINISH TRANSITION LOCATIONS.
- SEE SHEET A26.00 FOR UNIT FIXTURE AND EQUIPMENT SCHEDULE.
- DIMENSIONS ARE TO ROUGH FRAMING OR TO FACE OF EXISTING FINISHES, TYP UNO.
- DIMENSIONS INDICATED AS "MIN" OR "CLR" ARE FROM NEAREST FINISH SURFACE, INCLUDING TRIM.
- ROUGH DOOR OPENINGS ARE LOCATED 6" FROM NEAREST INTERSECTING WALL FRAMING OR CENTERED BETWEEN NEAREST ADJACENT INTERSECTING WALLS, TYP UNO.
- PROVIDE BLOCKING FOR GRAB BAR INSTALLATION. REFER TO SHEET A4.01 FOR GRAB BAR LOCATIONS.
- FLOOR FINISH TO CONTINUE UNDER ANY REMOVABLE CABINETS. REFER TO UNIT ELEVATIONS FOR REMOVABLE CABINET LOCATIONS.
- WALLS TO BE FINISHED BEHIND ANY REMOVABLE CABINETS. REFER TO UNIT ELEVATIONS FOR REMOVABLE CABINET LOCATIONS.
- FLOOR DRAINS TO BE PROVIDED IN BATHROOMS AND UNDER DISHWASHER. COORDINATE LOCATIONS WITH PLUMBING.

NOTES & LEGEND - REFLECTED CEILING PLAN

- ARCHITECTURAL RCP PROVIDED FOR COORDINATION PURPOSES ONLY. REFER TO MEP DRAWINGS FOR DETAILED SCOPE OF SYSTEMS.
- CEILING FIXTURES ARE CENTERED IN CEILING TILE OR CENTERED IN ROOM, UNO.
- DIMENSIONS IN CEILING PLANS ARE TO FACE OF FINISH, UNO.
- GRAPHIC REPRESENTATION OF LIGHTING FIXTURES MAY BE NOT TO SCALE.
- CEILING GRID IS CENTERED IN ROOM, UNO.
- ALL GYM CEILINGS & SOFFITS TO BE PAINTED P-2, UNO.
- ALL EXPOSED MECHANICAL GRILLES, WALL DIFFUSERS, ELECTRICAL PANELS, ACCESS PANELS, ETC TO BE PAINTED TO MATCH ADJACENT WALL SURFACE.



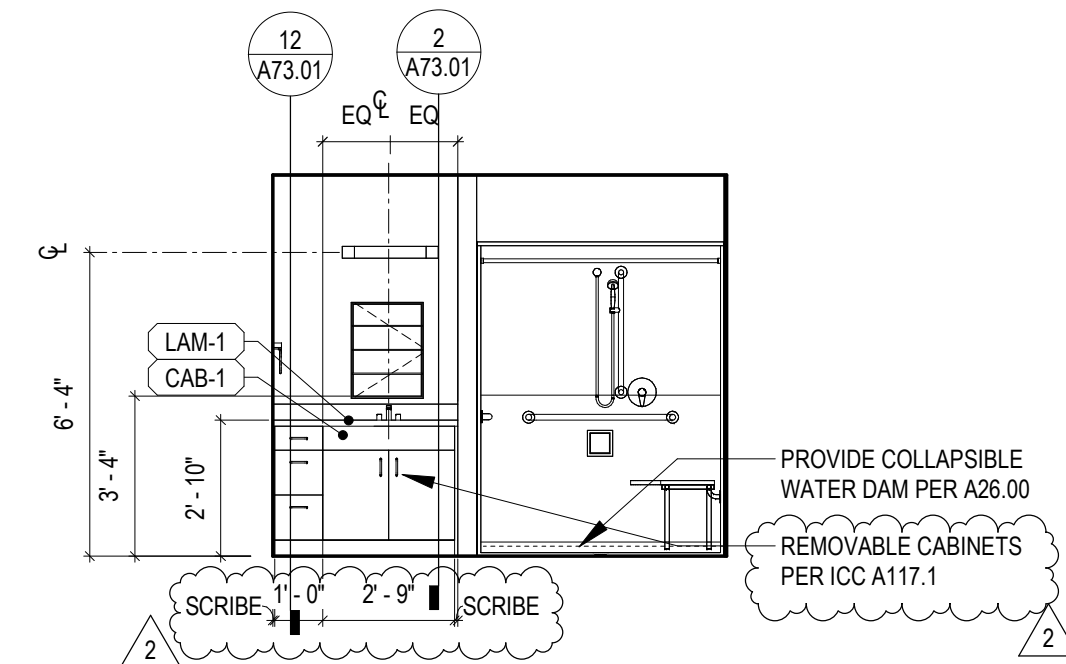
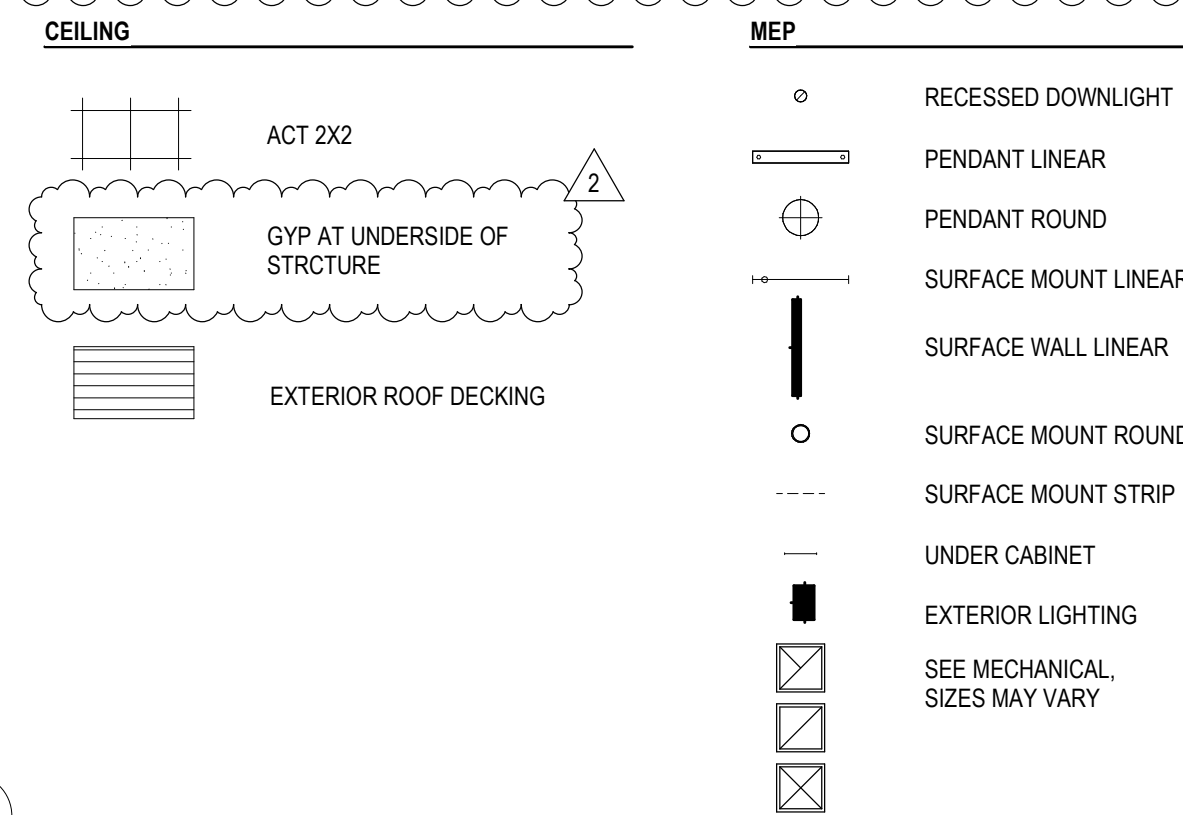


8 TYPE A 2-BED BATHROOM - WEST
1/4" = 1'-0"

7 TYPE A 2-BED BATHROOM - SOUTH
1/4" = 1'-0"

6 TYPE A 2-BED BATHROOM - EAST
1/4" = 1'-0"

5 TYPE A 2-BED BATHROOM - NORTH
1/4" = 1'-0"

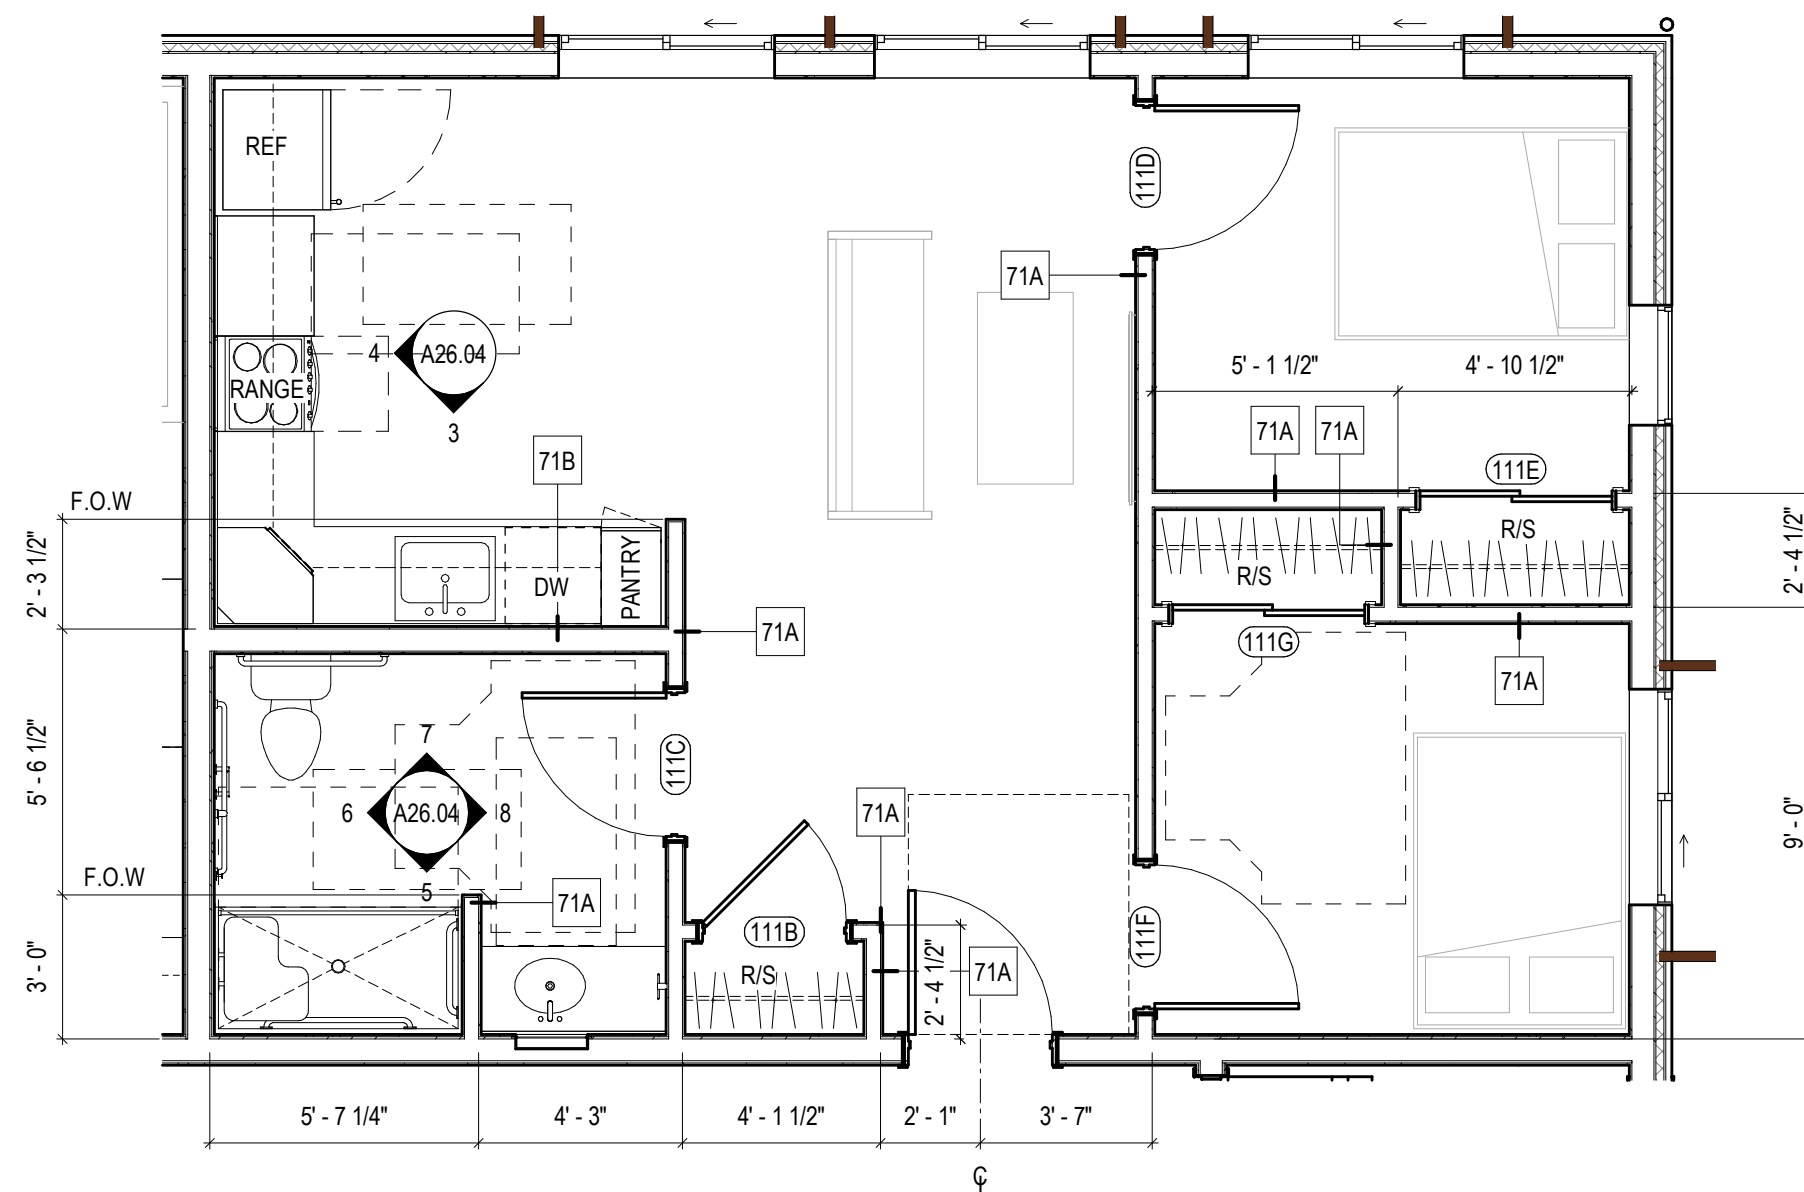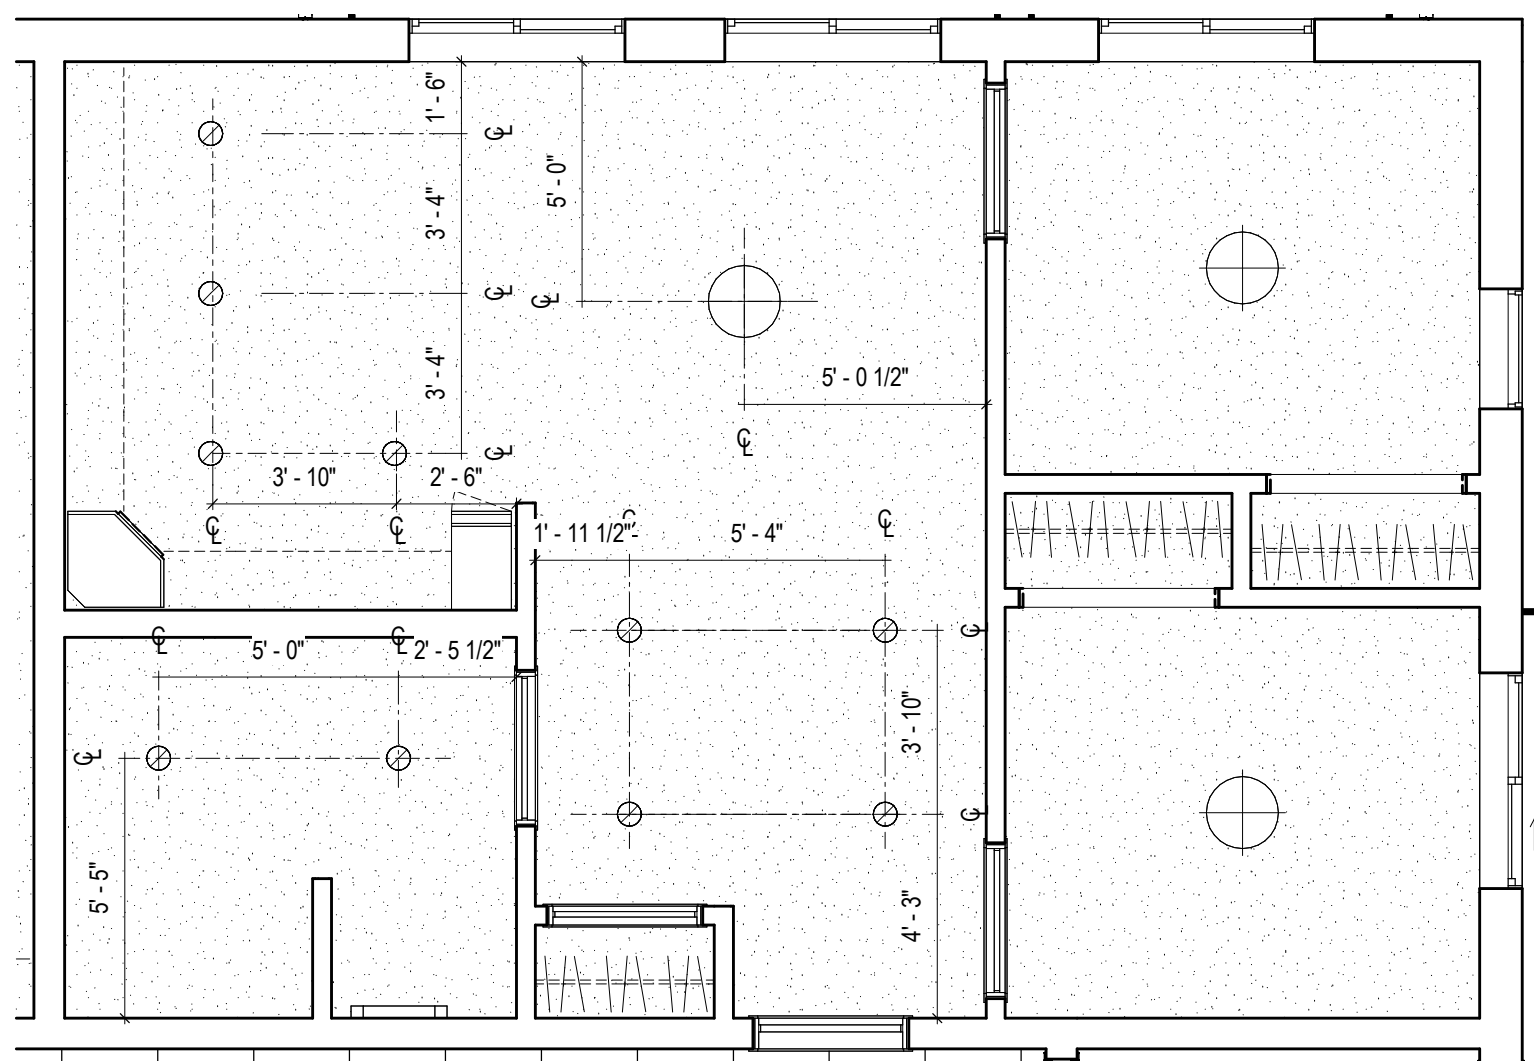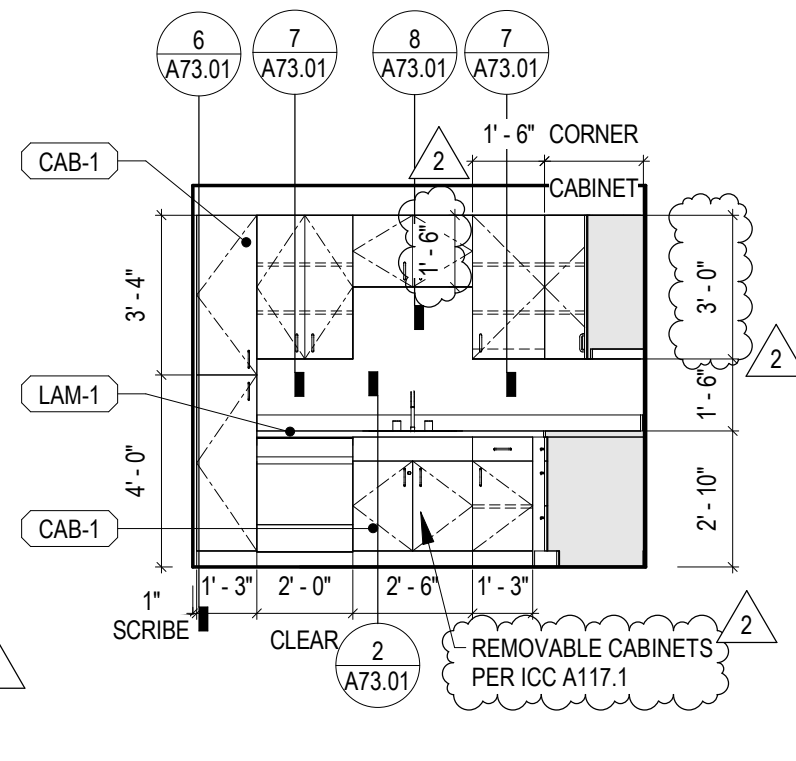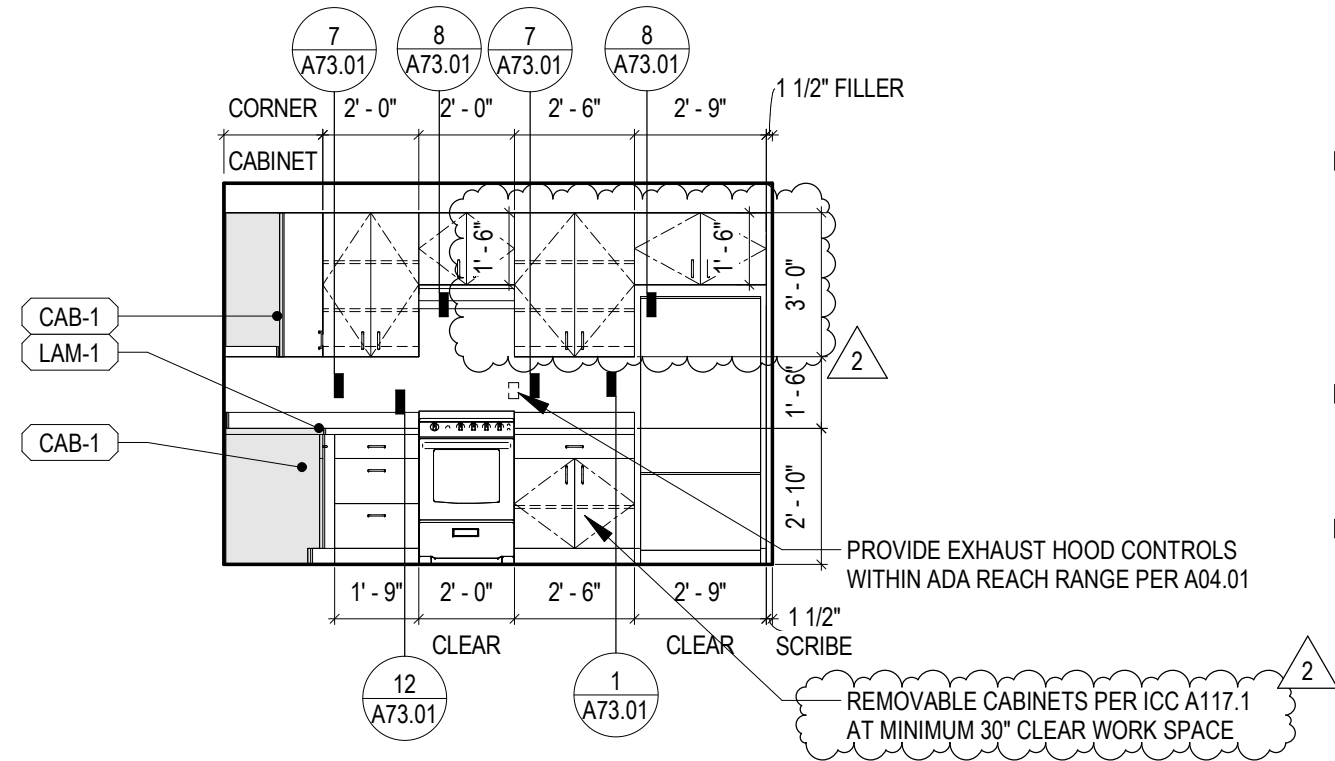


4 TYPE A 2-BED KITCHEN - EAST
1/4" = 1'-0"

3 TYPE A 2-BED KITCHEN - NORTH
1/4" = 1'-0"



2 TYPE A 2-BEDROOM RCP
1/4" = 1'-0"

1 TYPE A 2-BEDROOM UNIT
1/4" = 1'-0"


UNIT - DOOR & FRAME TYPES

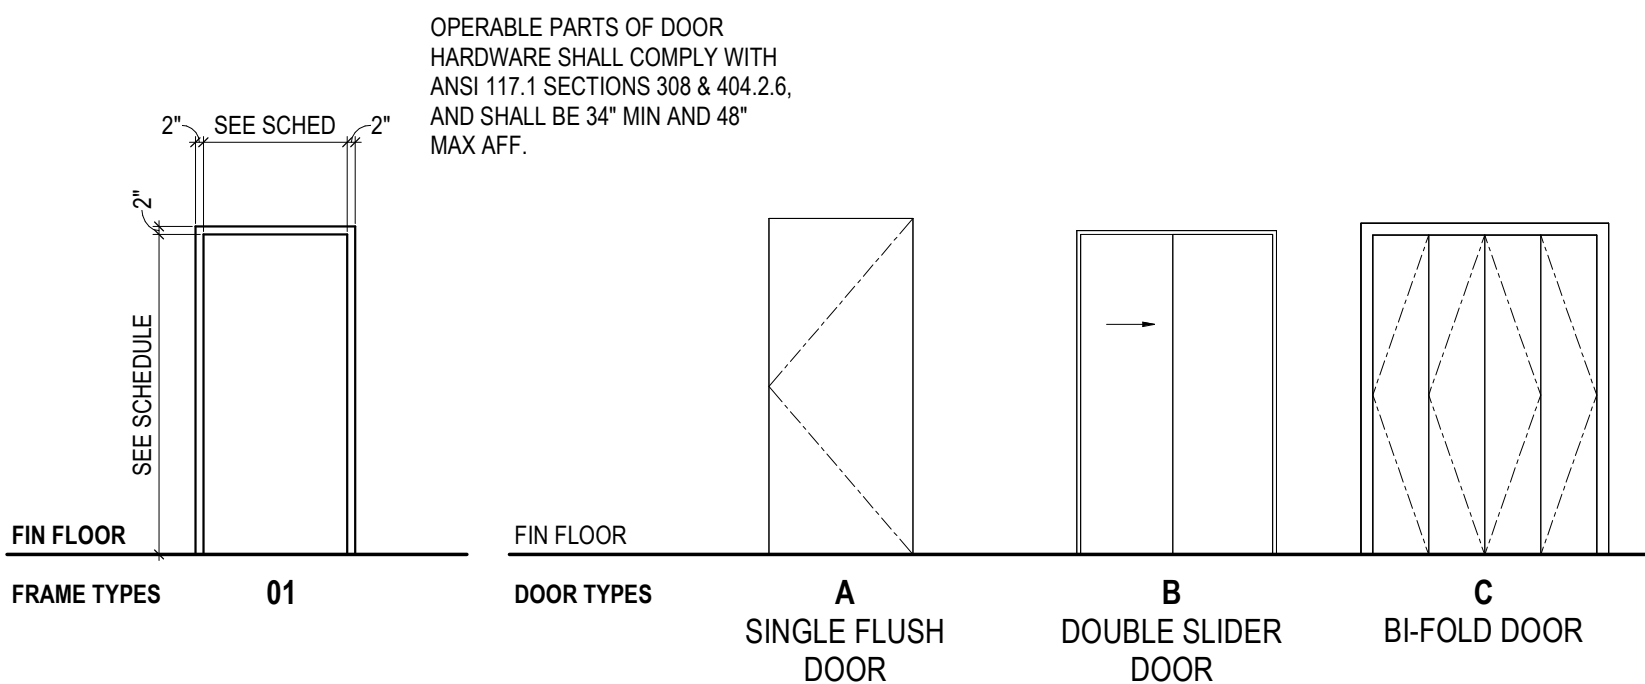

UNIT - TYPICAL SHELVING TYPES & MOUNTING HEIGHTS

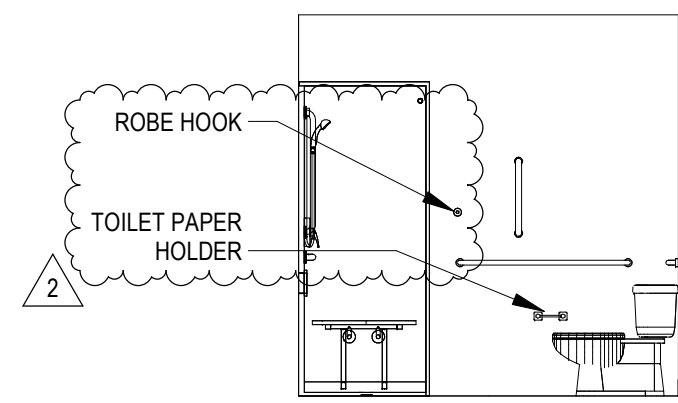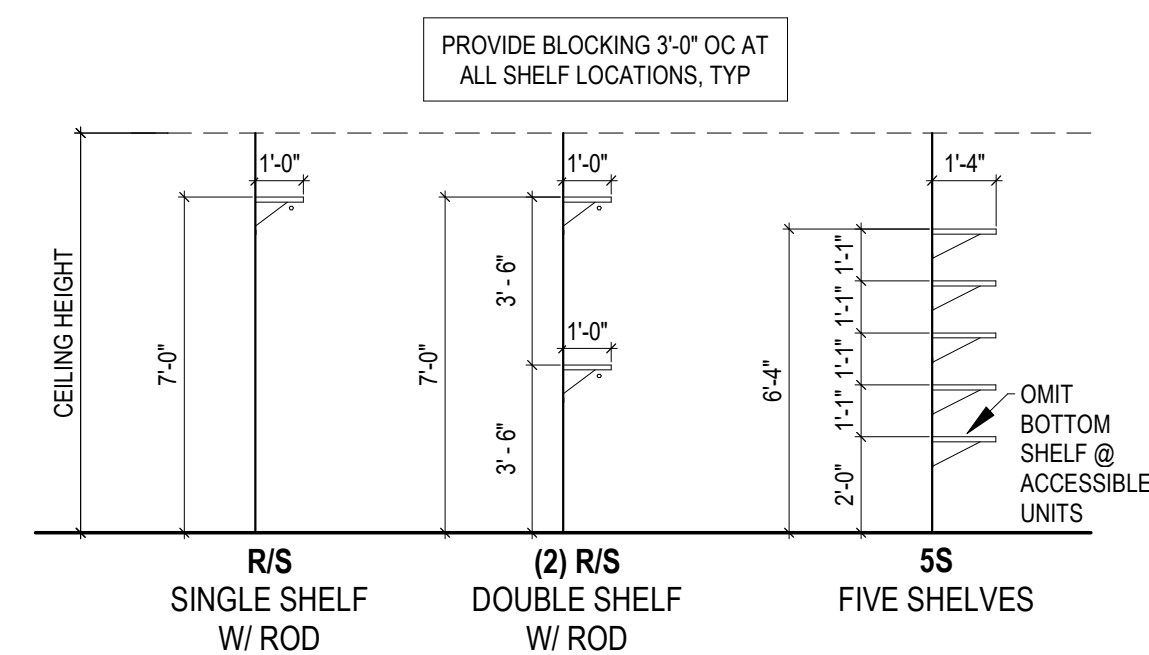


8 TYPE A 1-BED BATHROOM - WEST
1/4" = 1'-0"

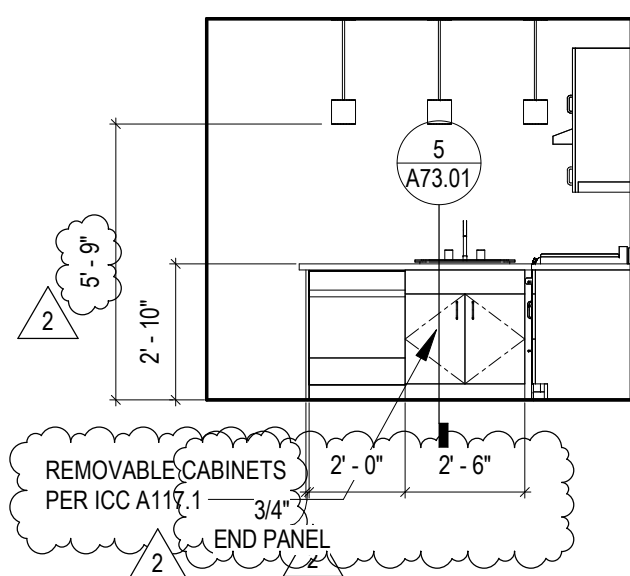


4 TYPE A 1-BED KITCHEN - NORTH
1/4" = 1'-0"

UNIT - SYMBOLS LEGEND & MOUNTING HEIGHTS

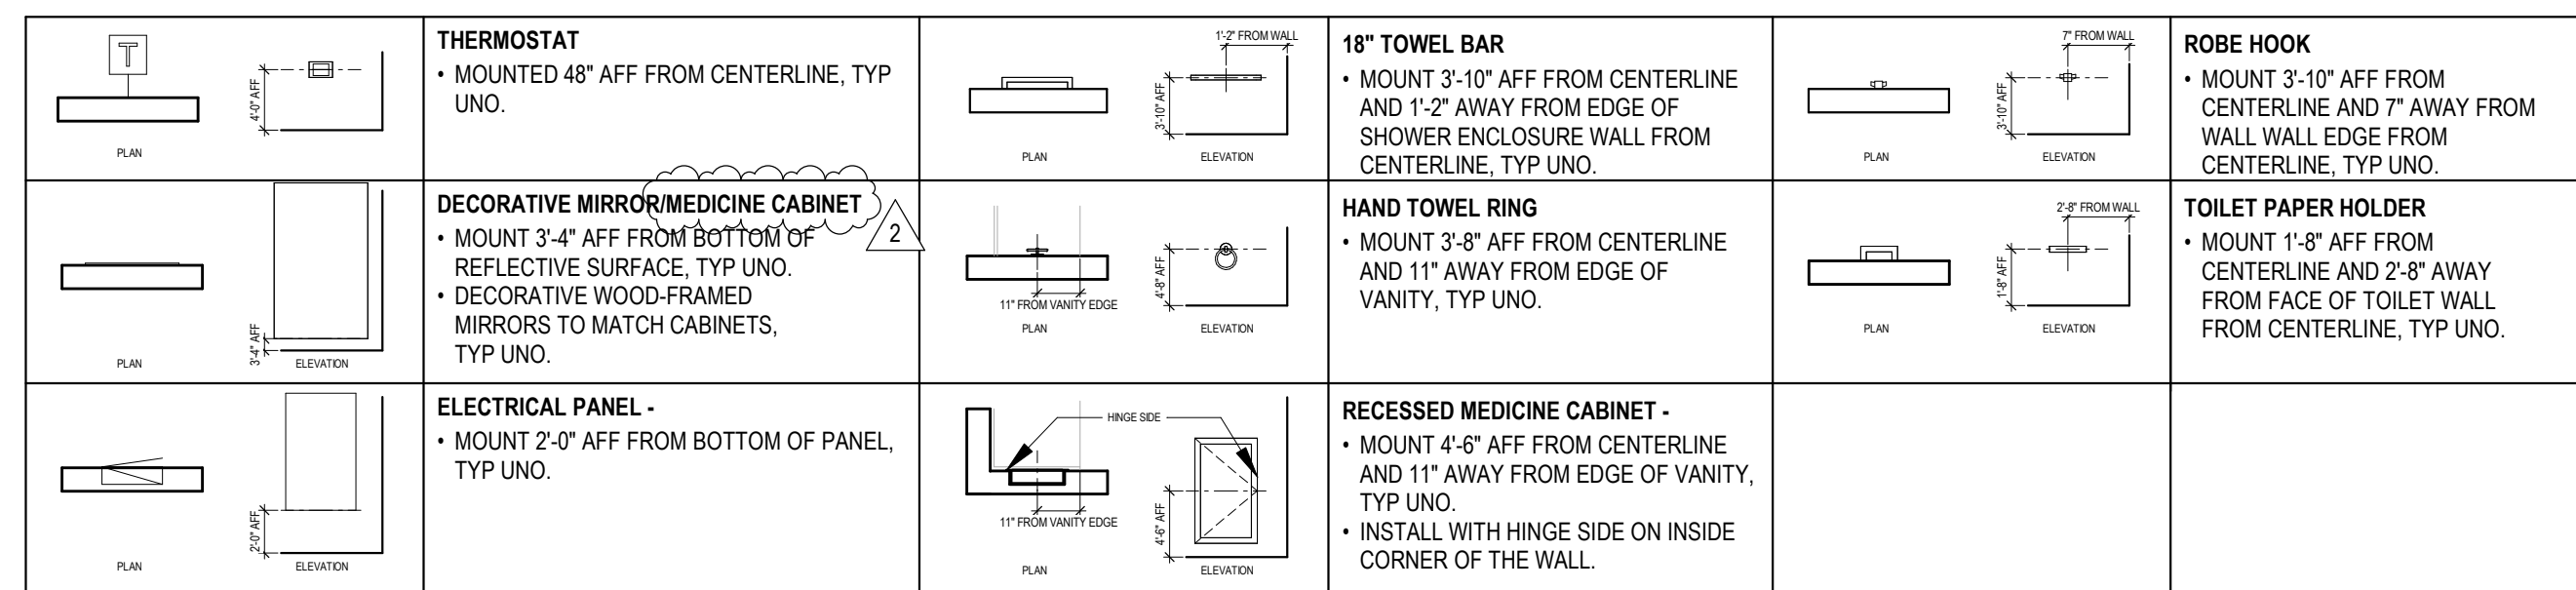


DOOR SCHEDULE - ACCESSIBLE 1-BDRM													
DOOR #	ROOM NAME	DOOR INFORMATION						FRAME INFORMATION			FIRE RATING	HARDWARE GROUP	COMMENTS
		TYPE	MATERIAL	FINISH	GLAZING	HEIGHT	WIDTH	THICKNESS	FRAME TYPE	MATERIAL			
106B	TYPE A 1-BDRM	A	WD	P-2	N/A	6'-8"	2'-0"	1 3/8"	01	WD	P-2	U-3.0	
106D	TYPE A 1-BDRM	A	WD	P-2	N/A	6'-8"	2'-0"	1 3/8"	01	WD	P-2	U-3.0	
106E	TYPE A 1-BDRM	A	WD	P-2	N/A	6'-8"	3'-0"	1 3/8"	01	WD	P-2	U-2.0	
106F	TYPE A 1-BDRM	B	WD	P-2	N/A	6'-8"	5'-0"	1 3/8"	01	WD	P-2	U-5.0	
160C	TYPE A 1-BDRM	A	WD	P-2	N/A	6'-8"	3'-0"	1 3/8"	01	WD	P-2	U-2.0	


THE LEVEL 2 VERSION OF THIS UNIT IS A TYPE B UNIT. KITCHEN CASEWORK TO BE 36" H WITH NO REMOVABLE CABINETS. BATHROOM CASEWORK TO REMAIN THE SAME ON BOTH FLOORS.

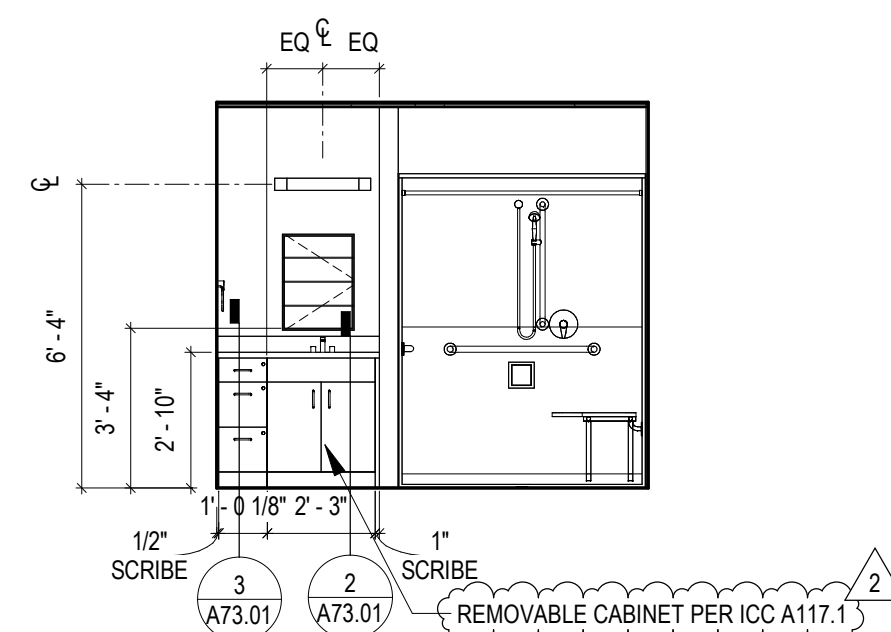


7 TYPE A 1-BED BATHROOM - SOUTH
1/4" = 1'-0"

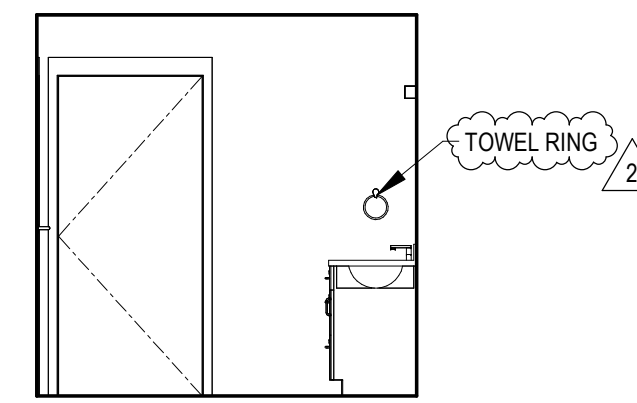


6 TYPE A 1-BED BATHROOM - EAST
1/4" = 1'-0"

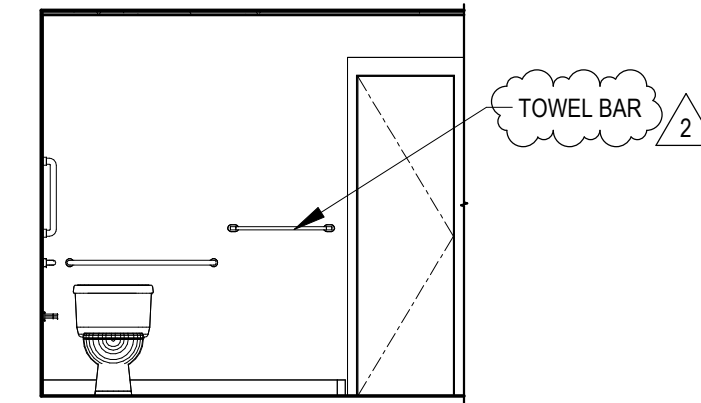


5 TYPE A 1-BED BATHROOM - NORTH
1/4" = 1'-0"

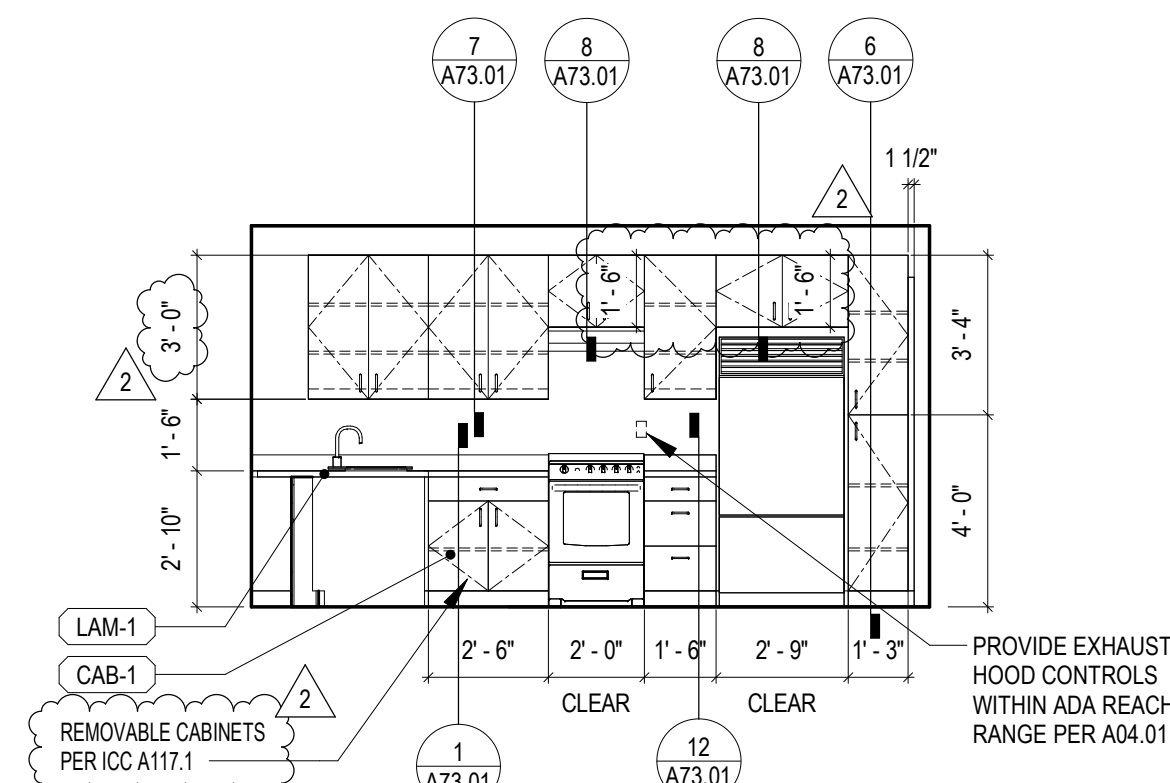

3 TYPE A 1-BED KITCHEN - EAST
1/4" = 1'-0"

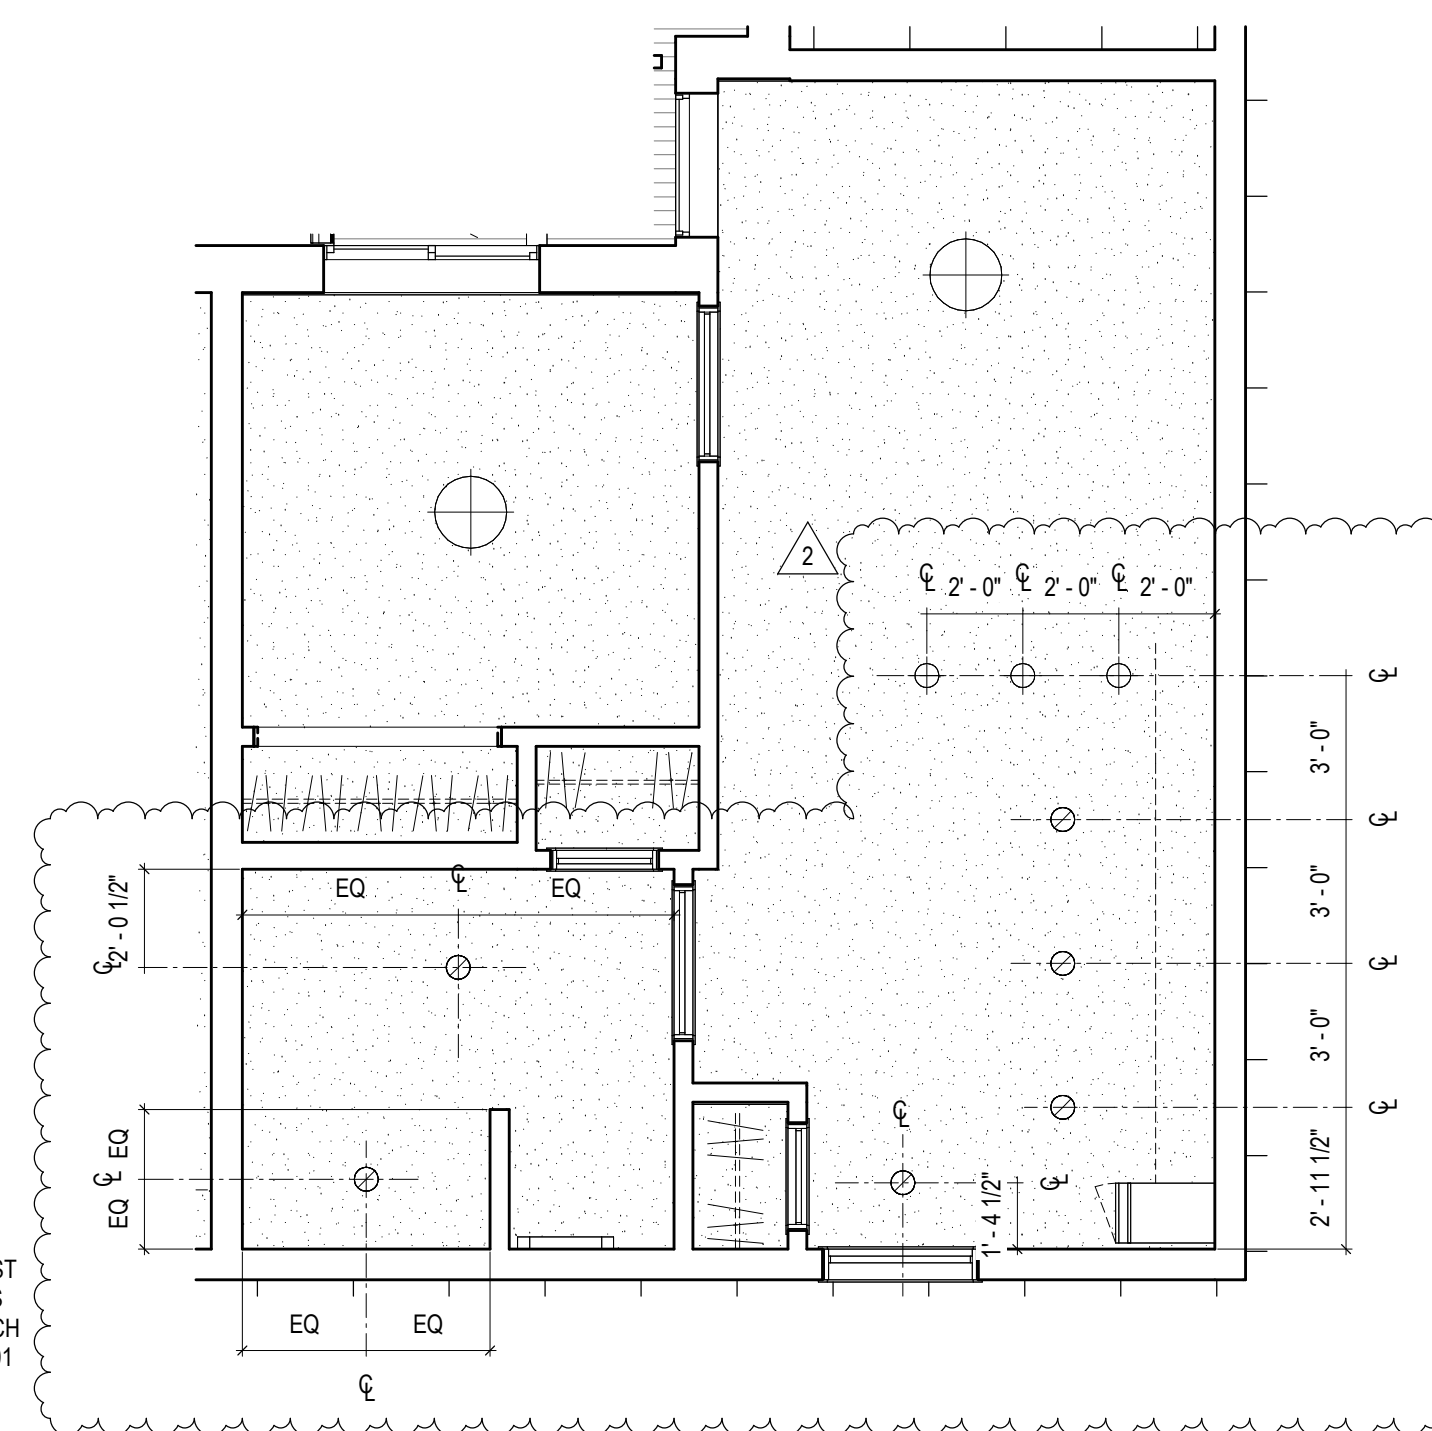

2 TYPE A 1-BEDROOM RCP
1/4" = 1'-0"

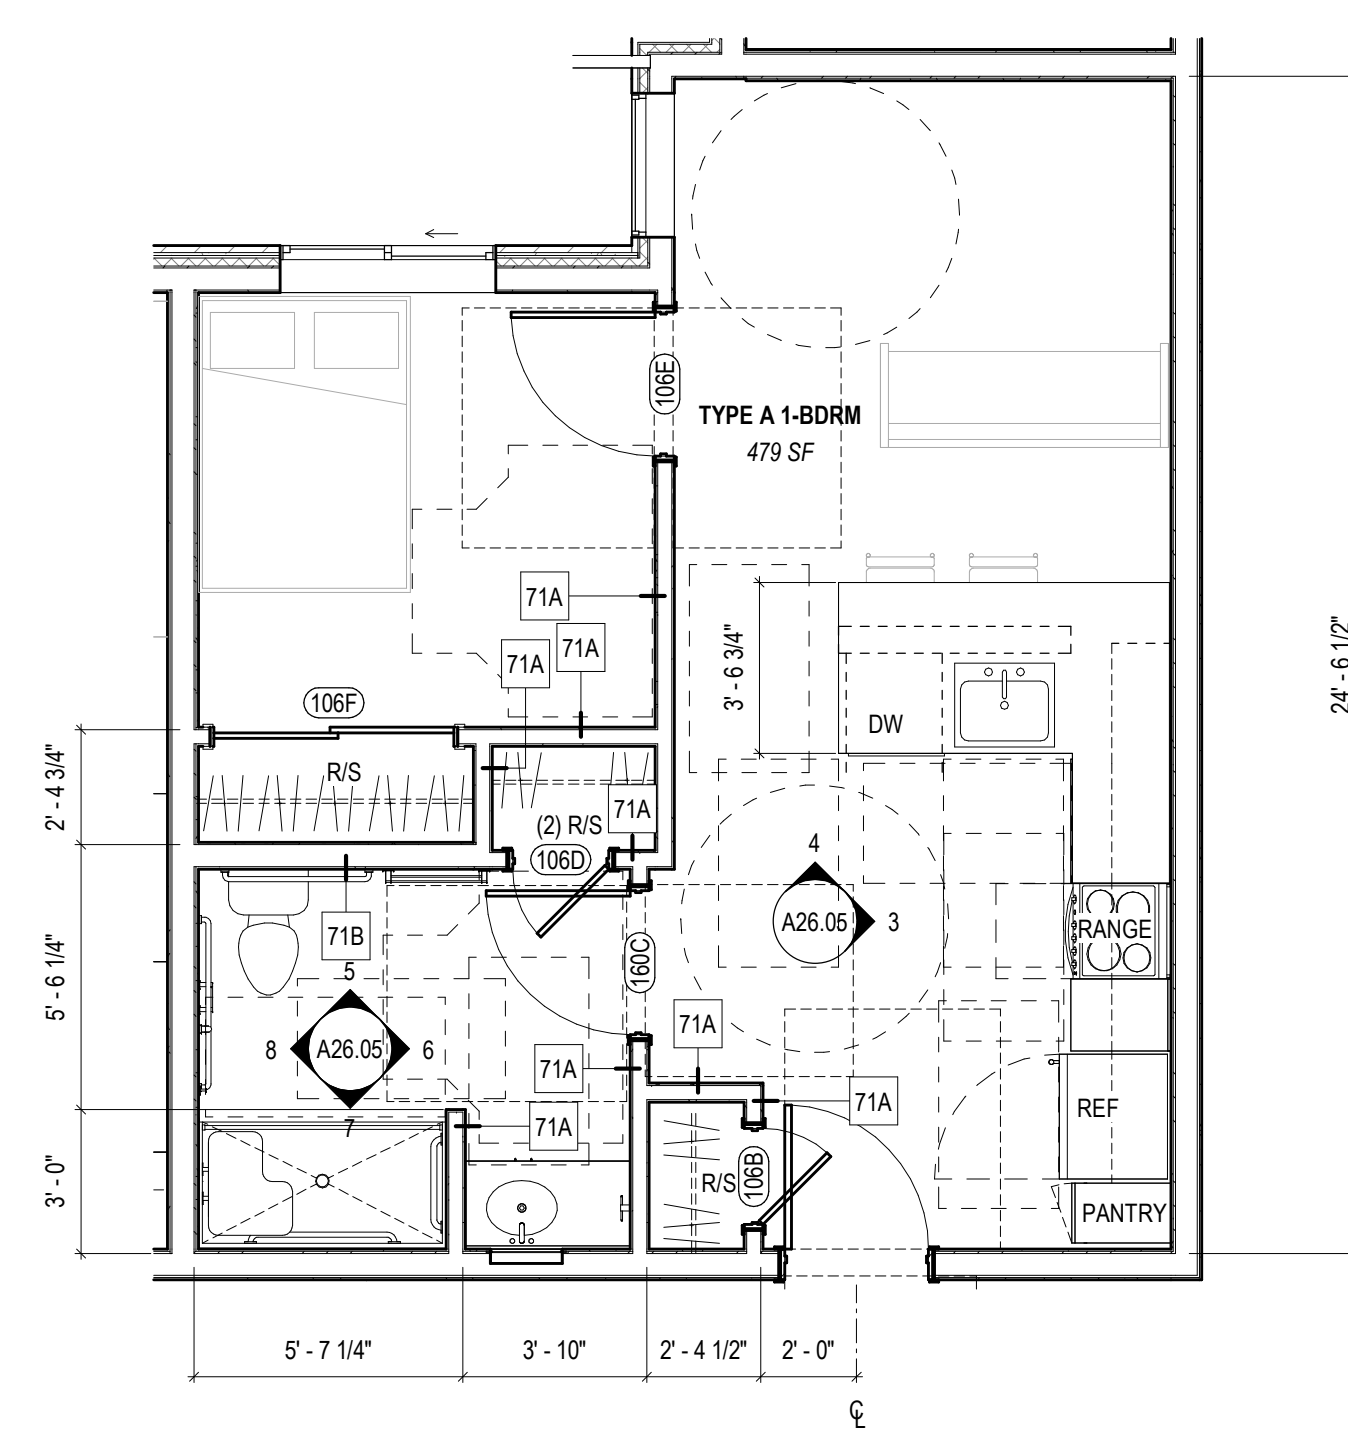


1 TYPE A 1-BEDROOM UNIT
1/4" = 1'-0"

NOTES & LEGEND - UNIT PLANS

1. SEE SHEET A20.00 GENERAL NOTES FOR DIMENSIONING, GRAPHICS, ABBREVIATIONS, AND OTHER STANDARDS.
2. SEE SHEET A23.01 AND A23.02 FOR FINISH TRANSITION LOCATIONS.
3. SEE SHEET A26.00 FOR UNIT FIXTURE AND EQUIPMENT SCHEDULE.
4. DIMENSIONS ARE TO ROUGH FRAMING OR TO FACE OF EXISTING FINISHES, TYP. UNO.
5. DIMENSIONS INDICATED AS "MIN" OR "CLR" ARE FROM NEAREST FINISH SURFACE, INCLUDING TRIM.
6. DOUGHNUT HOLE OPENINGS ARE LOCATED ON NEAREST INTERSECTING WALL FRAMING OR CENTERED BETWEEN NEAREST ADJACENT INTERSECTING WALLS, TYP. UNO.
7. PROVIDE BLOCKING FOR GRAB BAR INSTALLATION. REFER TO SHEET A4.01 FOR GRAB BAR LOCATIONS.
8. FLOOR FINISH TO CONTINUE UNDER ANY REMOVABLE CABINETS. REFER TO UNIT ELEVATIONS FOR REMOVABLE CABINET LOCATIONS.
9. FLOOR FINISH TO BE FINISHED REAR OF UNIT. PROVIDE FINISH TO BE REMOVABLE CABINET LOCATIONS.
10. FLOOR DRAINS TO BE PROVIDED IN BATHROOMS AND UNDER DISHWASHER. COORDINATE LOCATIONS WITH PLUMBING.

NOTES & LEGEND - REFLECTED CEILING PLAN


1. ARCHITECTURAL RCP PROVIDED FOR COORDINATION PURPOSES ONLY. REFER TO MEP DRAWINGS FOR DETAILED SCOPE OF SYSTEMS.
2. CEILING FIXTURES ARE CENTERED IN CEILING TIE OR CENTERED IN ROOM, UNO.
3. DIMENSIONS IN CEILING PLANS ARE TO FACE OF FINISH, UNO.
4. GRAPHIC REPRESENTATION OF JOISTING TYPES MAY BE NOT TO SCALE.
5. CEILING GRID IS CENTERED IN ROOM, UNO.
6. ALL GYM CEILINGS & SOFFITS TO BE PAINTED P-2, UNO.
7. ALL EXPOSED MECHANICAL GRILLES, WALL DIFFUSERS, ELECTRICAL PANELS, ACCESS PANELS, ETC TO BE PAINTED TO MATCH ADJACENT WALL SURFACE.

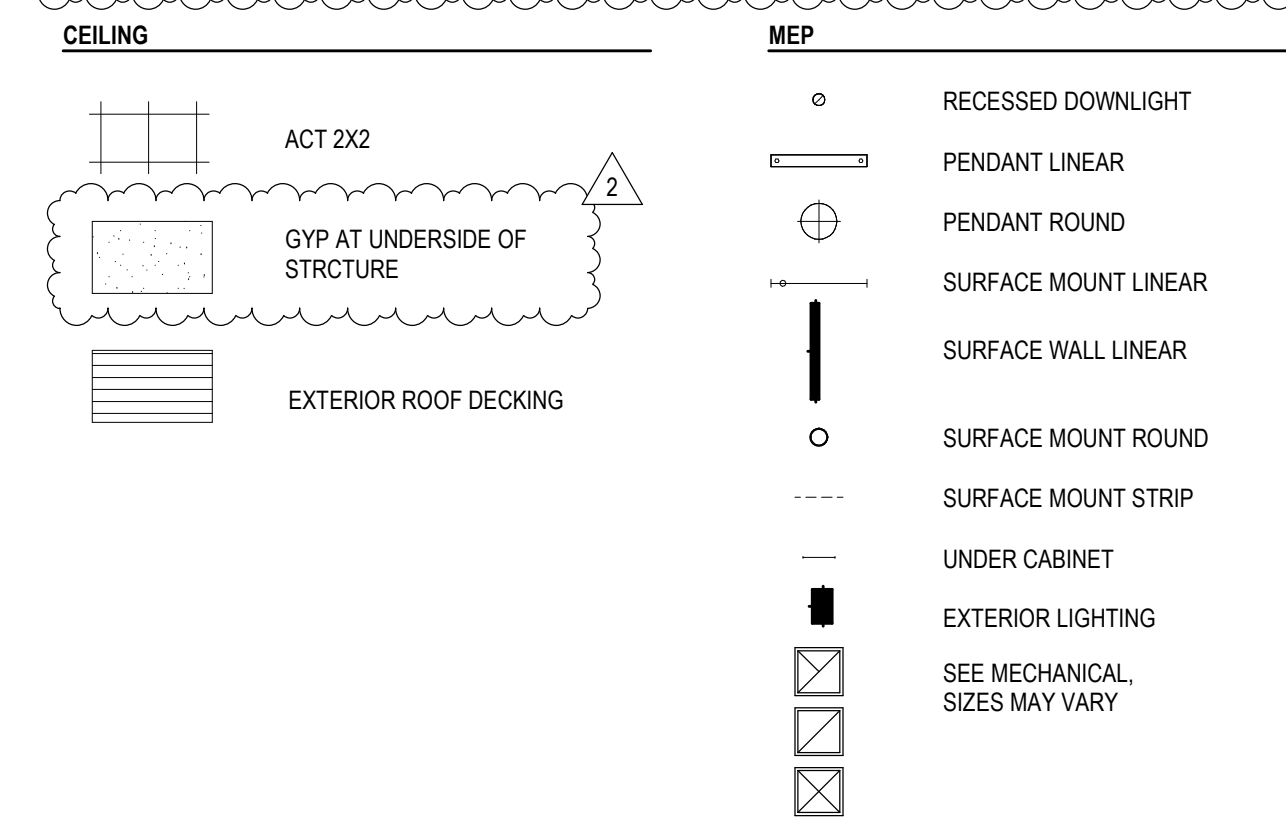[illegible]

EXTERIOR FINISH SCHEDULE								
TAG	SPEC #	MATERIAL	MANUFACTURER	PRODUCT	FINISH	CODE	CONTACT	NOTES
ALUM-1	07 46 16	ALUMINUM SIDING	LONGBOARD	TOUNGUE & GROOVE PLANKS - 6" V-GROOVE PLANK	COLOR: WOODGRAIN - DARK CHERRY	-	ZACH PESZNECKER	VERTICAL INSTALL
ALUM-2	07 46 16	ALUMINUM SIDING	LONGBOARD	PANELBOARD - 6" SMOOTH PLANK	COLOR: ONYX BLACK	-	ZACH PESZNECKER	HORIZONTAL INSTALL
INSUL-1		COCNRETE FACED INSULATION	-	-	-	-	-	-
MTL-1	07 42 13	BOX RIB METAL SIDING	AEP SPAN	BOX RIB	COLOR: COOL DARK BRONZE INSTALL: HORIZONTAL	-	JIM MORELAND	-
MTL-2	07 42 13	BOX RIB METAL SIDING	AEP SPAN	BOX RIB	COLOR: COOL SIERRA TAN INSTALL: VERTICAL	-	JIM MORELAND	-
MTL-3	07 42 13	METAL SOFFIT	AEP SPAN	FLUSH PANEL - 12" VENTED WITH 1 RIB	COLOR: MATTE BLACK	-	JIM MORELAND	FOR USE AT SOFFITS
MTL-4	07 42 13	METAL ROOF	AEP SPAN	SPAN-LOK	COLOR: AEP SPAN MATTE BLACK	-	JIM MORELAND	STANDING SEAM ROOFING
MTL-5	07 42 13	OUTSIDE CORNER TRIM	AEP SPAN		COLOR:	-	JIM MORELAND	-
MTL-6	07 42 13	INSIDE CORNER TRIM	AEP SPAN		COLOR:	-	JIM MORELAND	-
MTL-7	07 42 13	JAMB TRIM	AEP SPAN		COLOR:	-	JIM MORELAND	-
MTL-8	07 42 13	METAL SOFFIT	AEP SPAN	PRESTIGE SERIES - 1 1/2" X 12"	COLOR: MATTE BLACK	-	JIM MORELAND	FOR USE AT ROOF D - PERFORATION 13.8%
P-5	09 91 00	EXTERIOR PAINT	-	-	-	-	-	-
STO-1	07 40 00	STONE VENEER	NORSTONE	XL ROCK PANELS STONE VENEER	COLOR: OCHRE	-	-	-

NOTES & LEGEND - EXTERIOR ELEVATION

1. GRAPHIC REPRESENTATION OF EXTERIOR MATERIALS AND/OR LIGHTING MAY BE NOT TO SCALE.

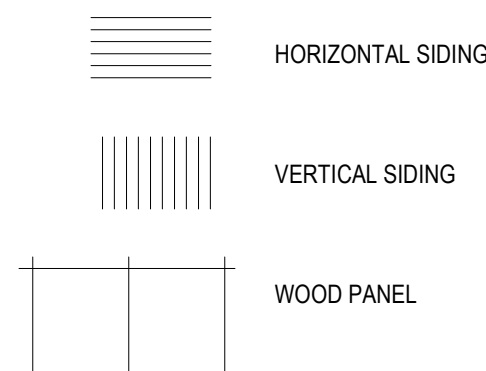


KEYNOTES LEGEND

#	NOTE DESCRIPTION
301	SIGNAGE: TBD
302	METAL FLASHING TRIM - COLOR TO MATCH MTL-5
303	REVEALS - COLOR TO MATCH ALUM-1
304	VINYL WINDOW - COLOR: WHITE
305	DOWNSPOUT - COLOR TO MATCH MTL-5
306	ROOF ACCESS HATCH PER SPEC
307	EXTERIOR LIGHTING
308	DOOR COLOR TO MATCH SIDING COLOR



2 SOUTH ELEVATION
1/8" = 1'-0"

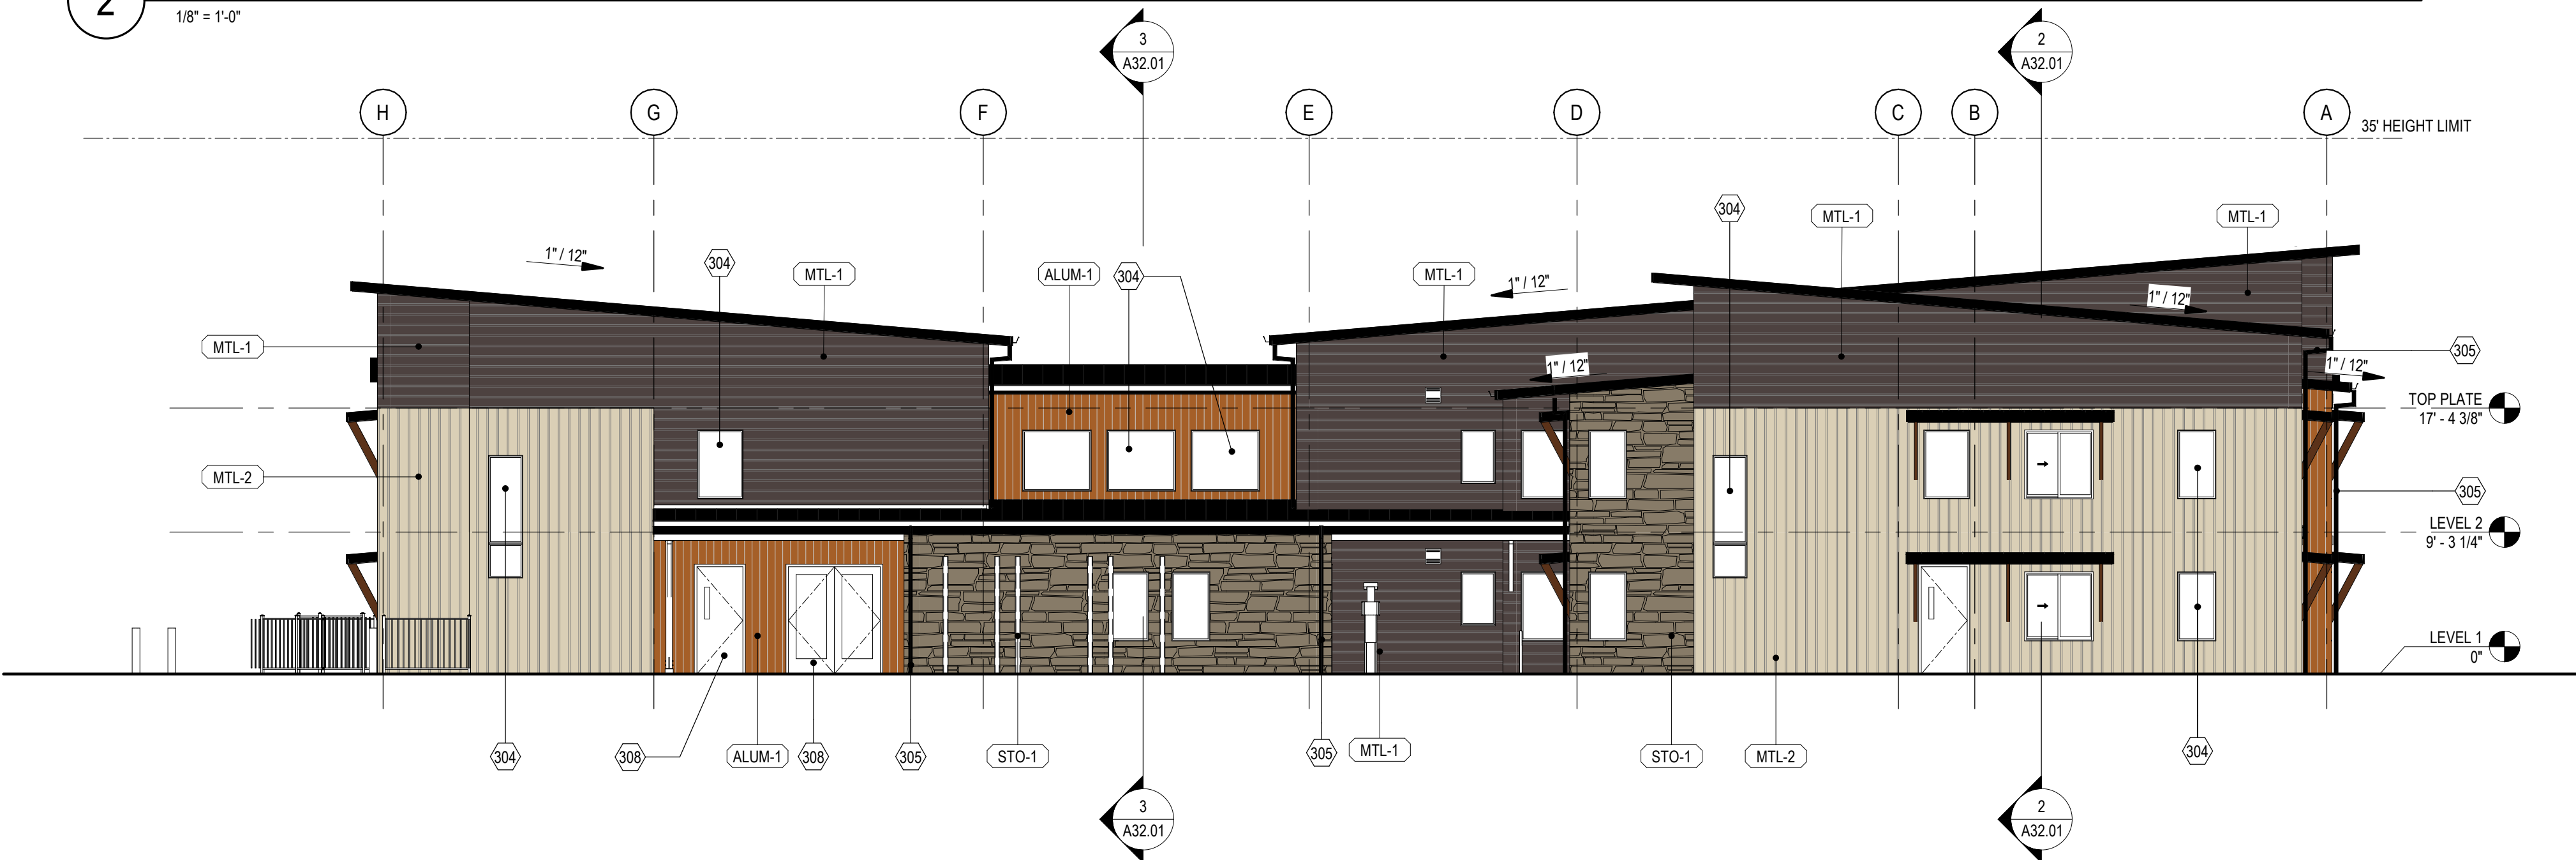

1 WEST ELEVATION
1/8" = 1'-0"

EKLUND AT GALES
PENINSULA HOUSING AUTHORITY
2372 E 7TH AVENUE
PORT ANGELES, WAS 98362

PROJECT # 2023093.02

PERMIT SET

ISSUE DATE JULY 26, 2026

REVISION SCHEDULE


2 ADDENDUM #2 08/21/2026

AHJ APPROVAL STAMP


WALL SECTIONS

SHEET #

A33.02

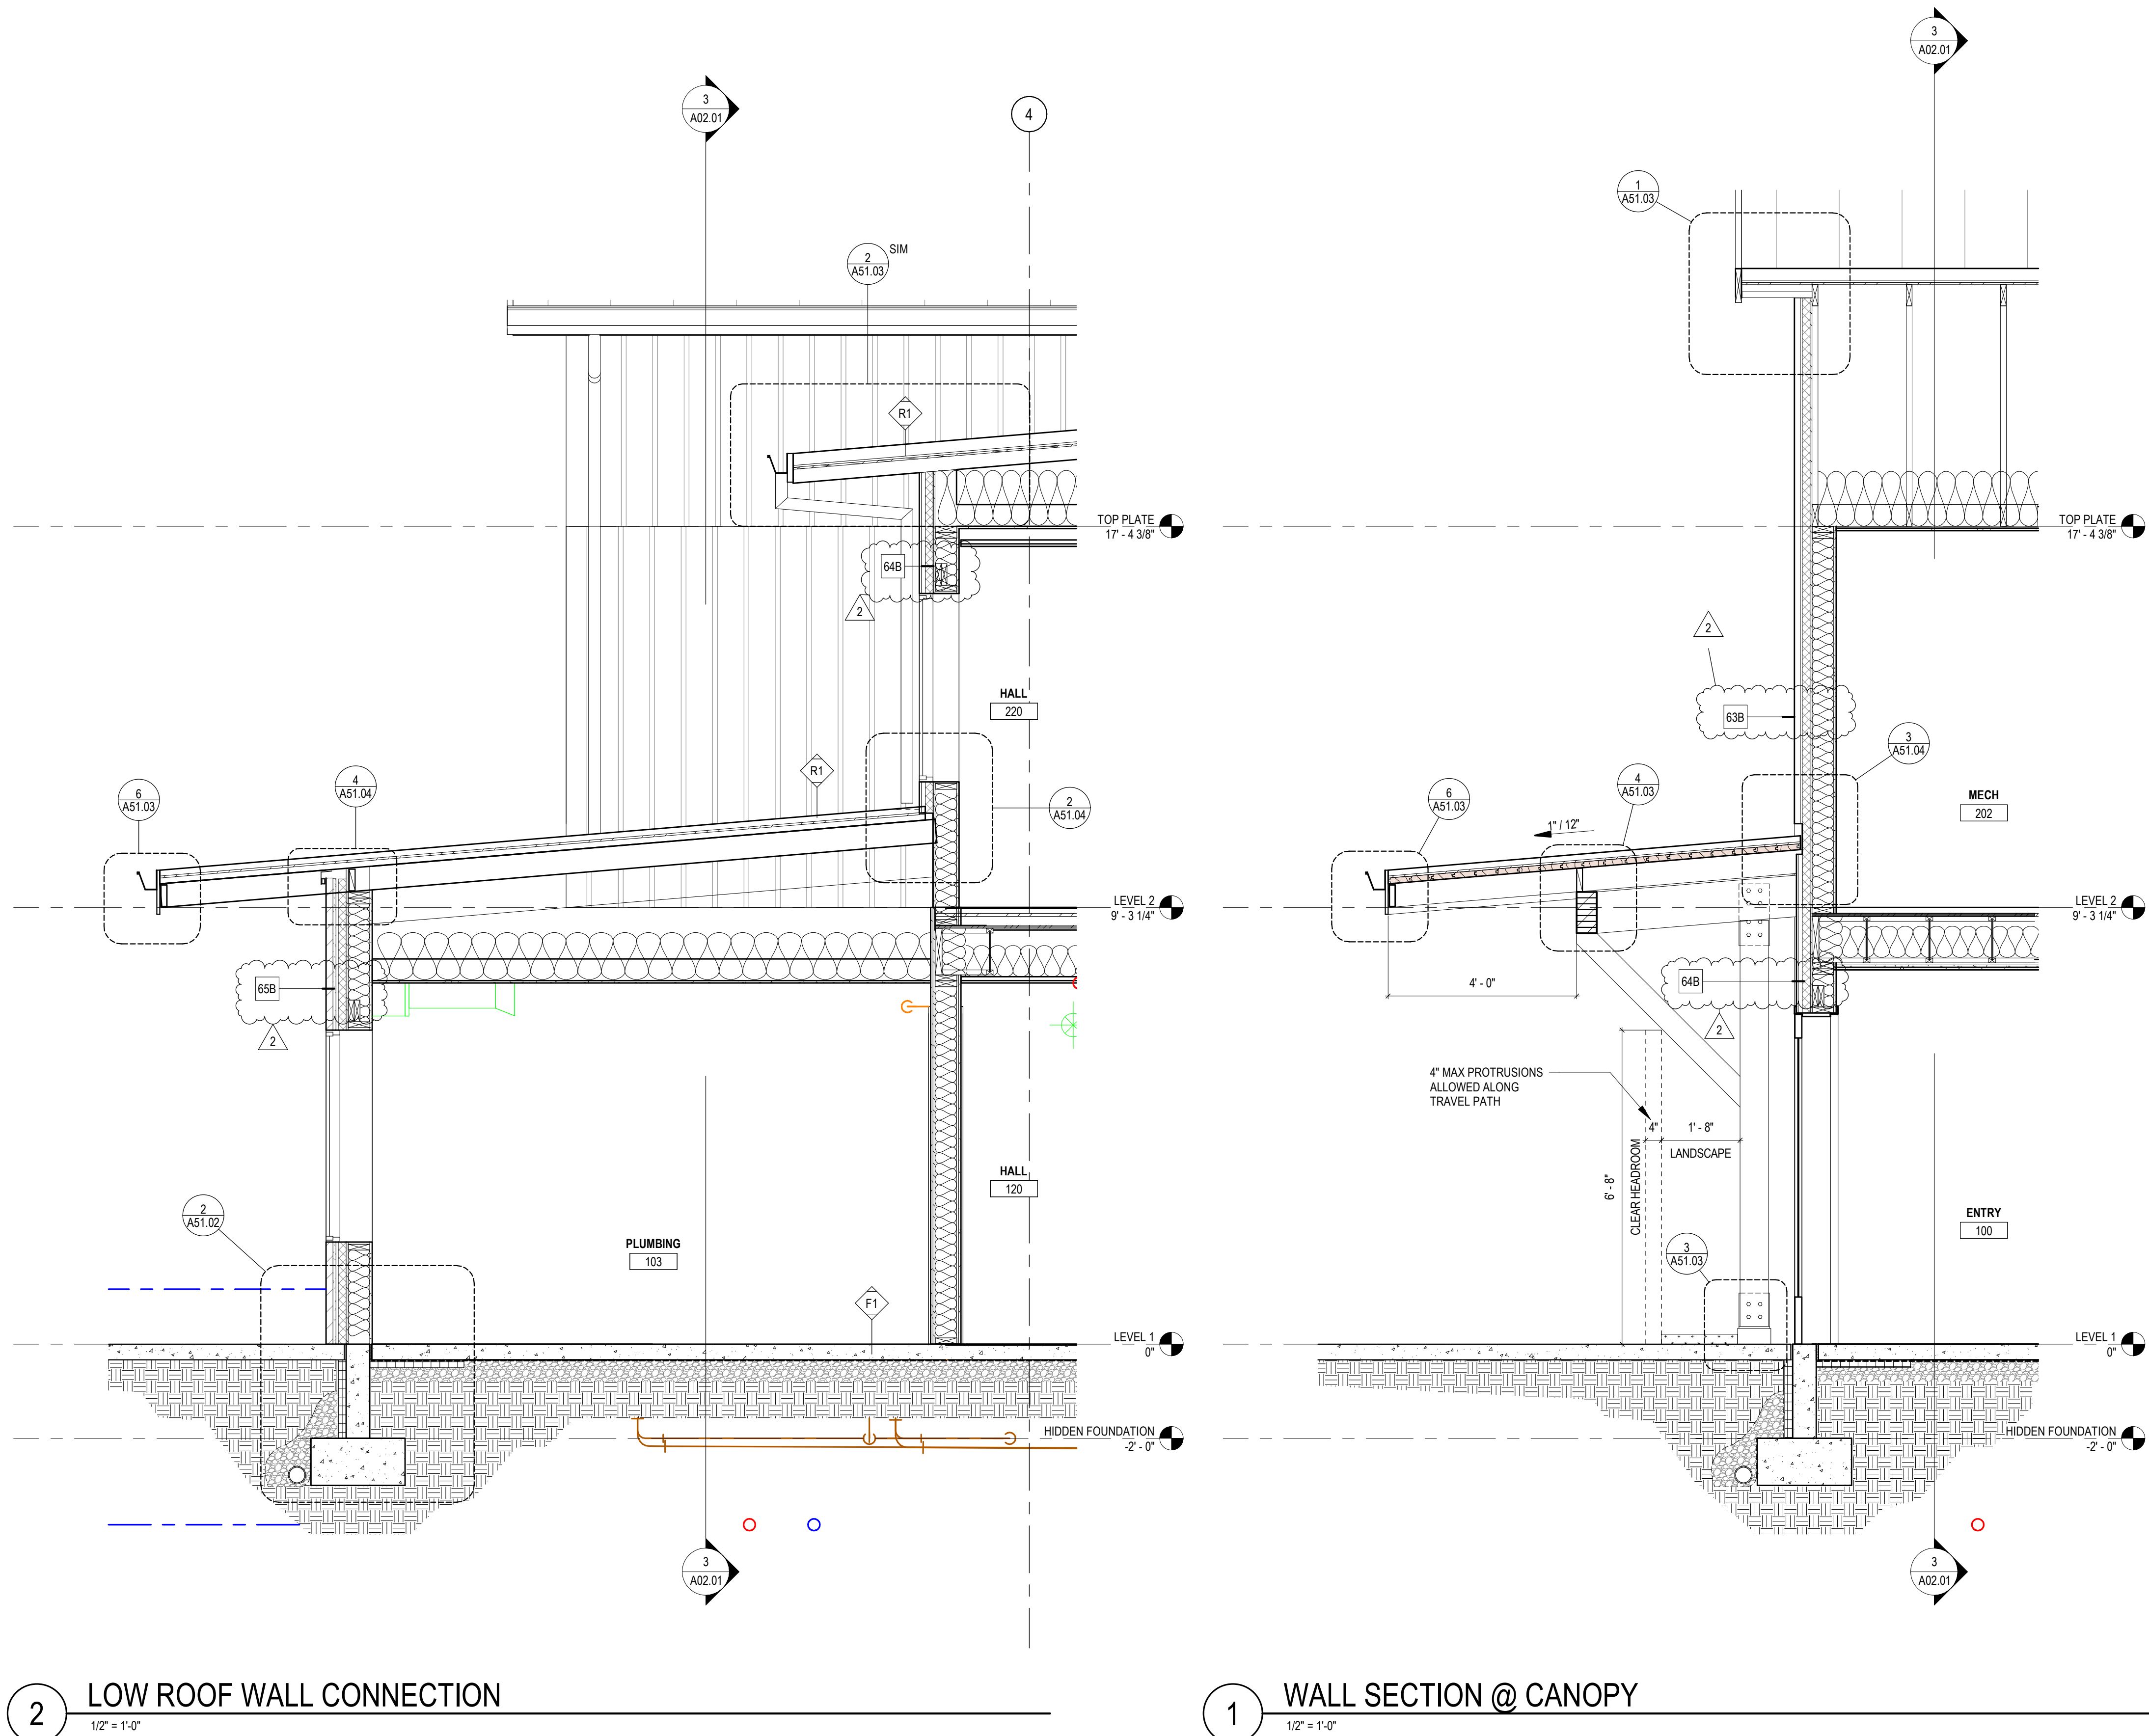

TYPICAL MOUNTING HEIGHTS, UNO

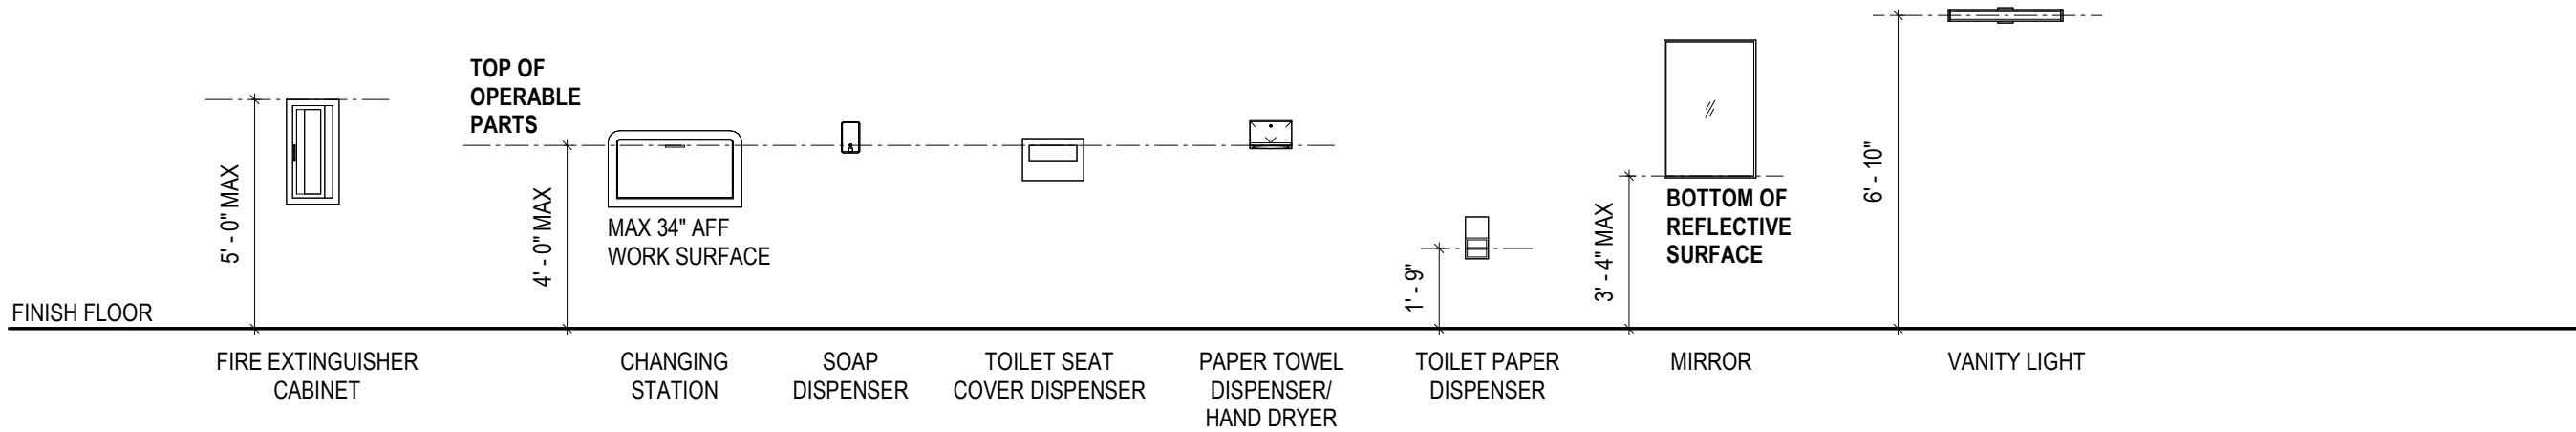

NOTES & LEGEND - INTERIOR ELEVATIONS

1. REFERENCE FINISH PLAN OR FINISH SCHEDULE FOR TYPICAL ROOM FINISHES NOT SHOWN.
2. REFERENCE TYPICAL MOUNTING HEIGHTS UNLESS MOUNTING HEIGHT IS NOTED OTHERWISE.
3. GRAPHIC REPRESENTATION OF MATERIALS AND/OR FIXTURES MAY NOT BE TO SCALE.
4. REFERENCE INTERIOR DETAILS FOR TYPICAL FINISH TRANSITIONS.

RICE*fergus***MILLER**
ARCHITECTURE INTERIORS PLANNING VIZLAB
275 FIFTH STREET, SUITE 100
BREMERTON, WA 98337
360-377-8773
RFMARCH.COM

20104600
REGISTERED
ARCHITECT
DEAN E. KELLY
STATE OF WASHINGTON

EKLUND AT GALES
PENINSULA HOUSING AUTHORITY
2372 E 7TH AVENUE
PORT ANGELES, WAS 98362




PROJECT #	2023093.02
PERMIT SET	
ISSUE DATE	JULY 26, 2026
REVISION SCHEDULE	
2	ADDENDUM #2 08/21/2026

AHJ APPROVAL STAMP

INTERIOR ELEVATIONS

SHEET #

A34.01

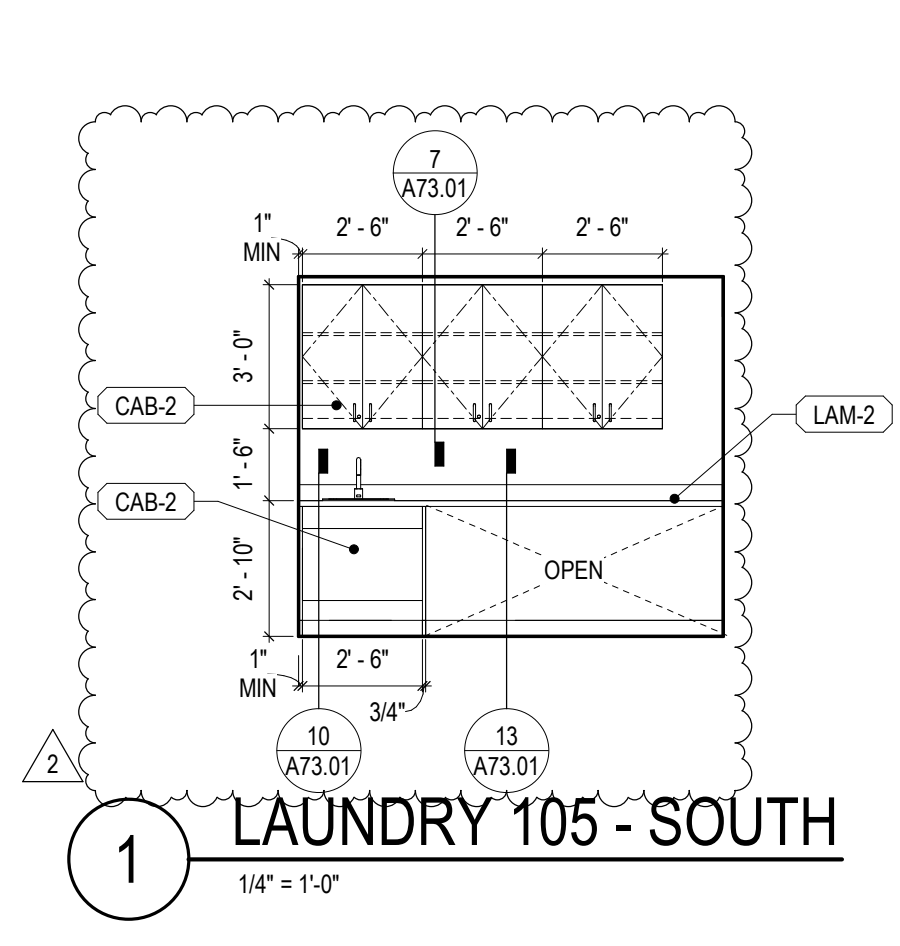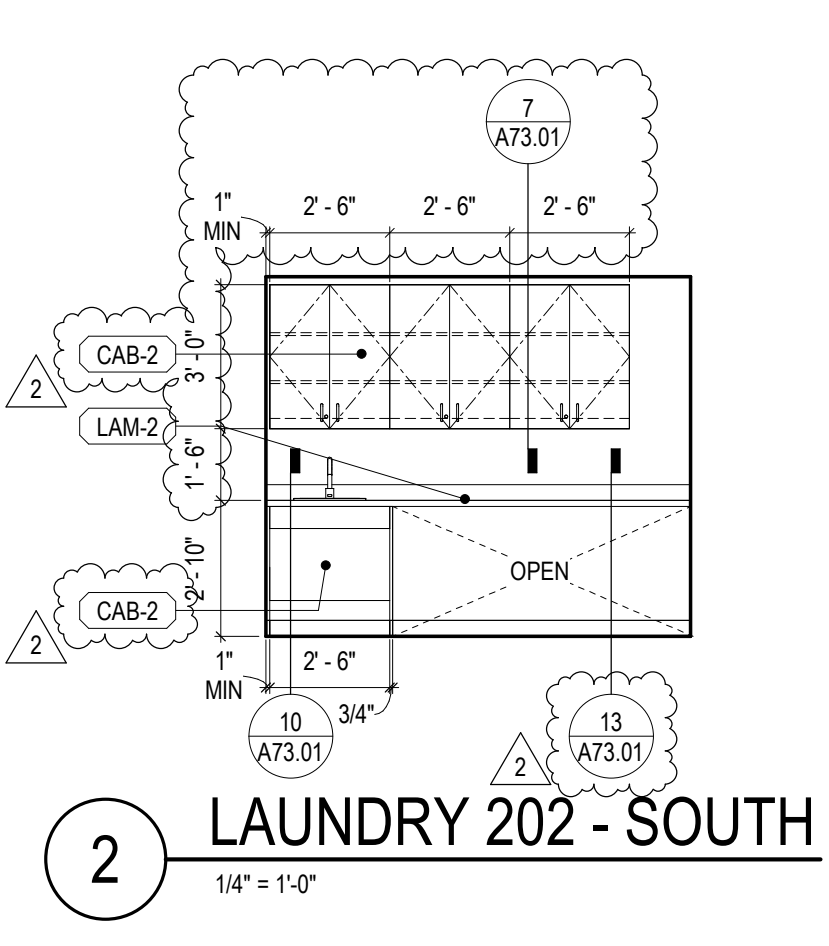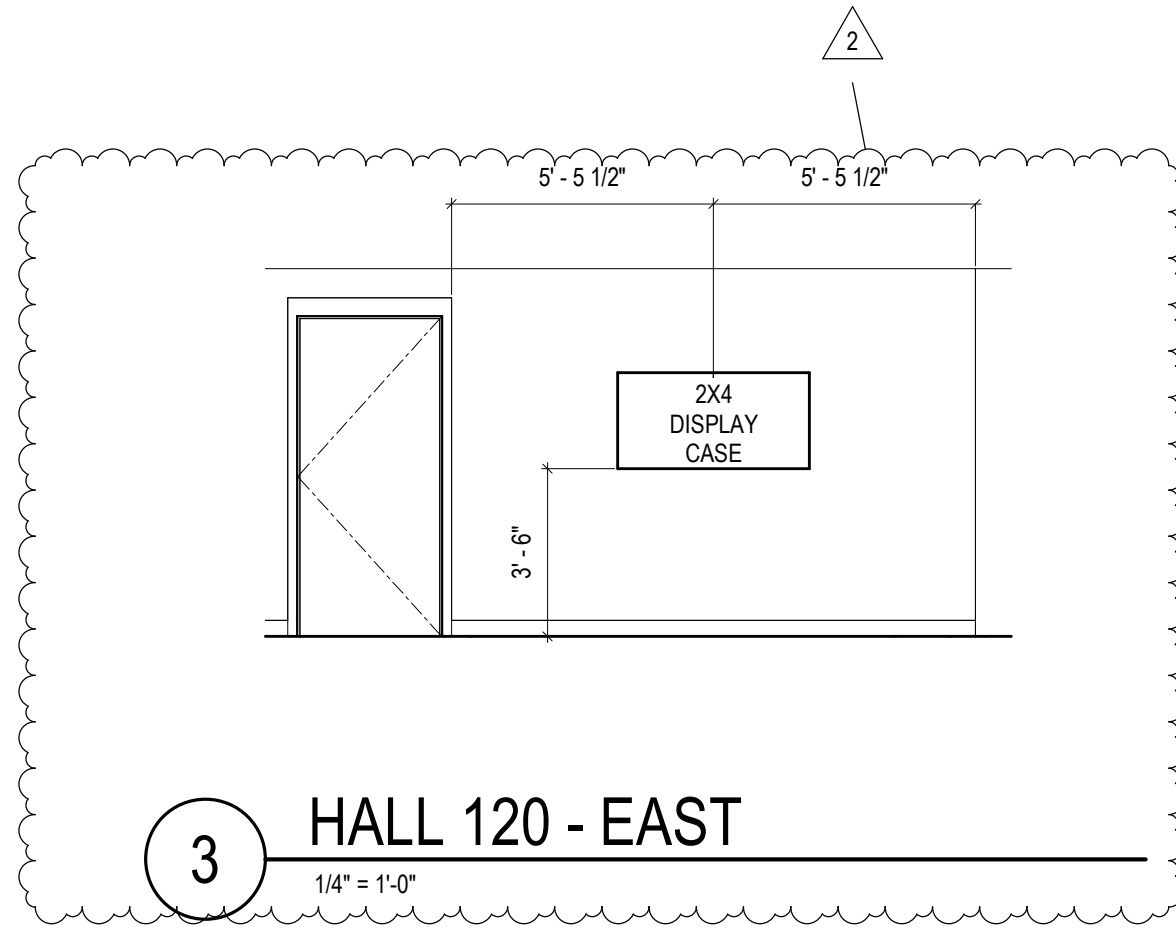


PROJECT #	2023093.02
PERMIT SET	
ISSUE DATE	JULY 26, 2026
REVISION SCHEDULE	
2	ADDENDUM #2 08/21/2026




VERTICAL
CIRCULATION DETAILS

SHEET #


A40.03

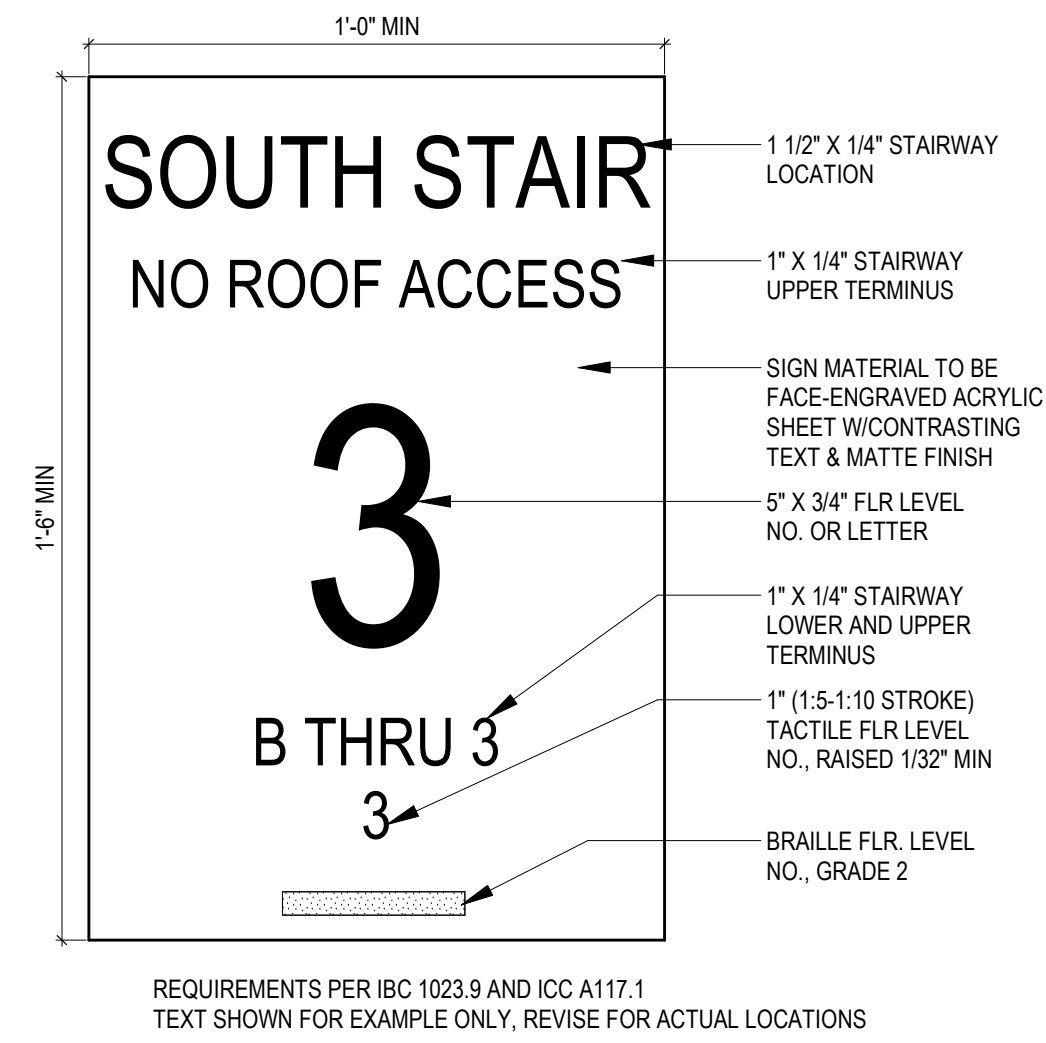


4 TYP STAIR NUMBERING SIGN
3" = 1'-0"

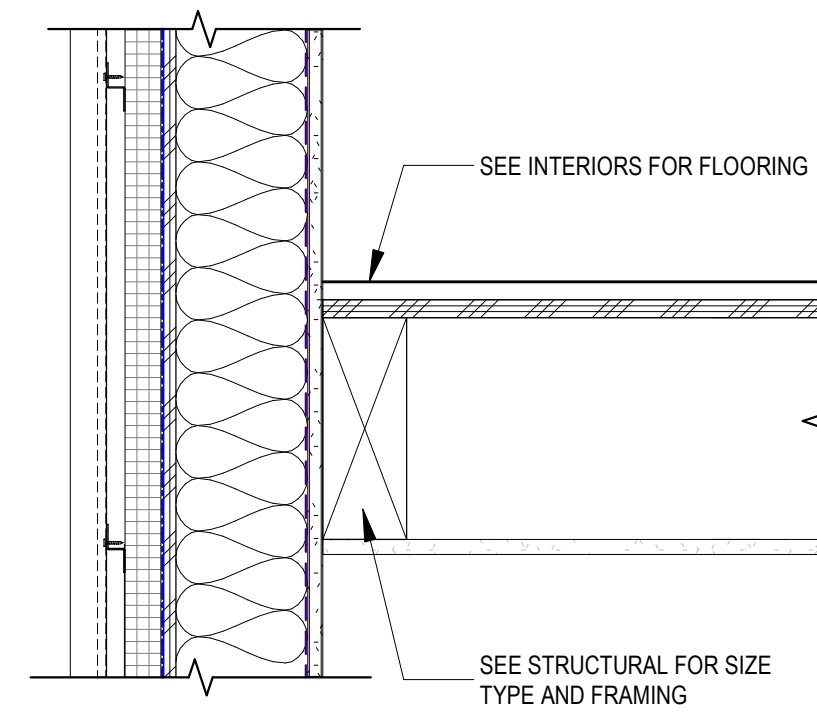


3 STAIR LANDING @ EXTERIOR WALL
1 1/2" = 1'-0"

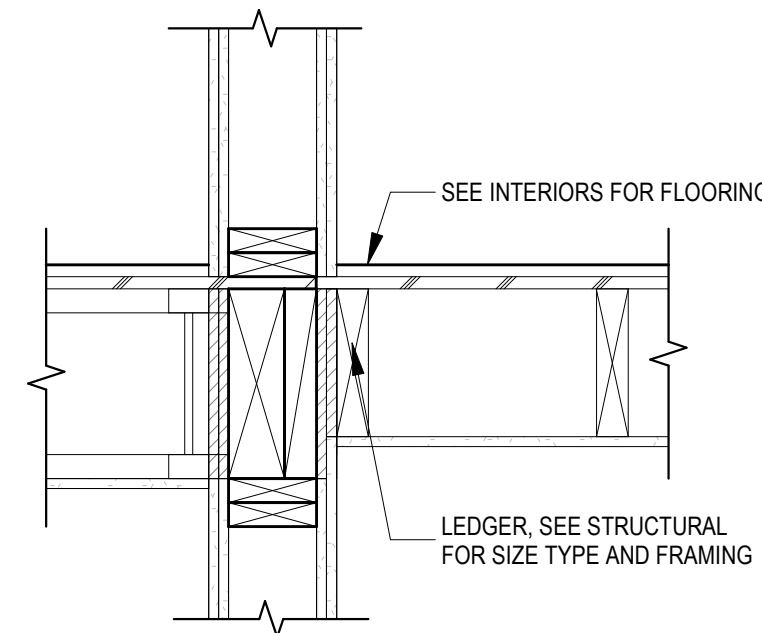


2 STAIR LANDING @ FRAMED FLOOR
1" = 1'-0"

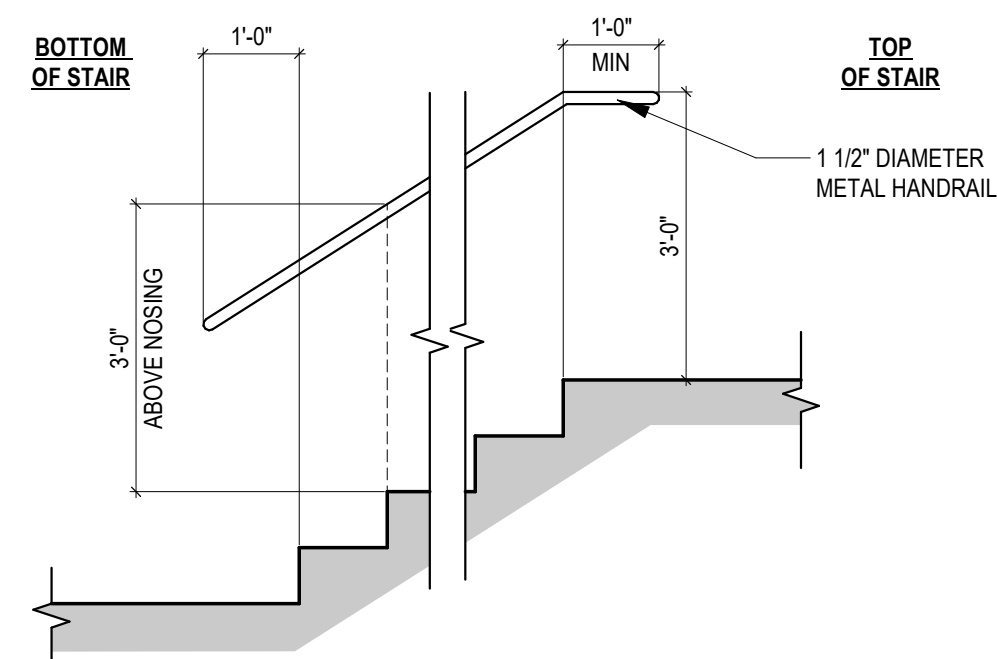



1 TYP HANDRAIL ELEVATION
1/2" = 1'-0"

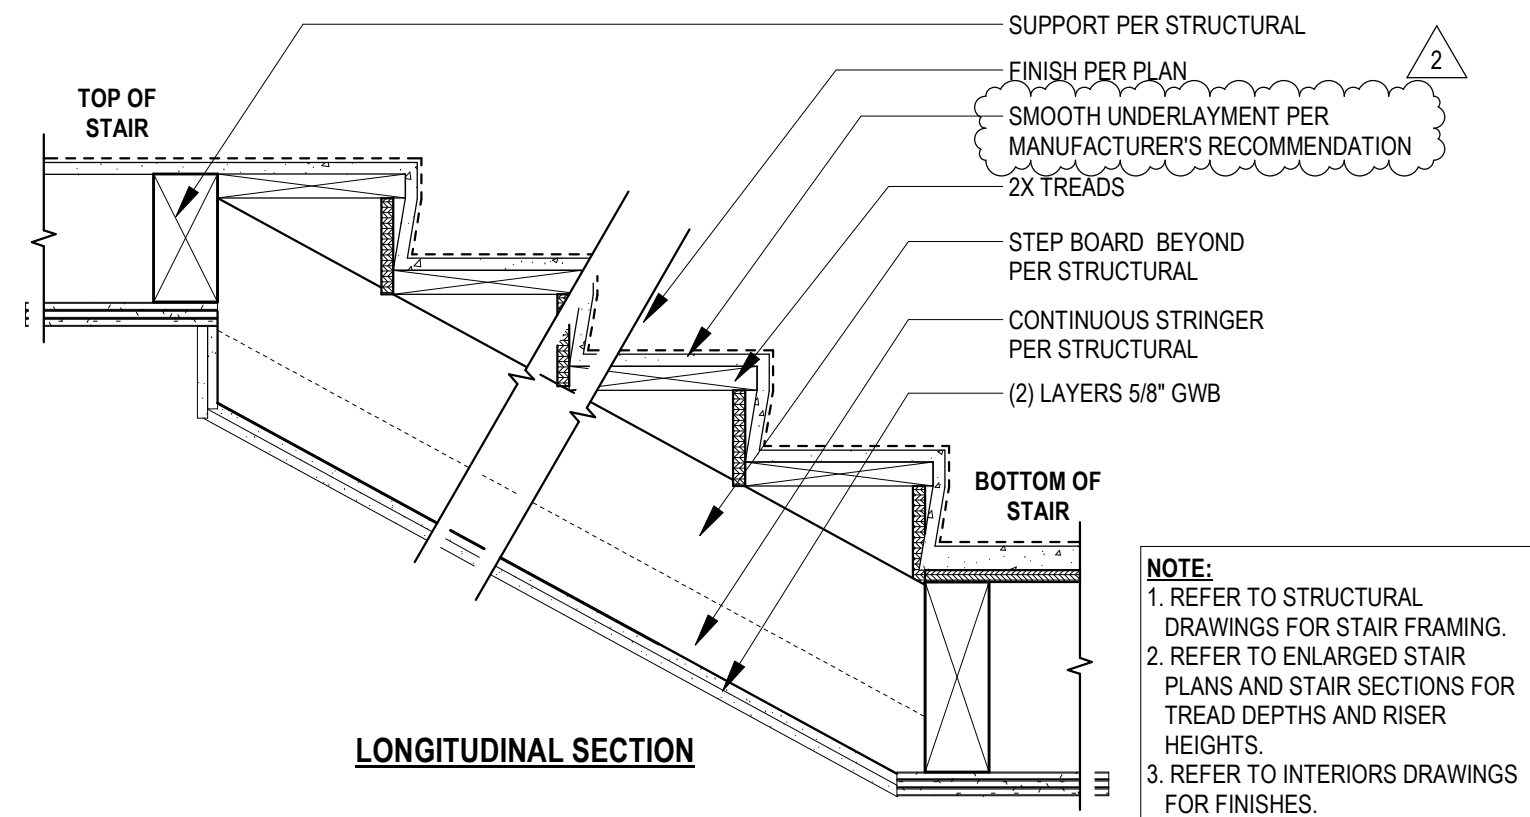

6 TYP WOOD STAIR SECTIONS
1" = 1'-0"

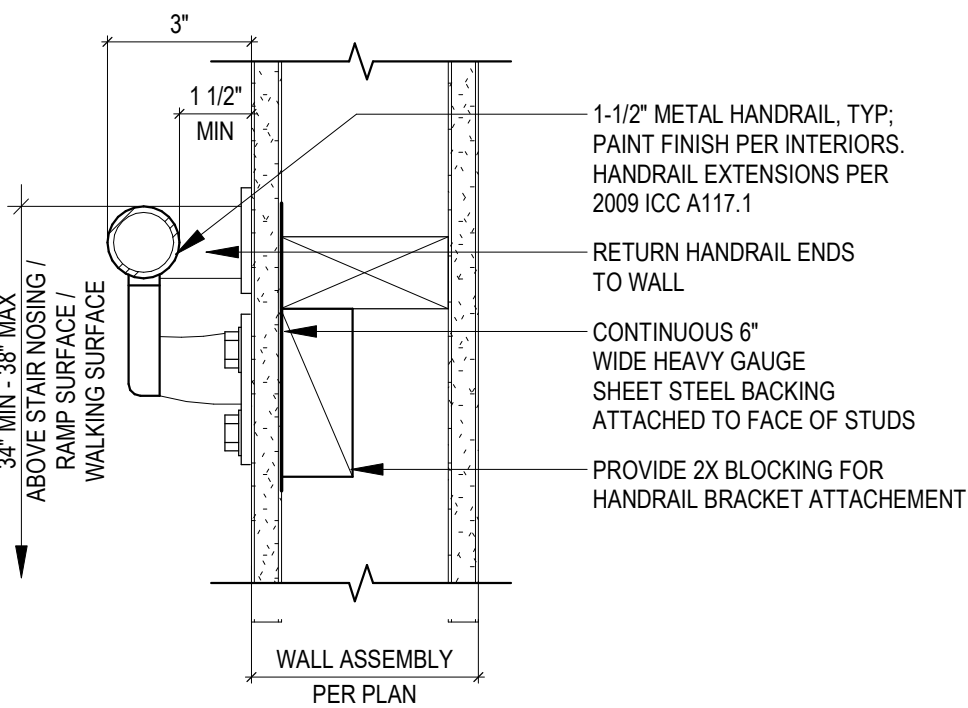


5 TYP HANDRAIL DETAILS
3" = 1'-0"

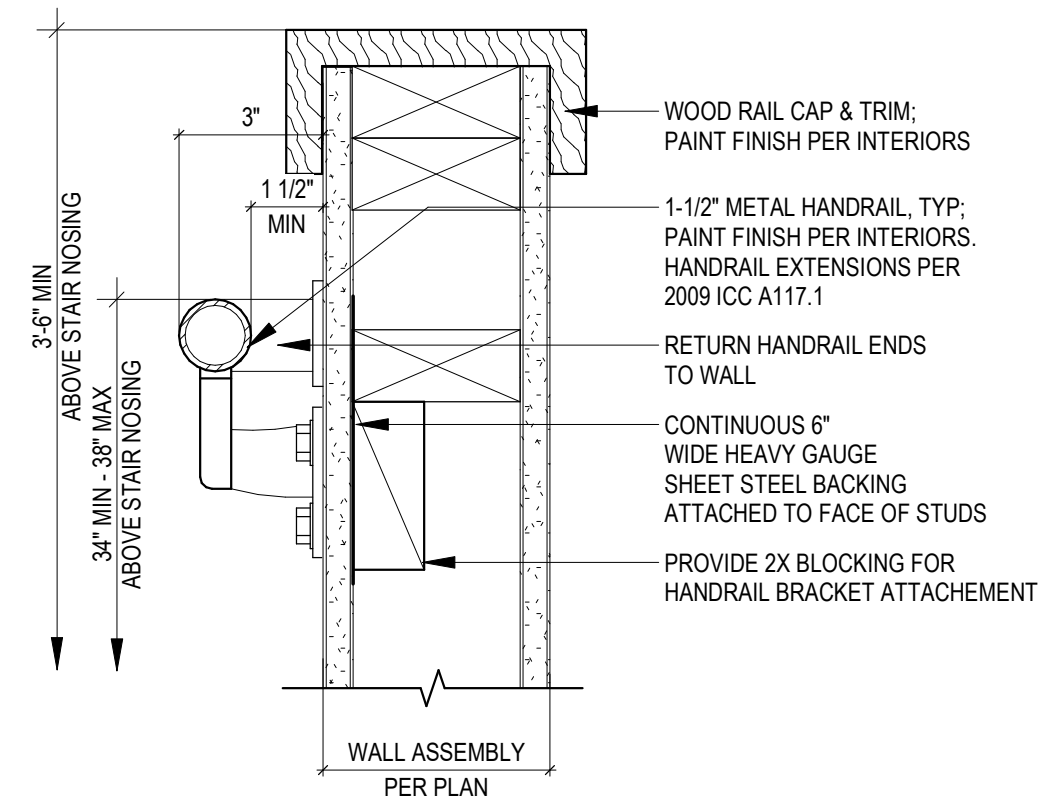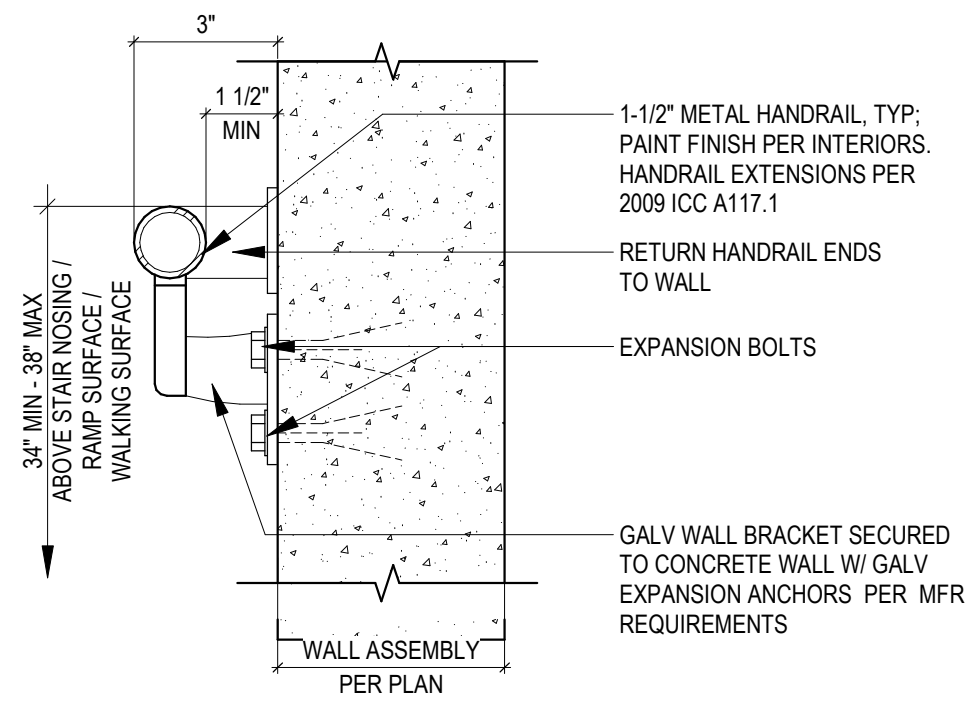

PROJECT #		2023093.02
PERMIT SET		
ISSUE DATE		JULY 26, 2026
REVISION SCHEDULE		
2	ADDENDUM #2	08/21/2026
AHJ APPROVAL STAMP		

SHEET #

A51.01

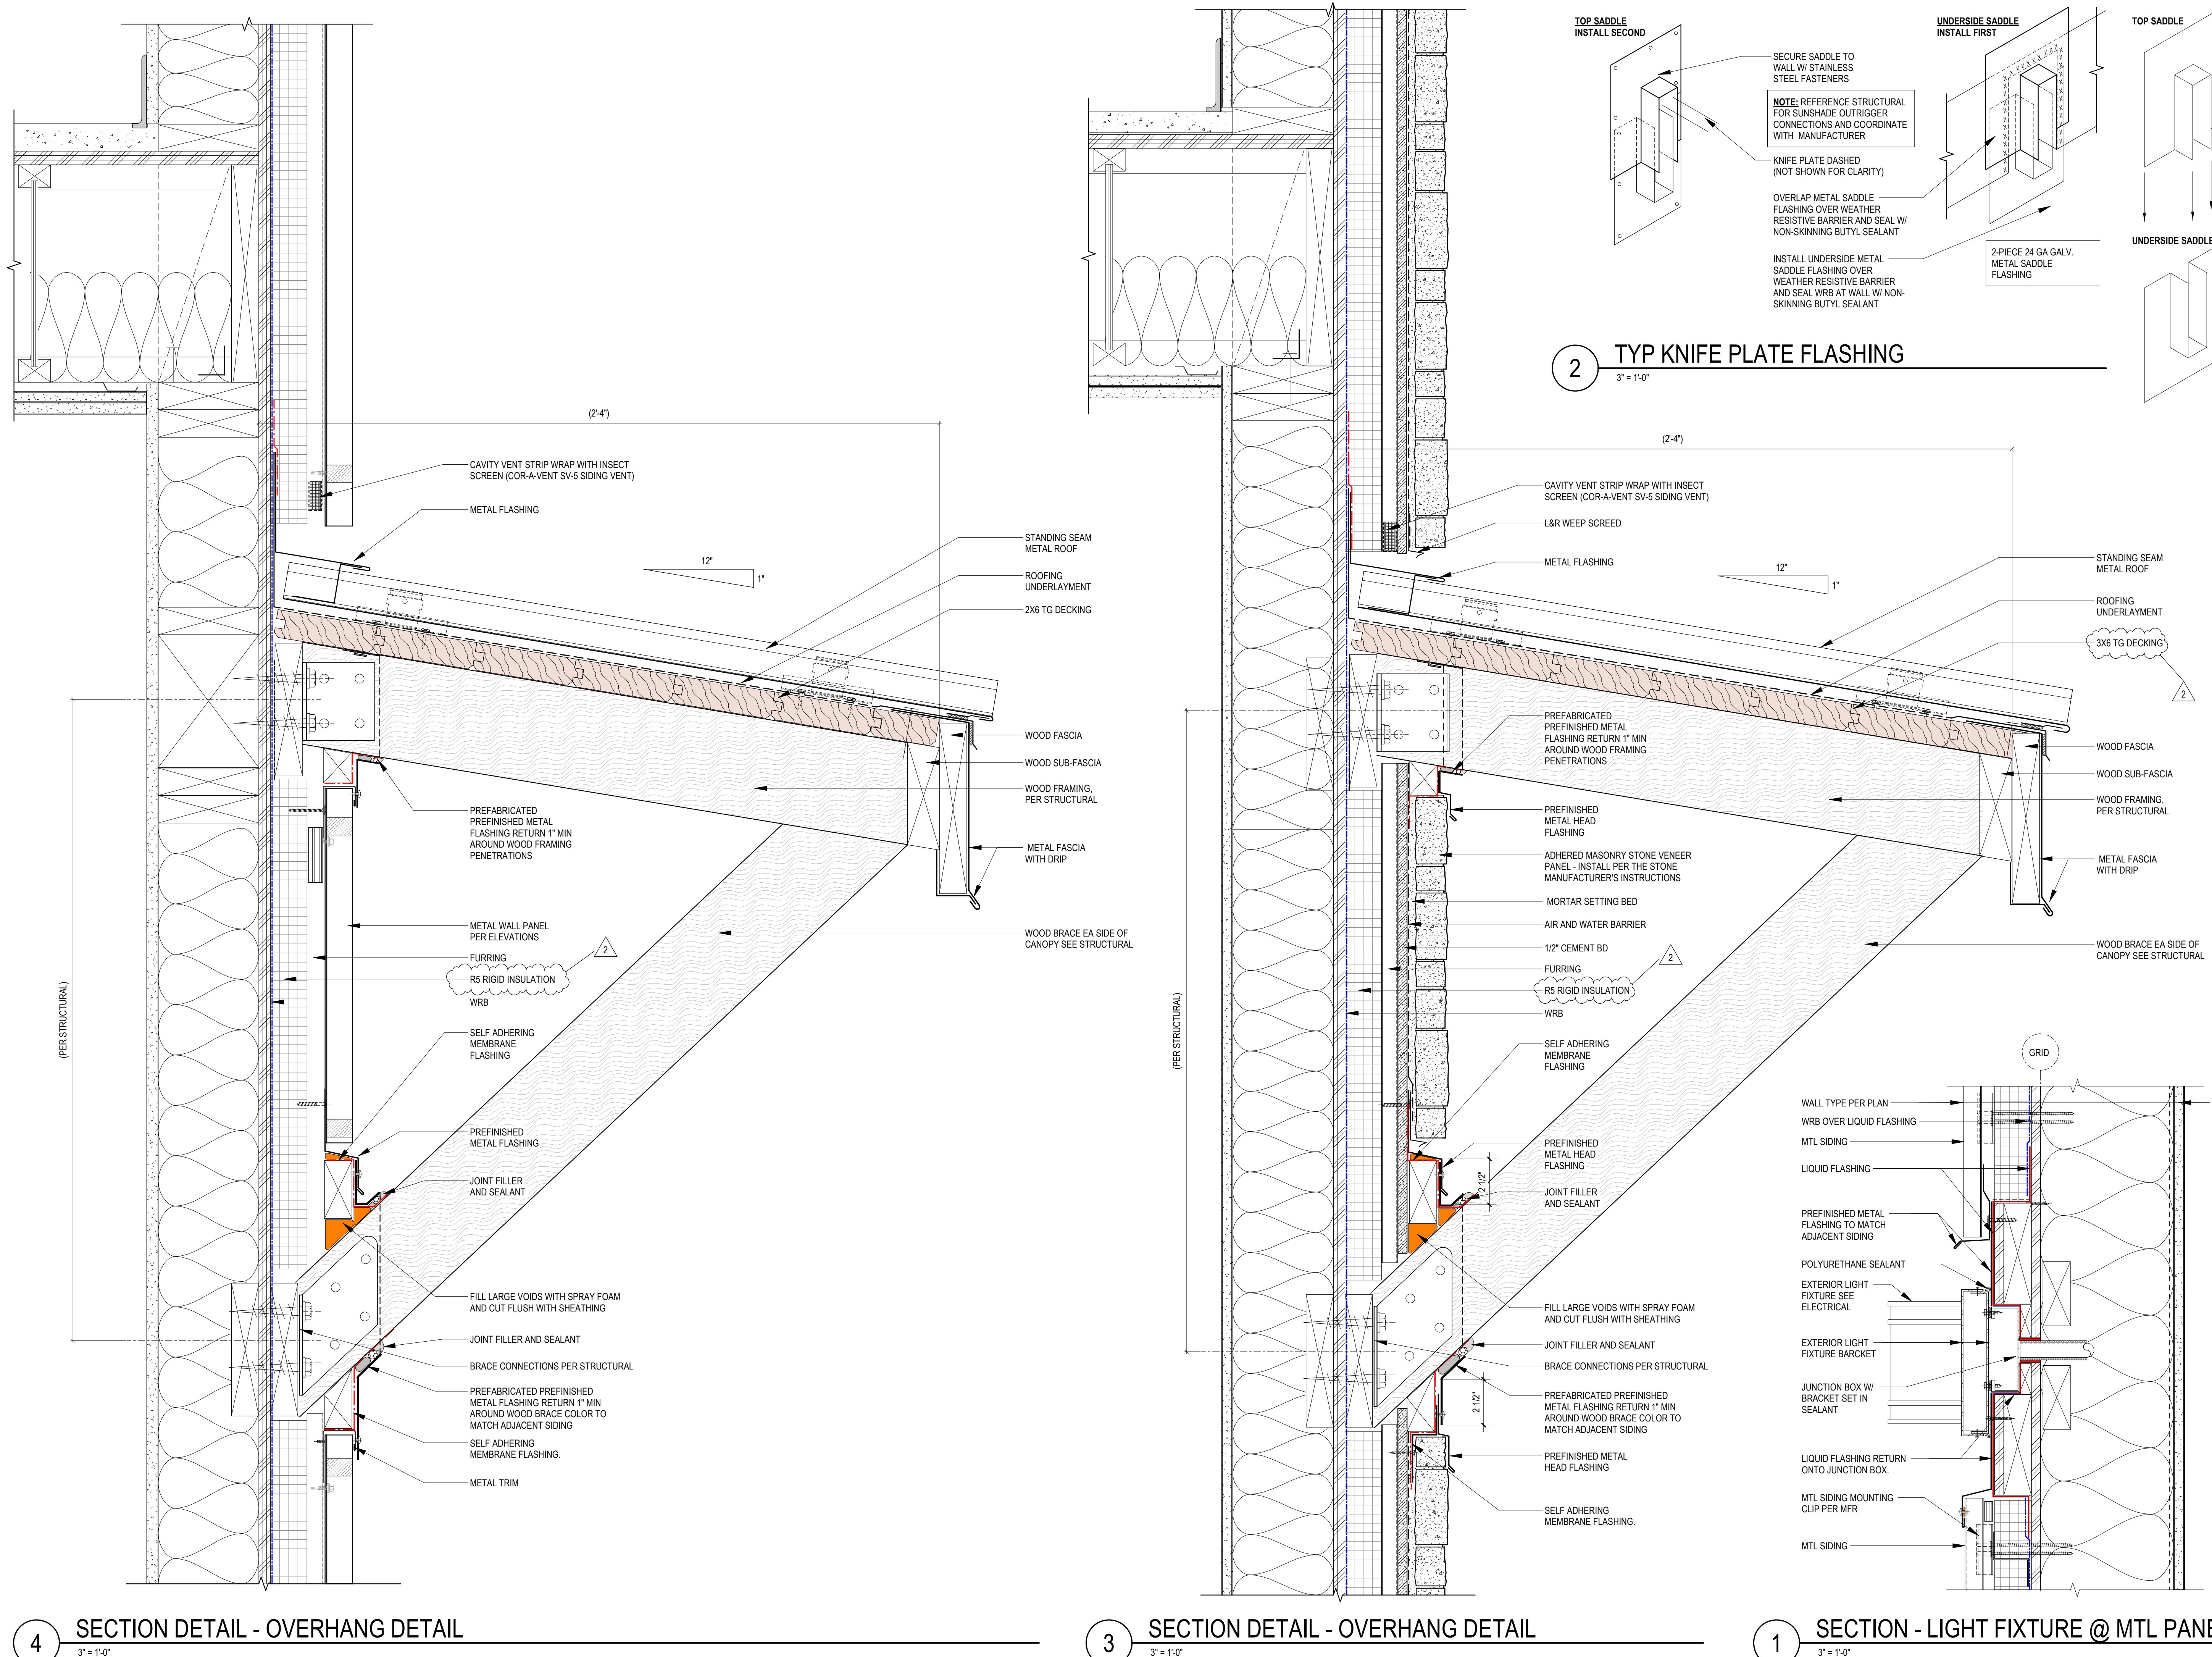

EKLUND AT GALES
PENINSULA HOUSING AUTHORITY
2372 E 7TH AVENUE
PORT ANGELES, WAS 98362

PROJECT # 2023093.02

PERMIT SET

ISSUE DATE JULY 26, 2026

REVISION SCHEDULE











2 ADDENDUM #2 08/21/2026

AHJ APPROVAL STAMP

EXTERIOR DETAILS

SHEET #

A51.02

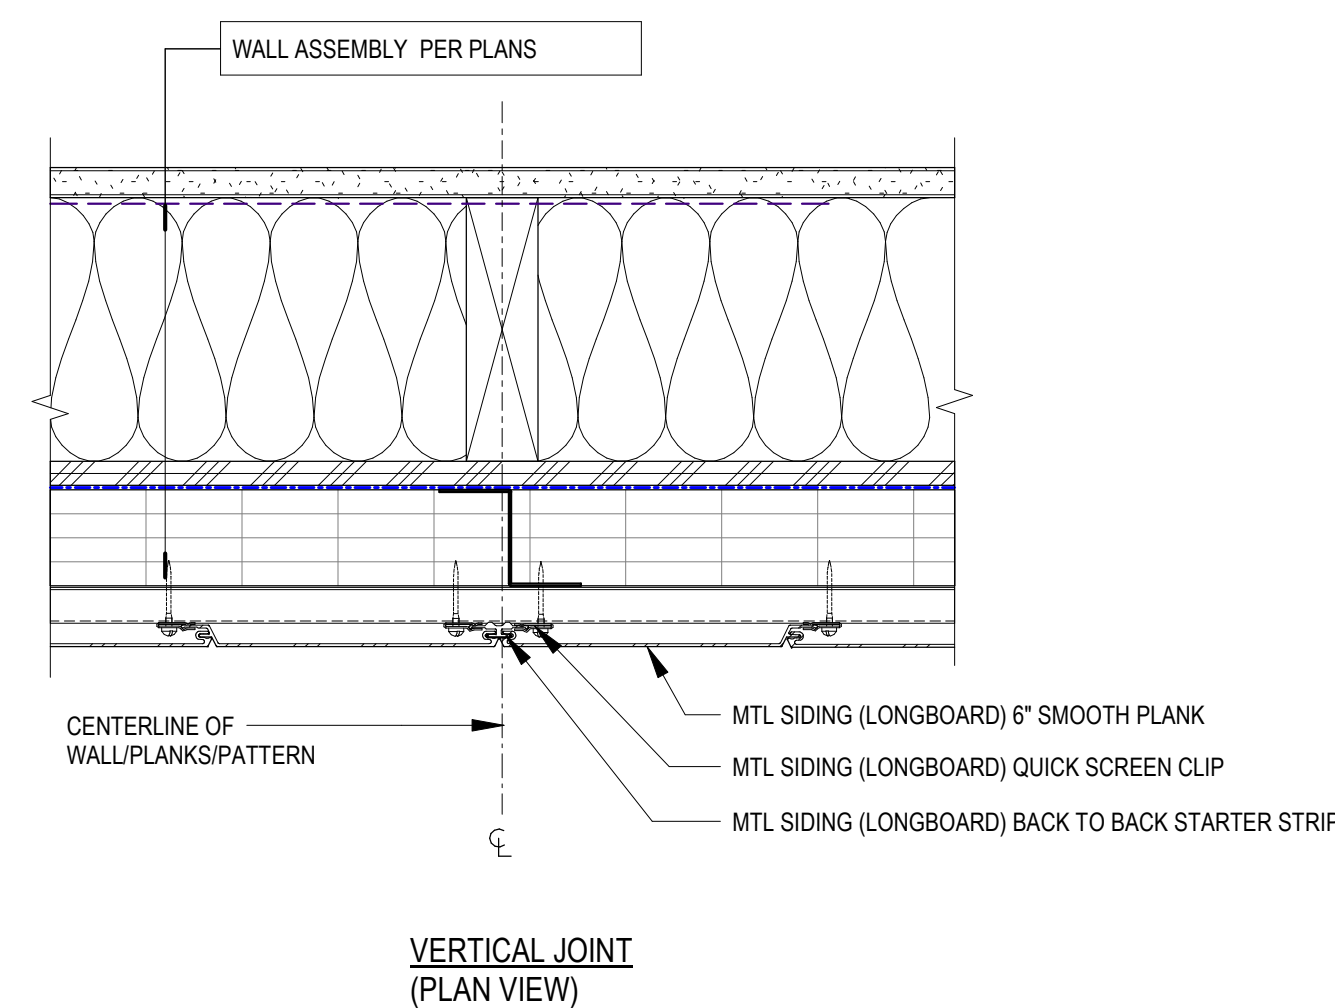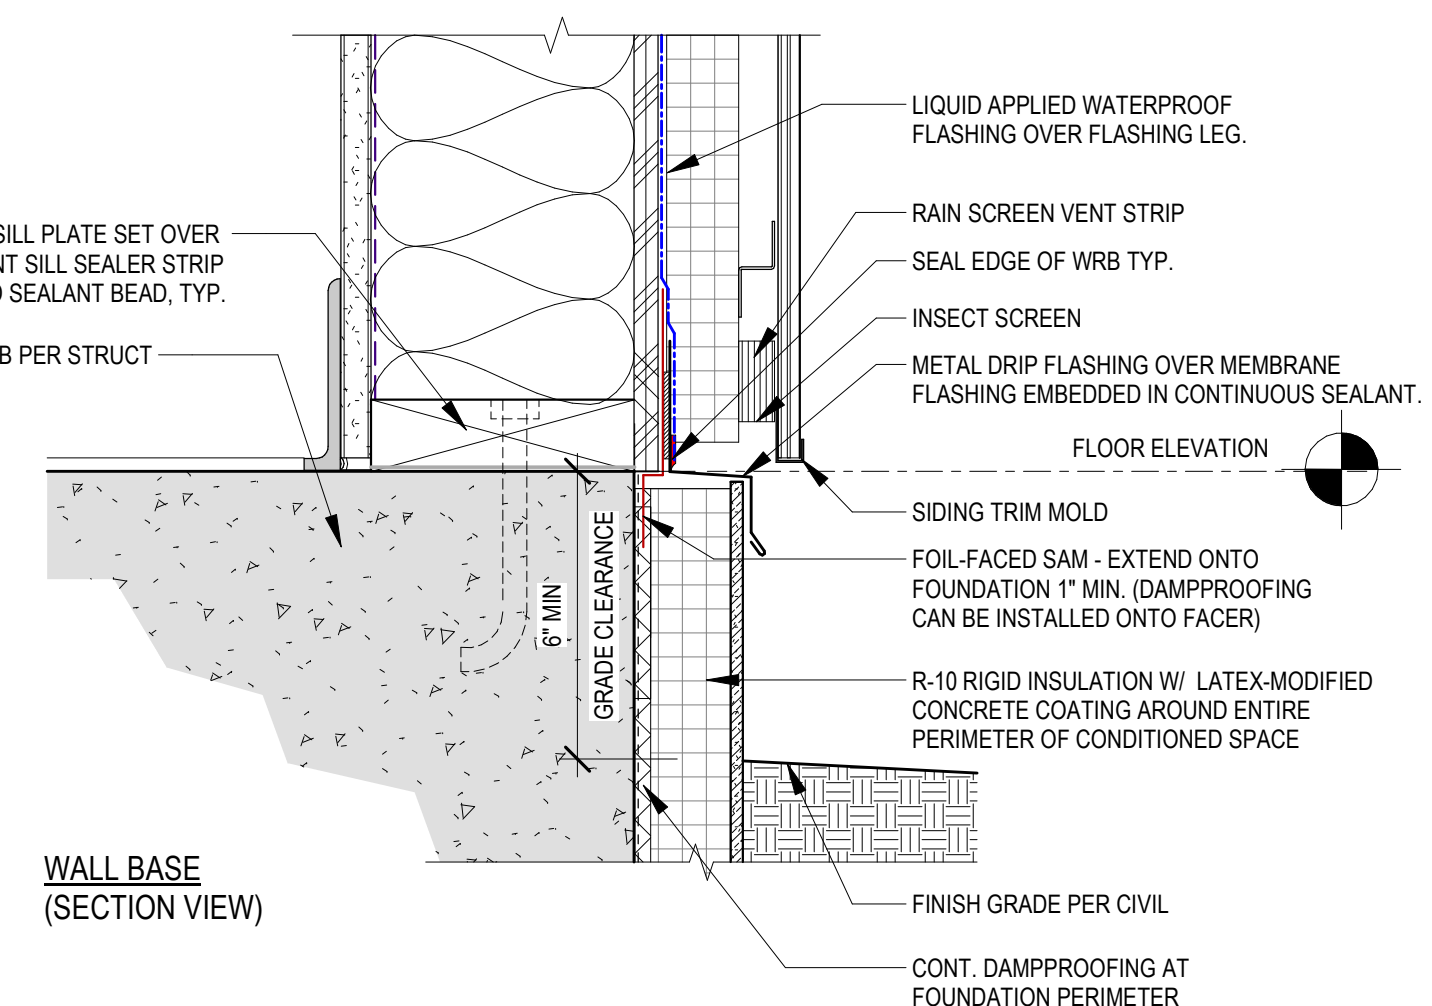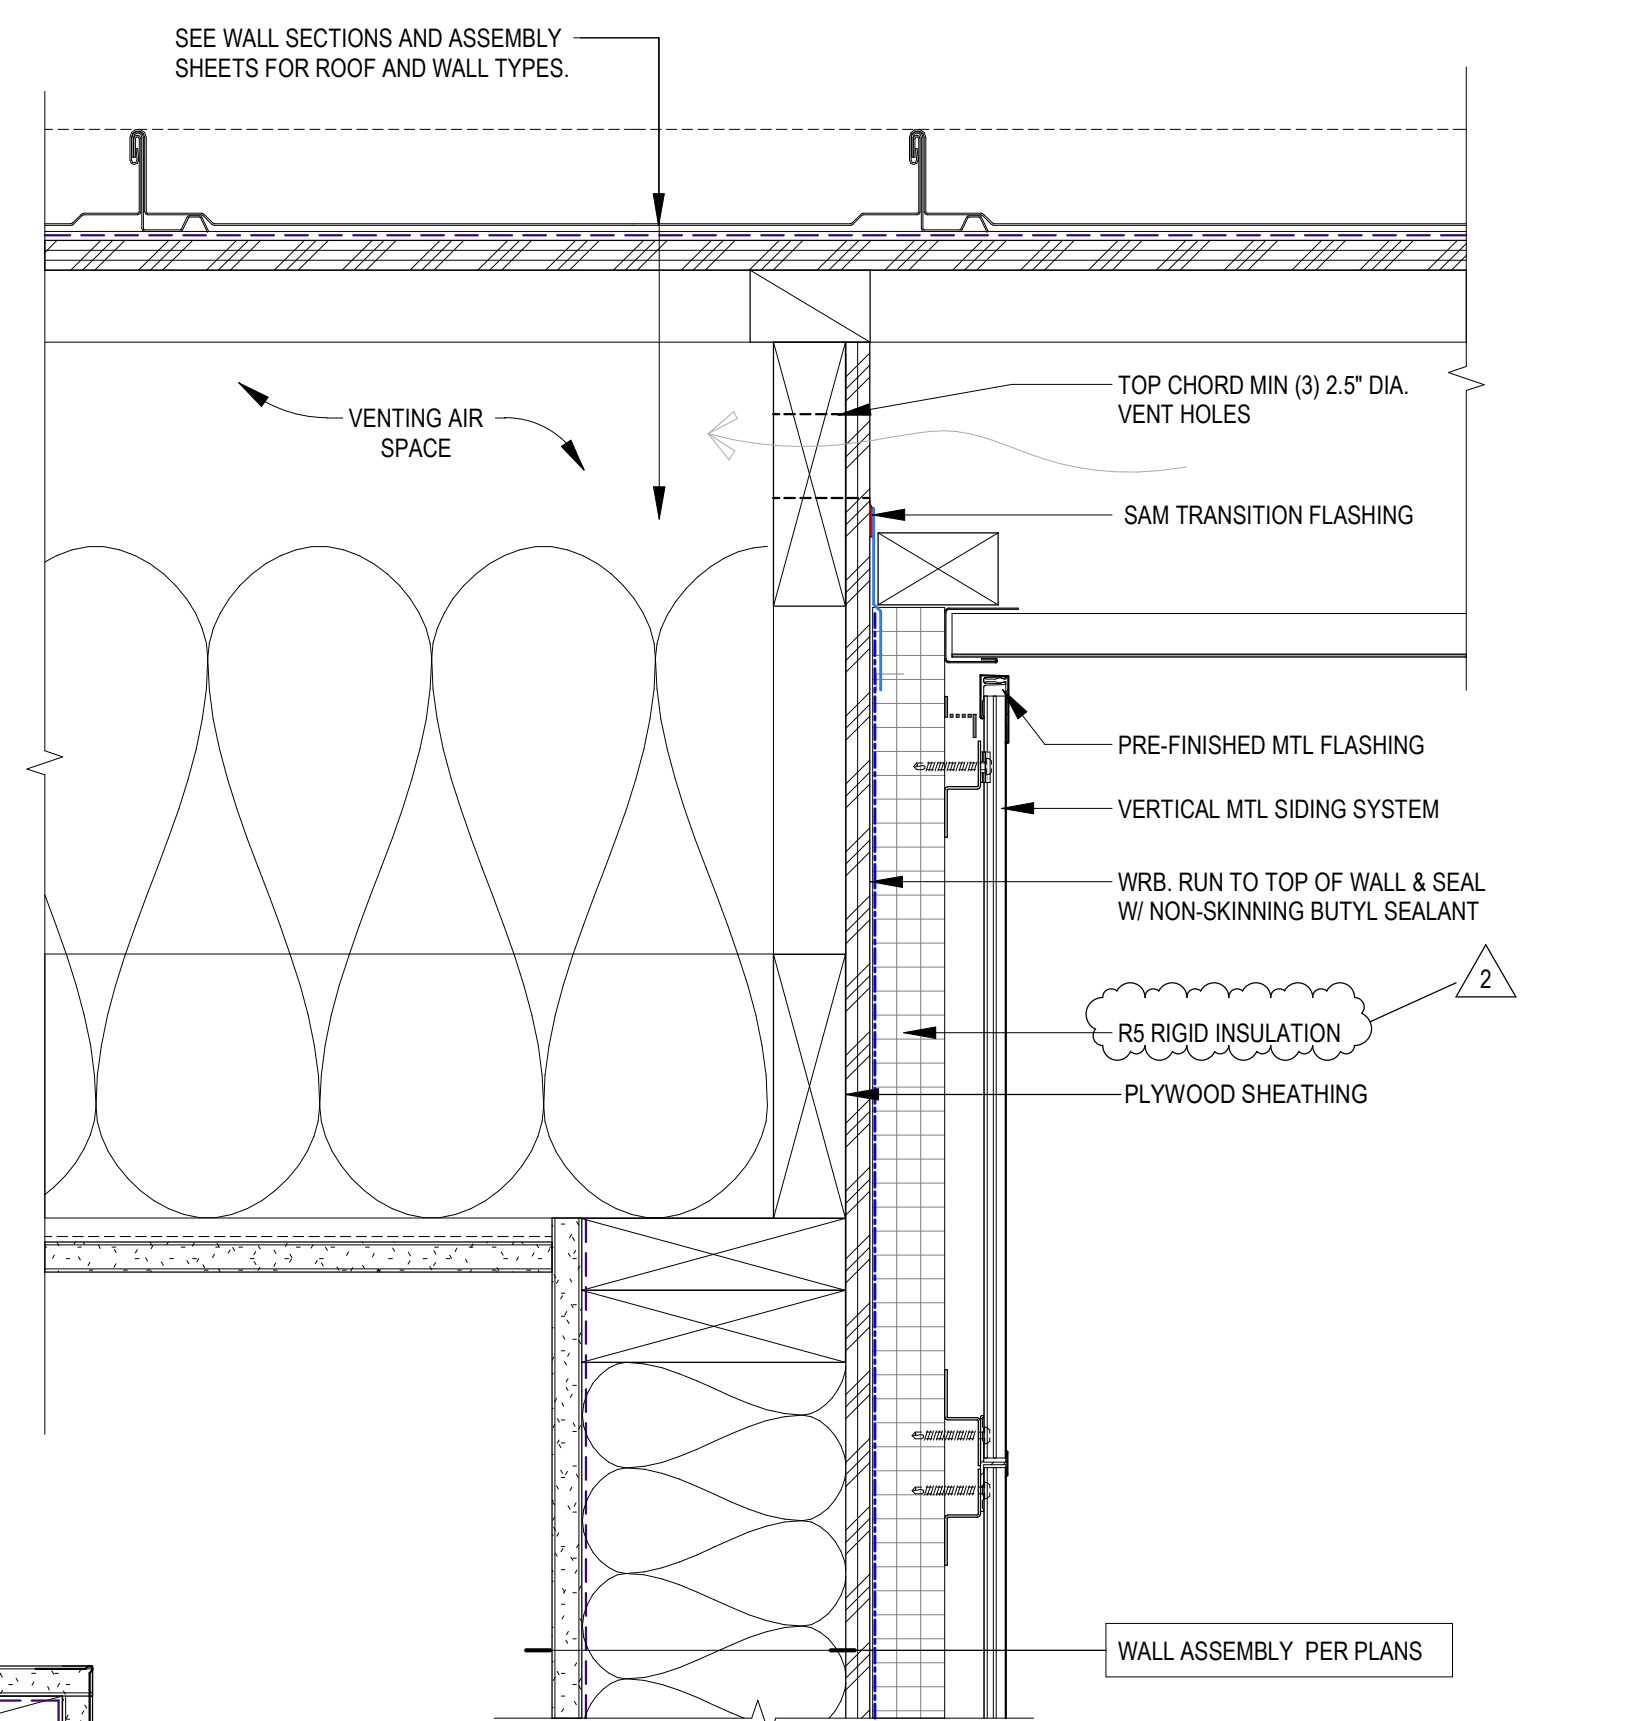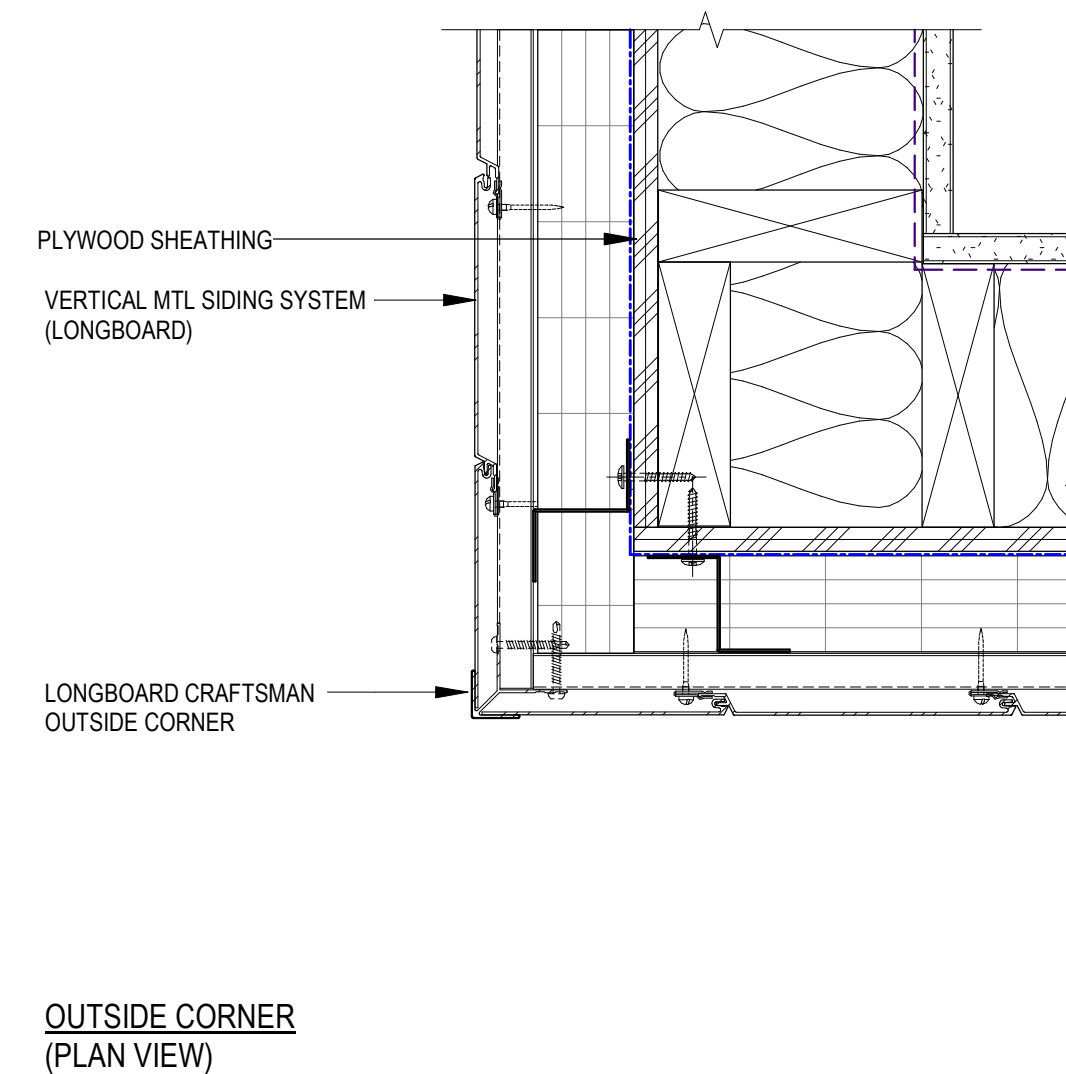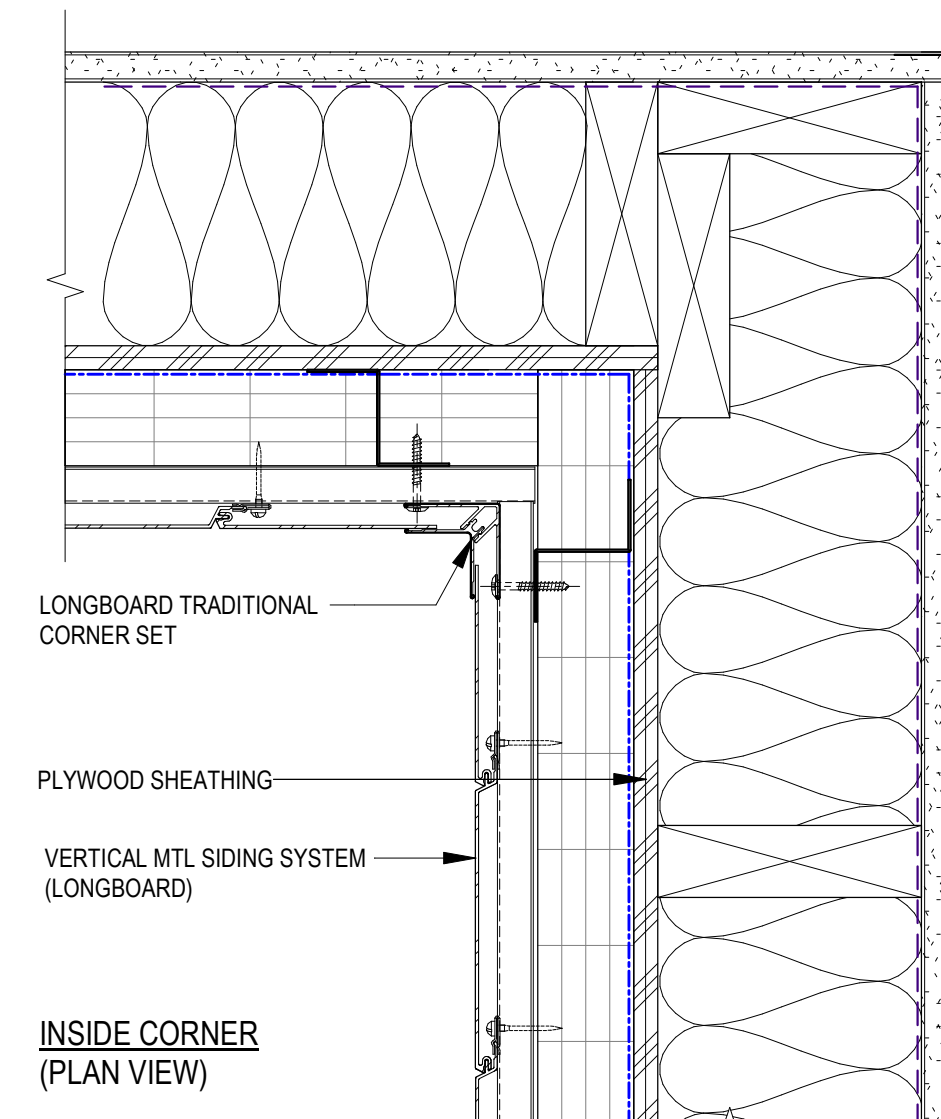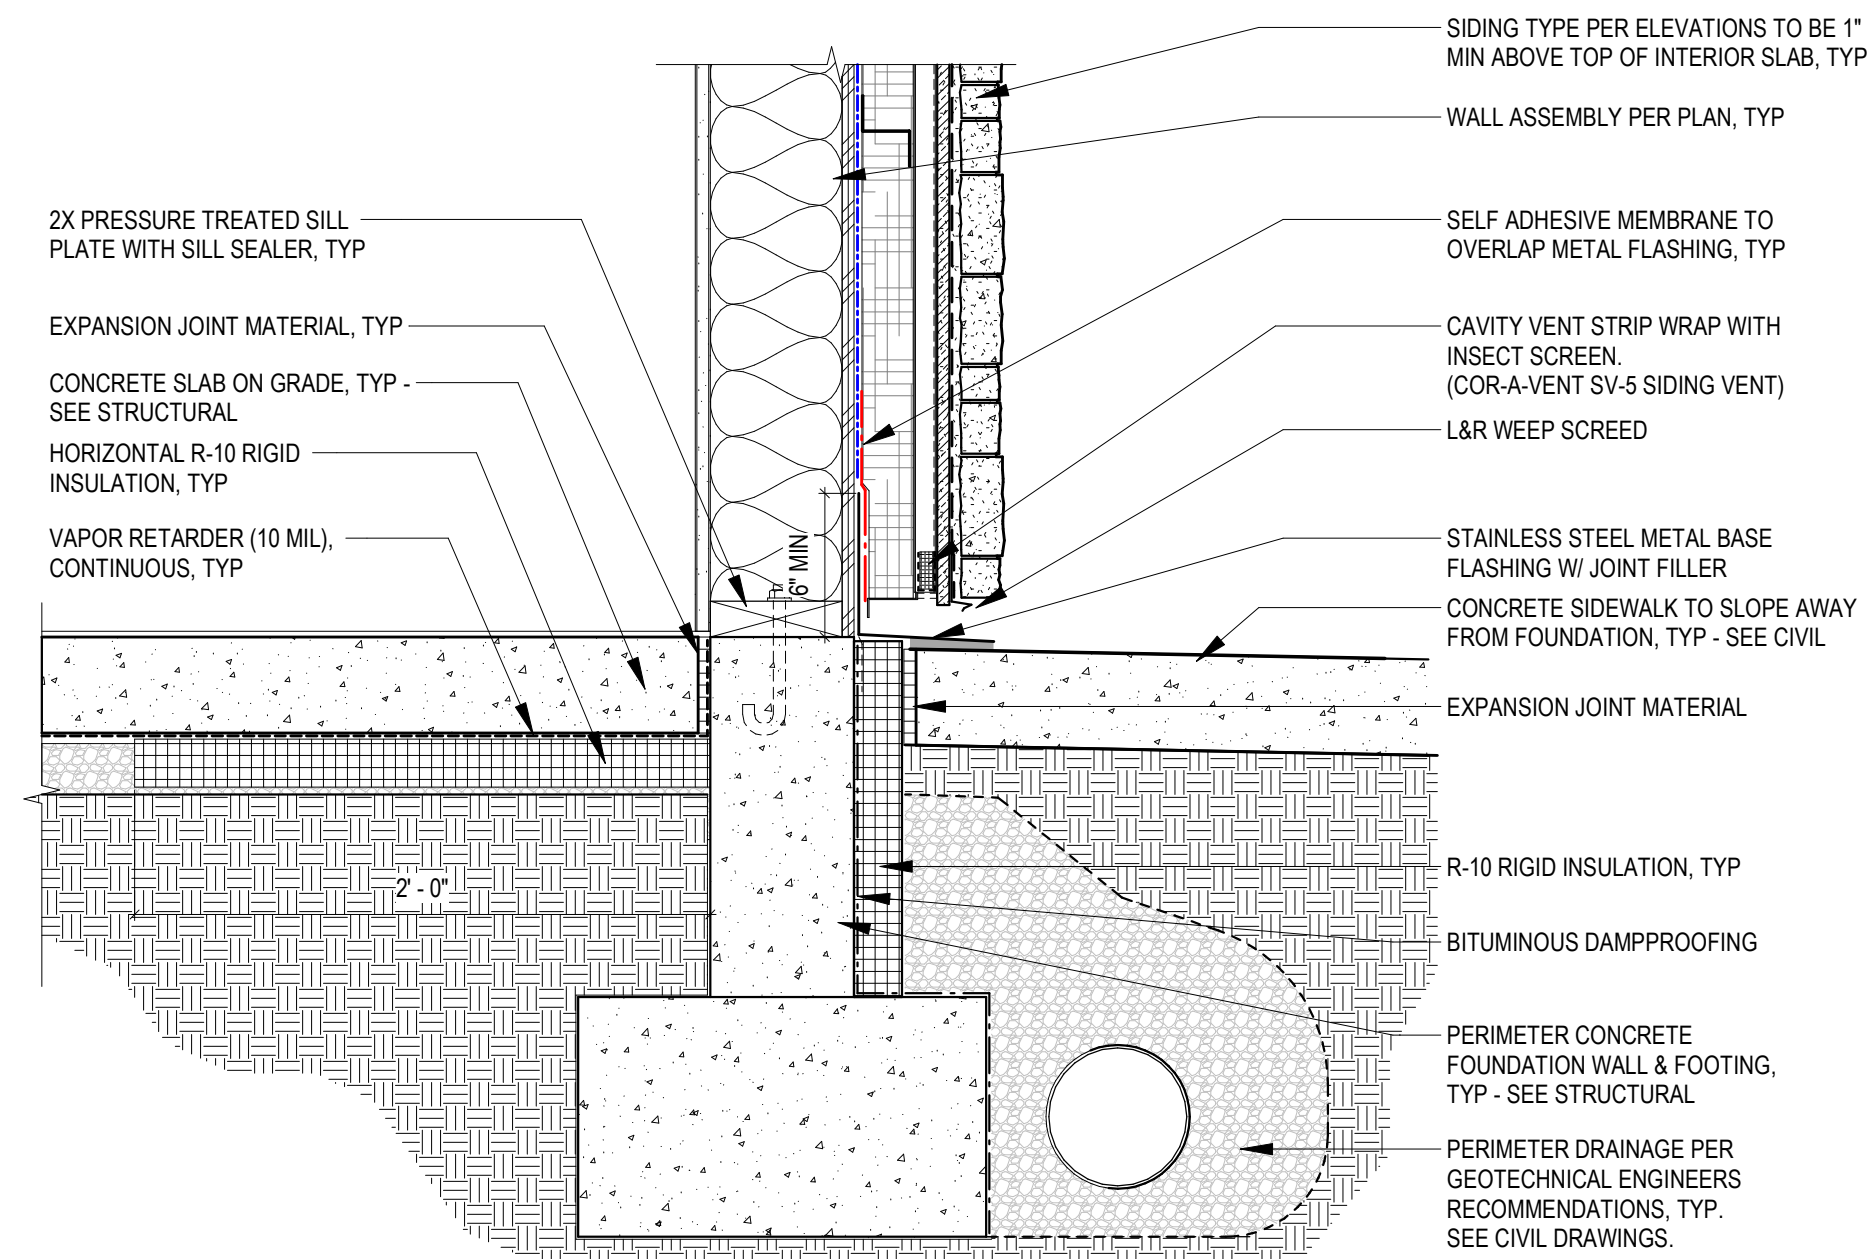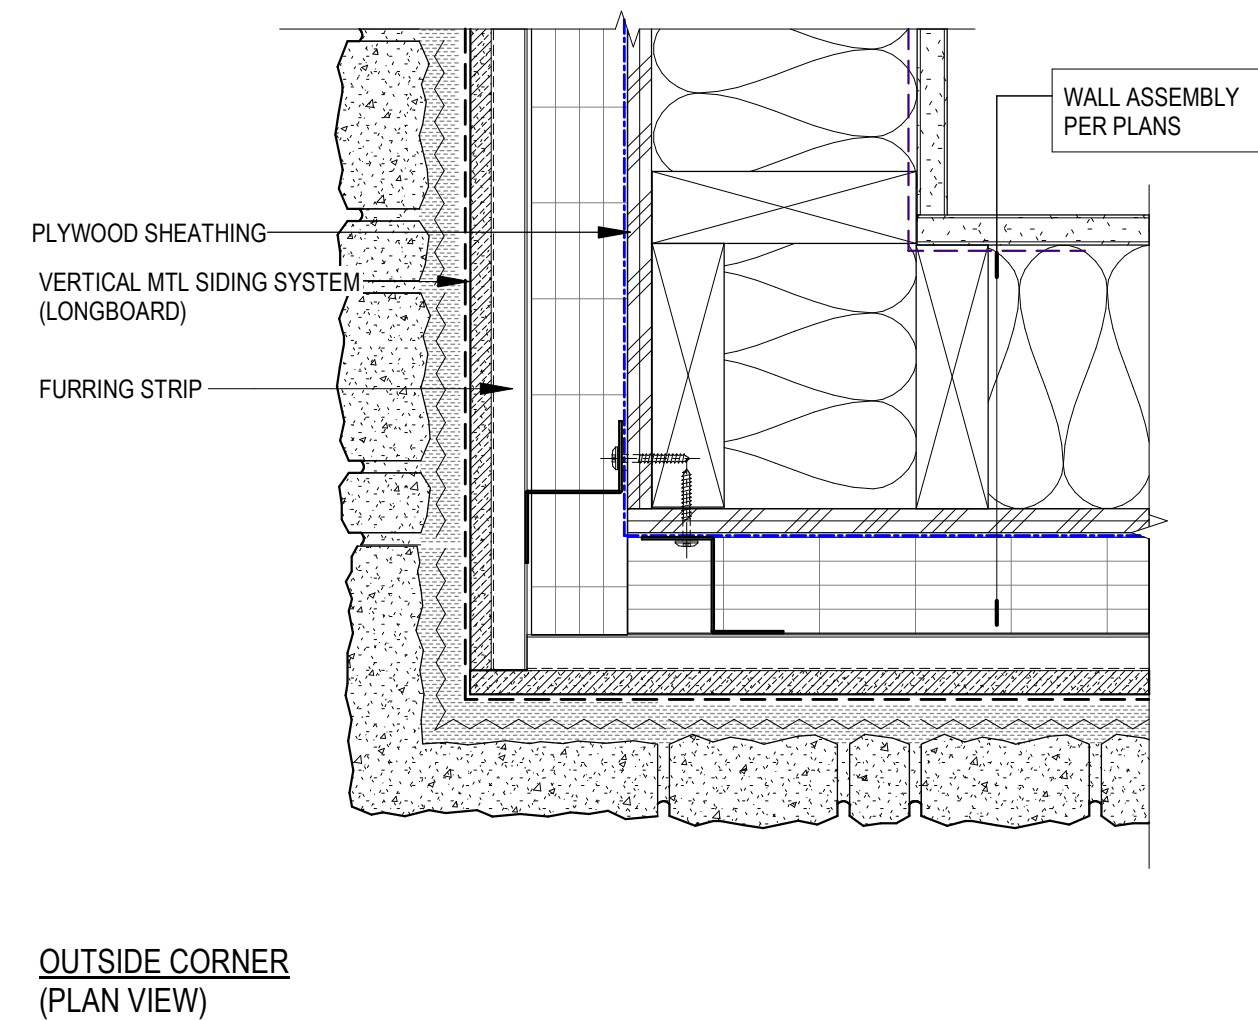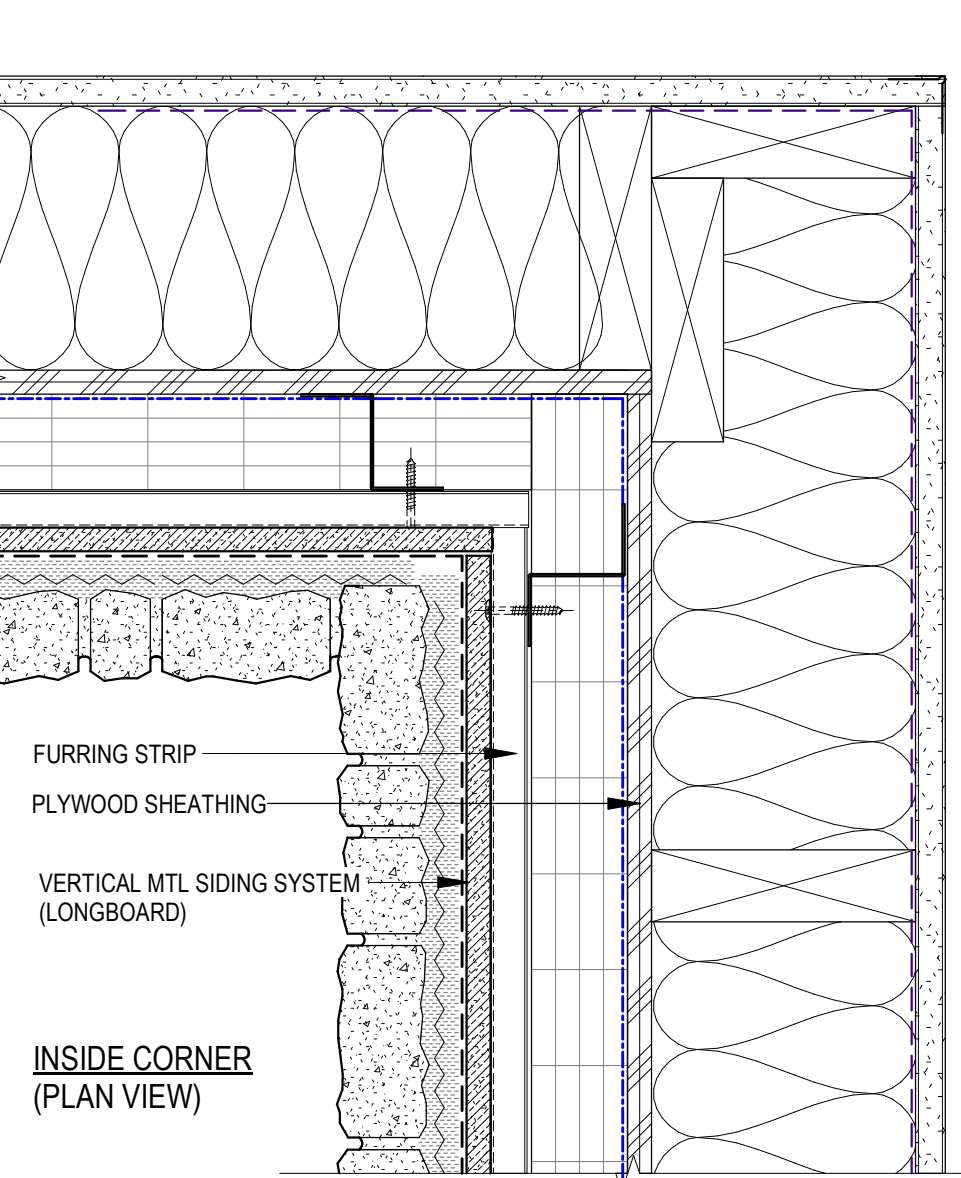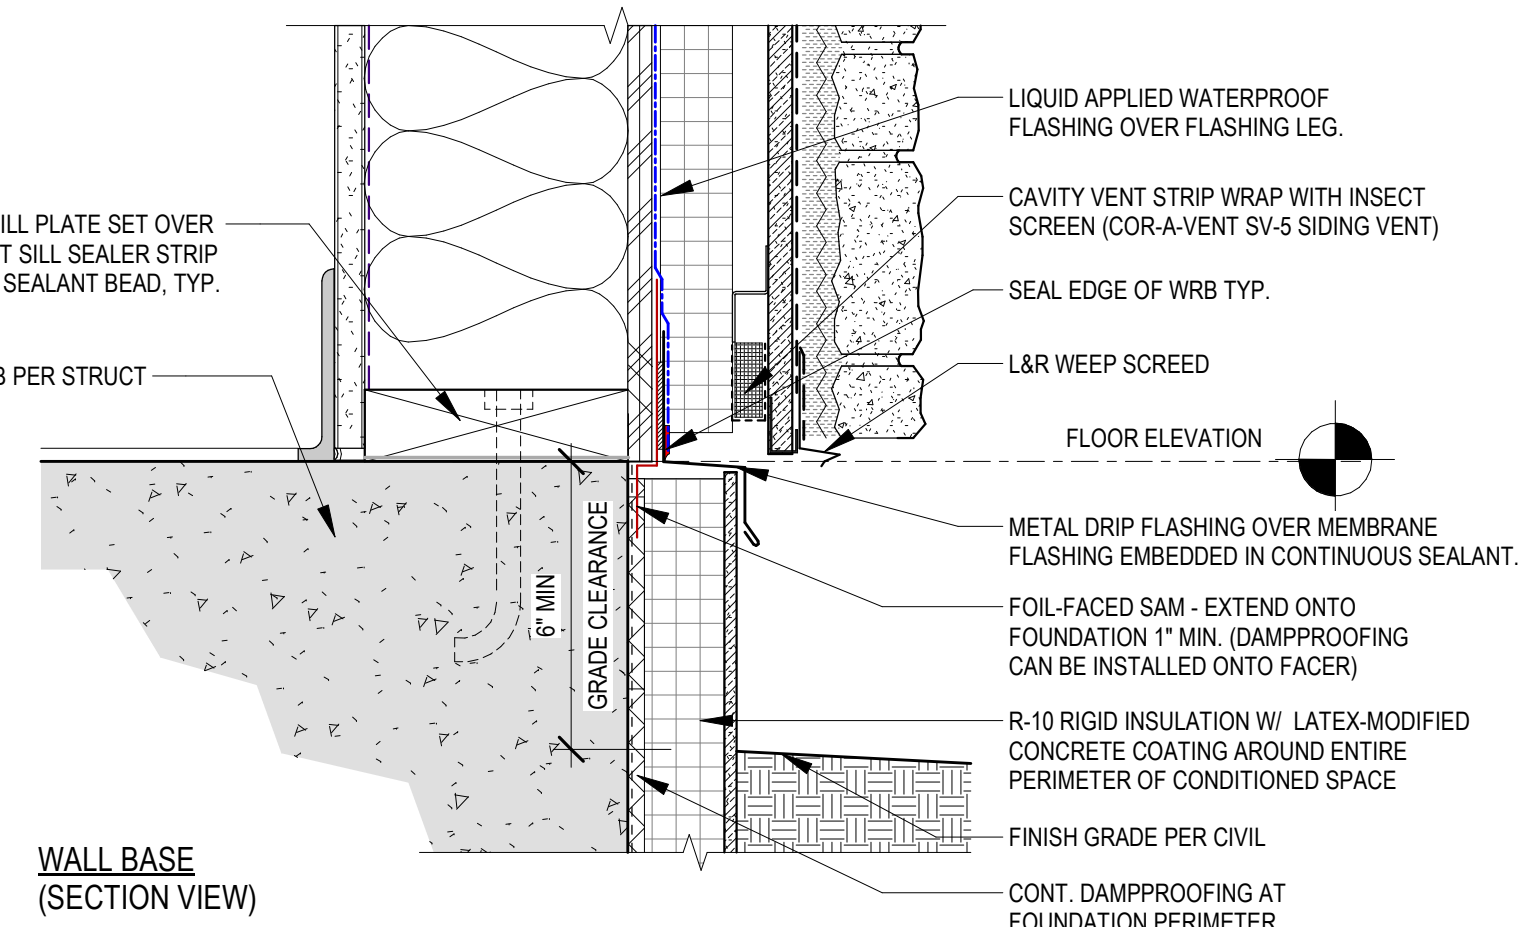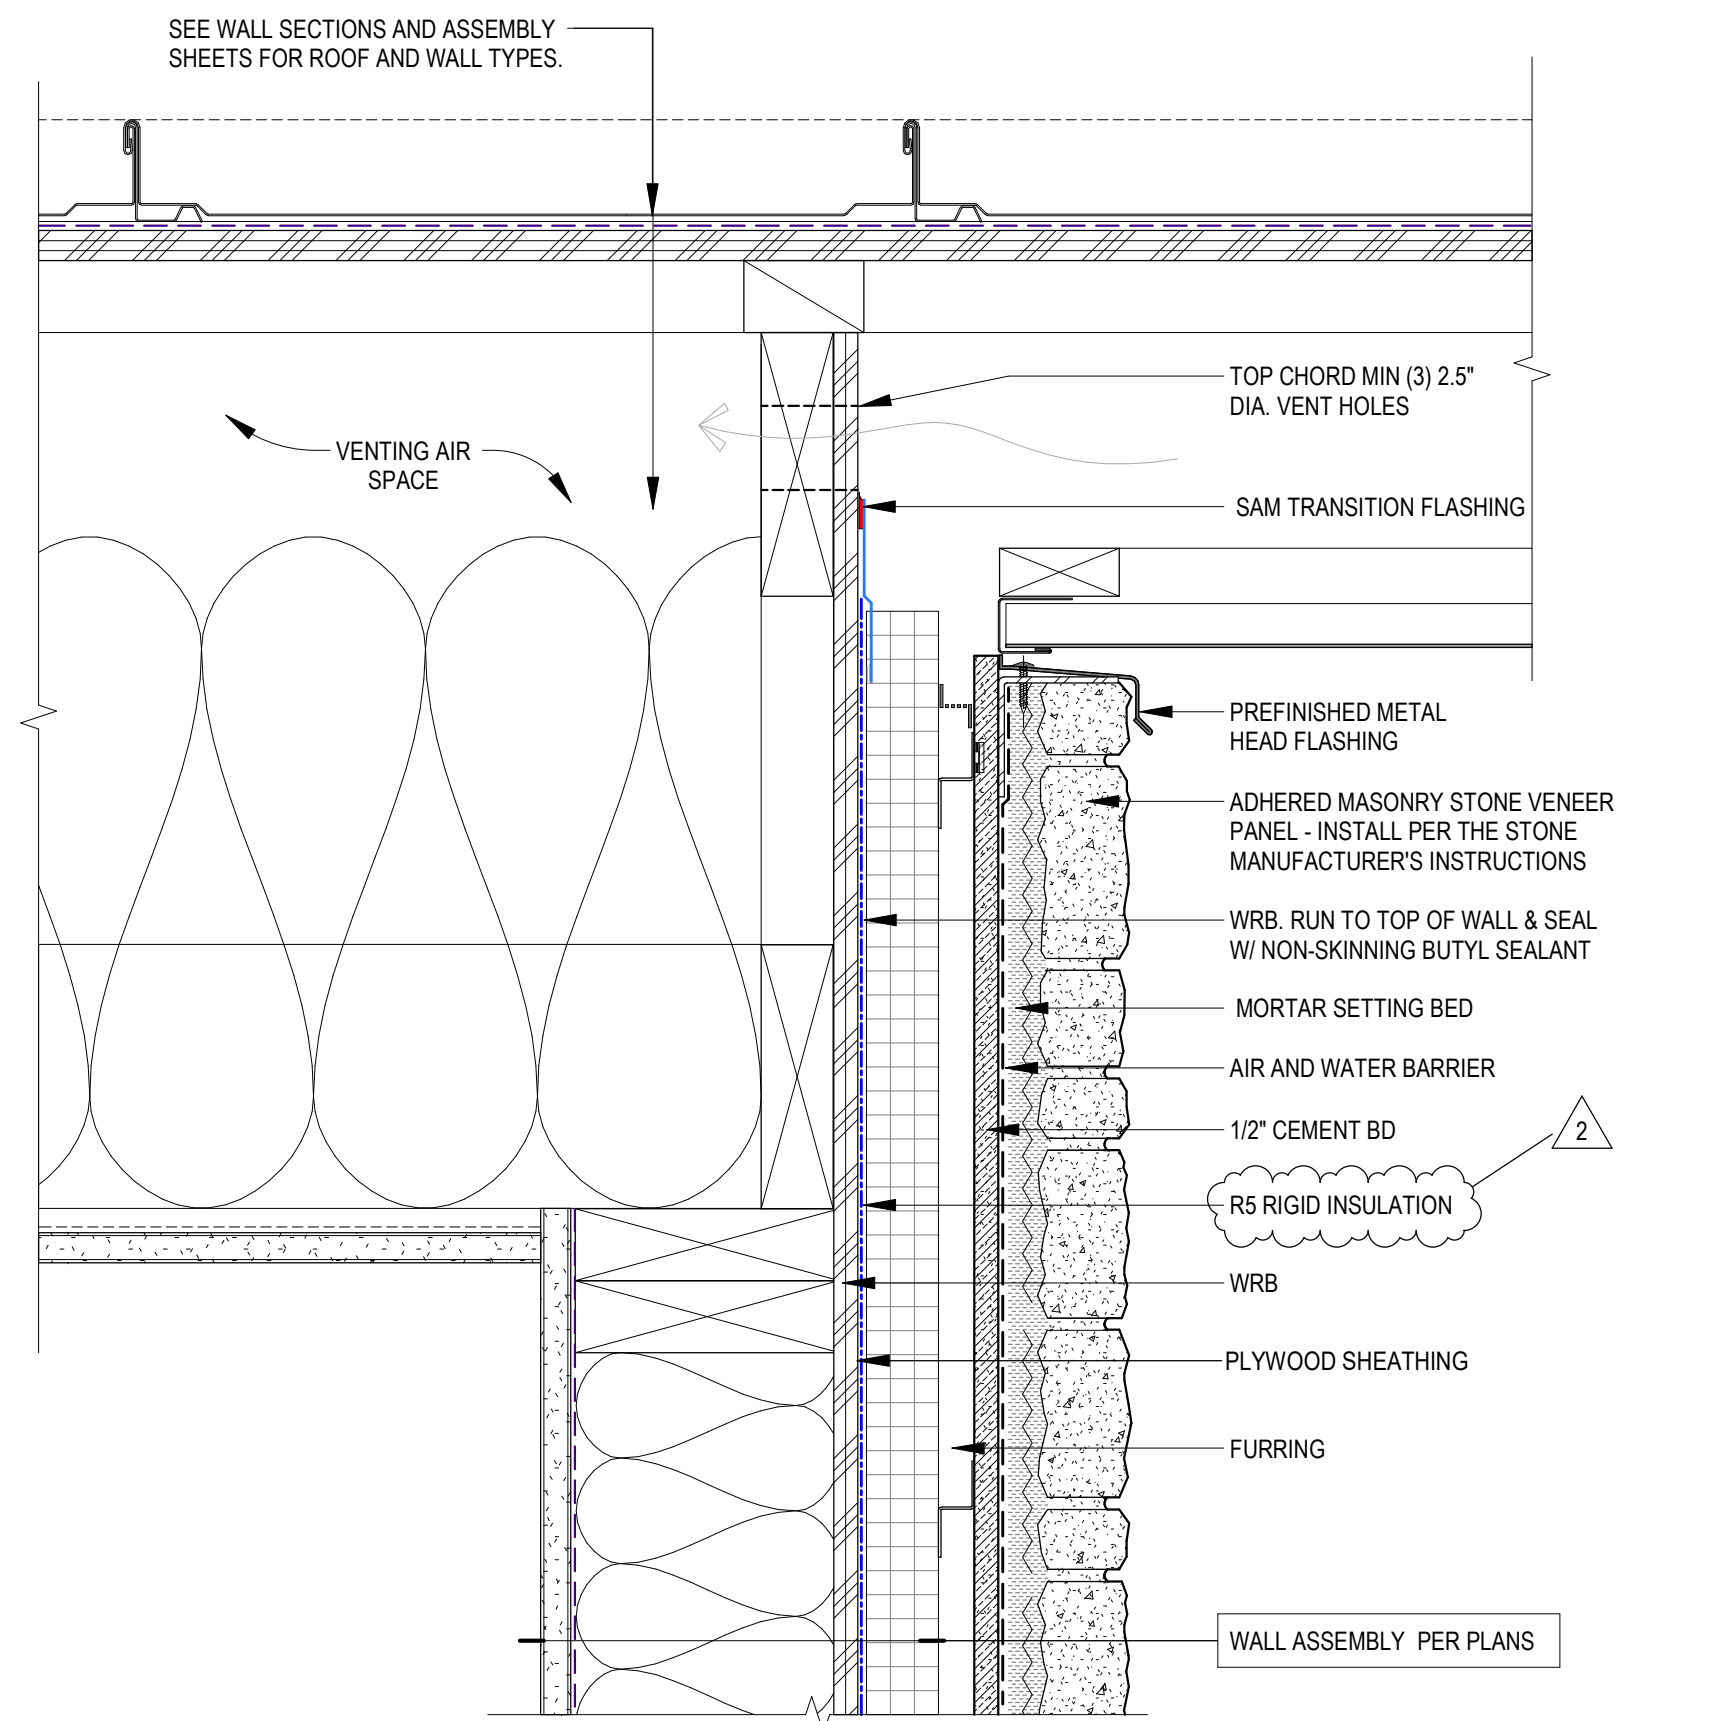

3

TYPICAL STONE DETAILS

3" = 1'-0"

2


TYPICAL FOOTING @ SIDEWALK

1 1/2" = 1'-0"


1

TYPICAL WOOD PANEL SYSTEM


3" = 1'-0"

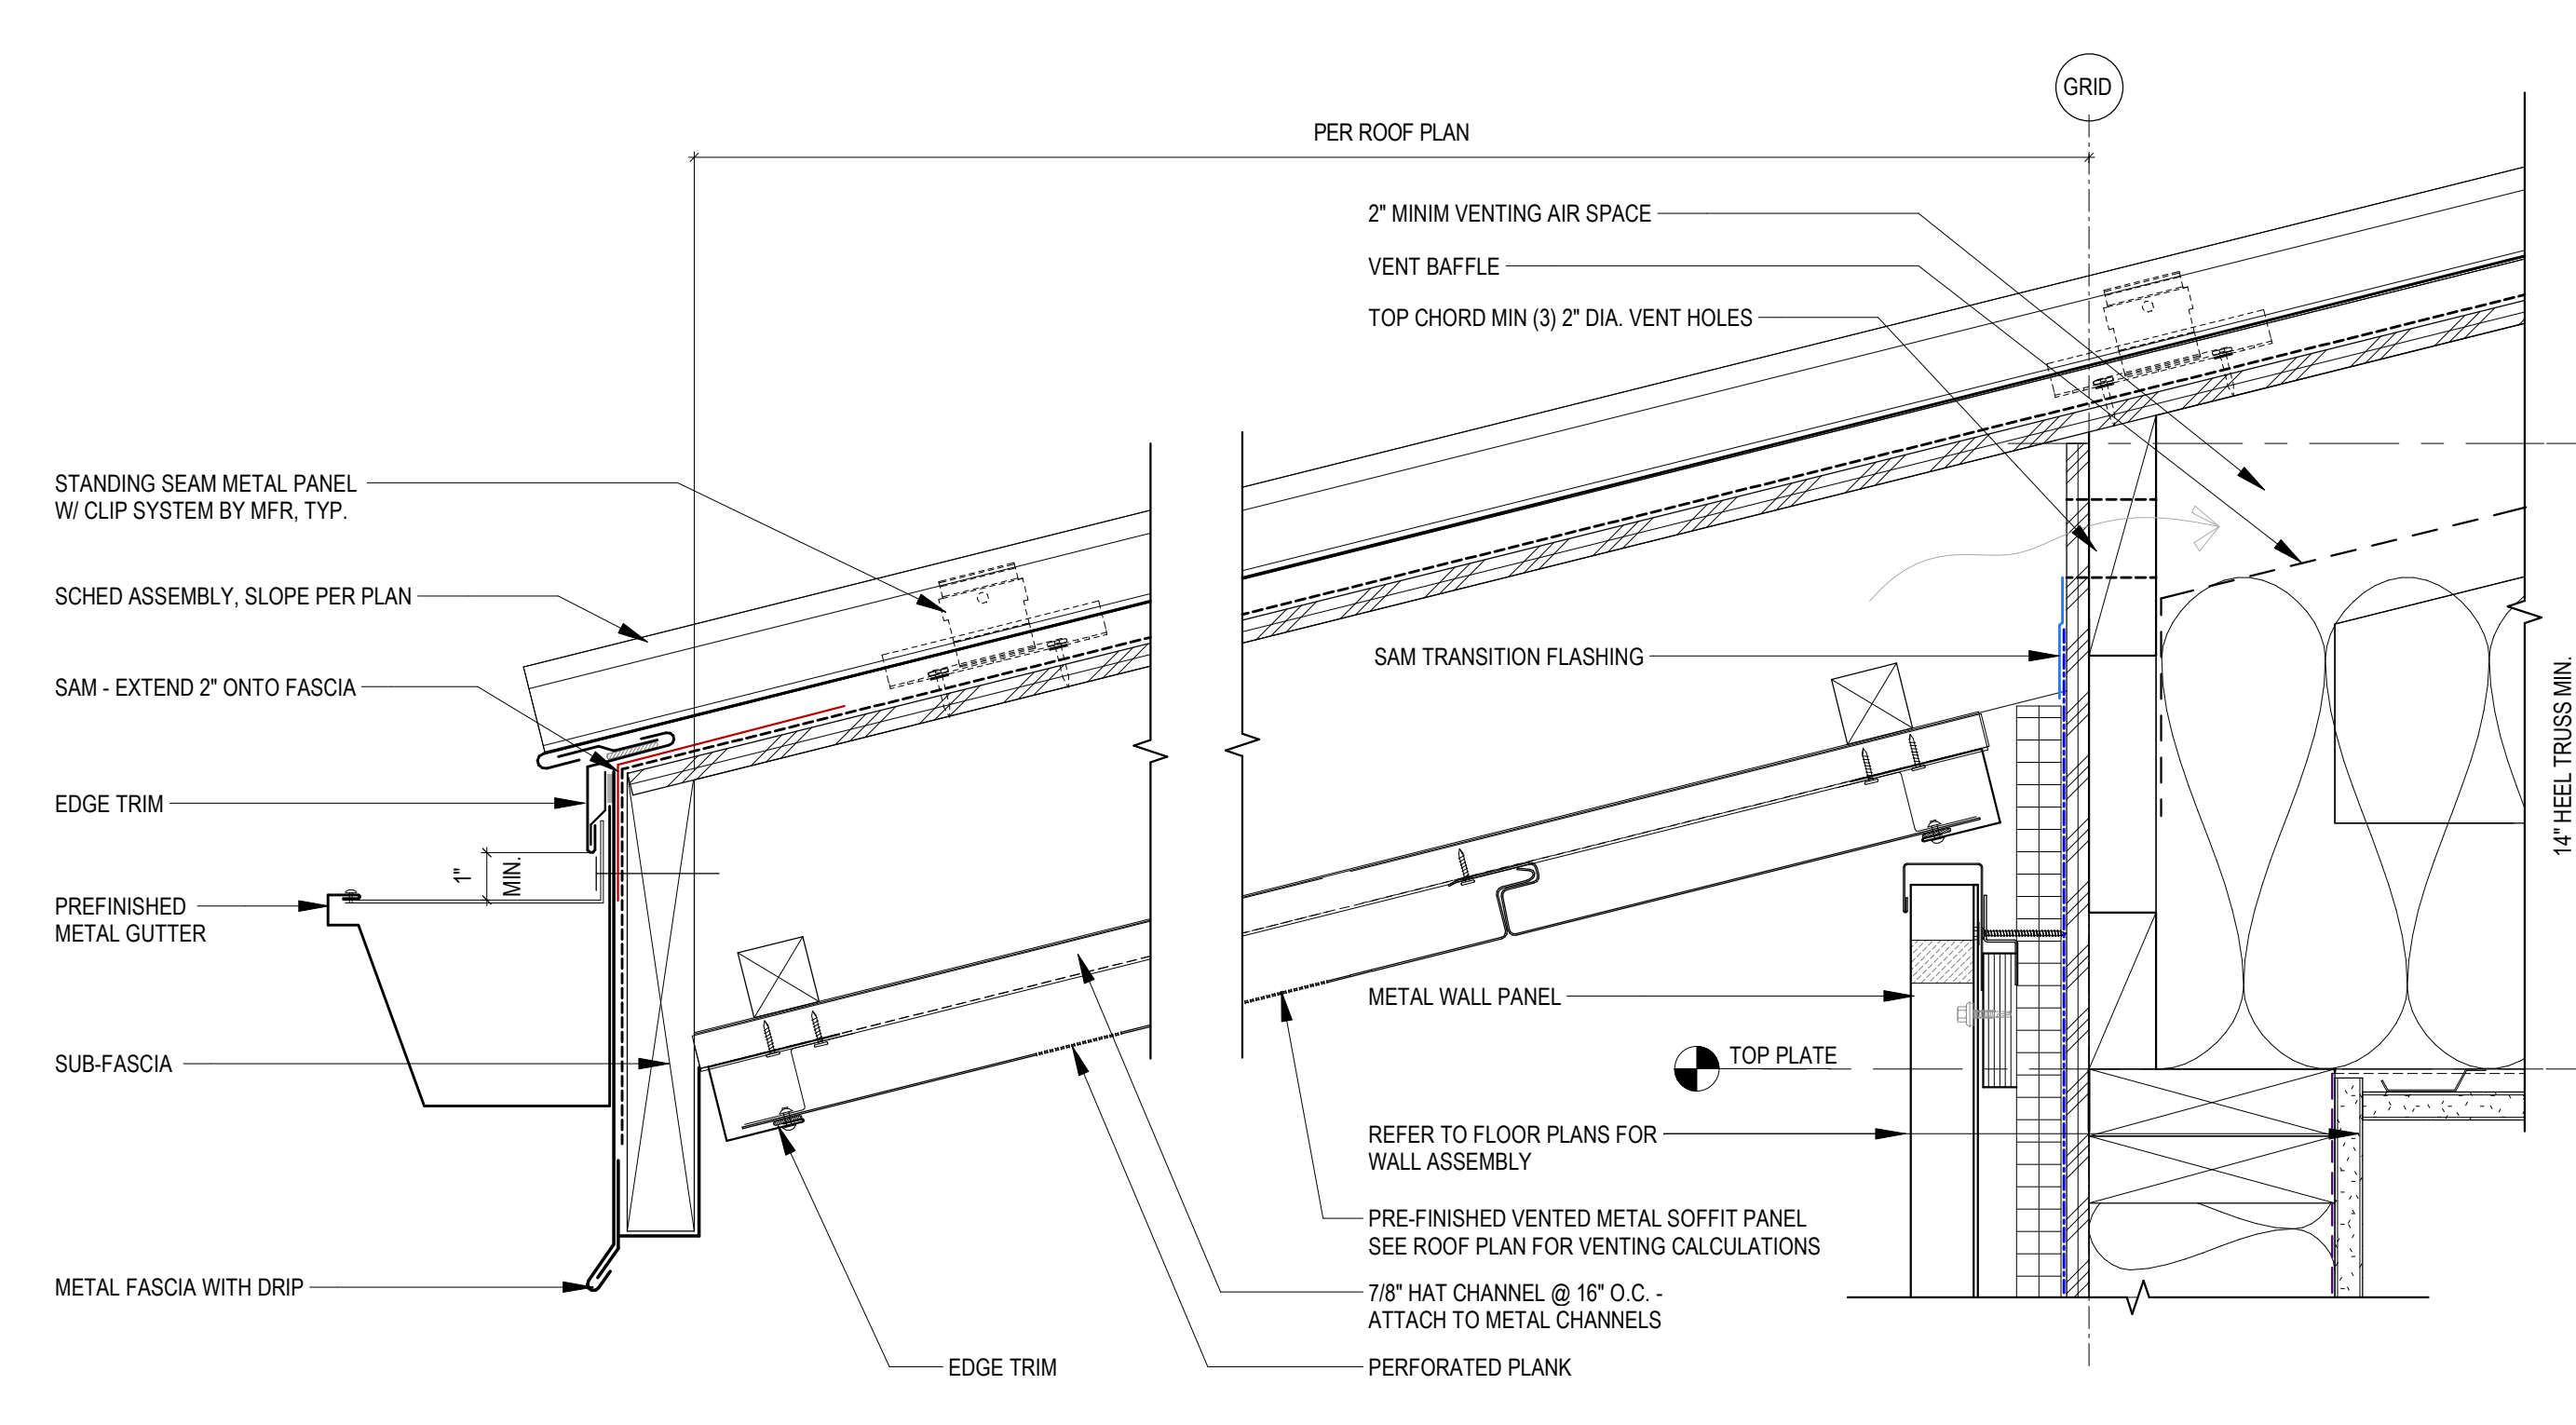

2 METAL SOFFIT DETAIL @ ROOF EAVE
3' = 1'-0"

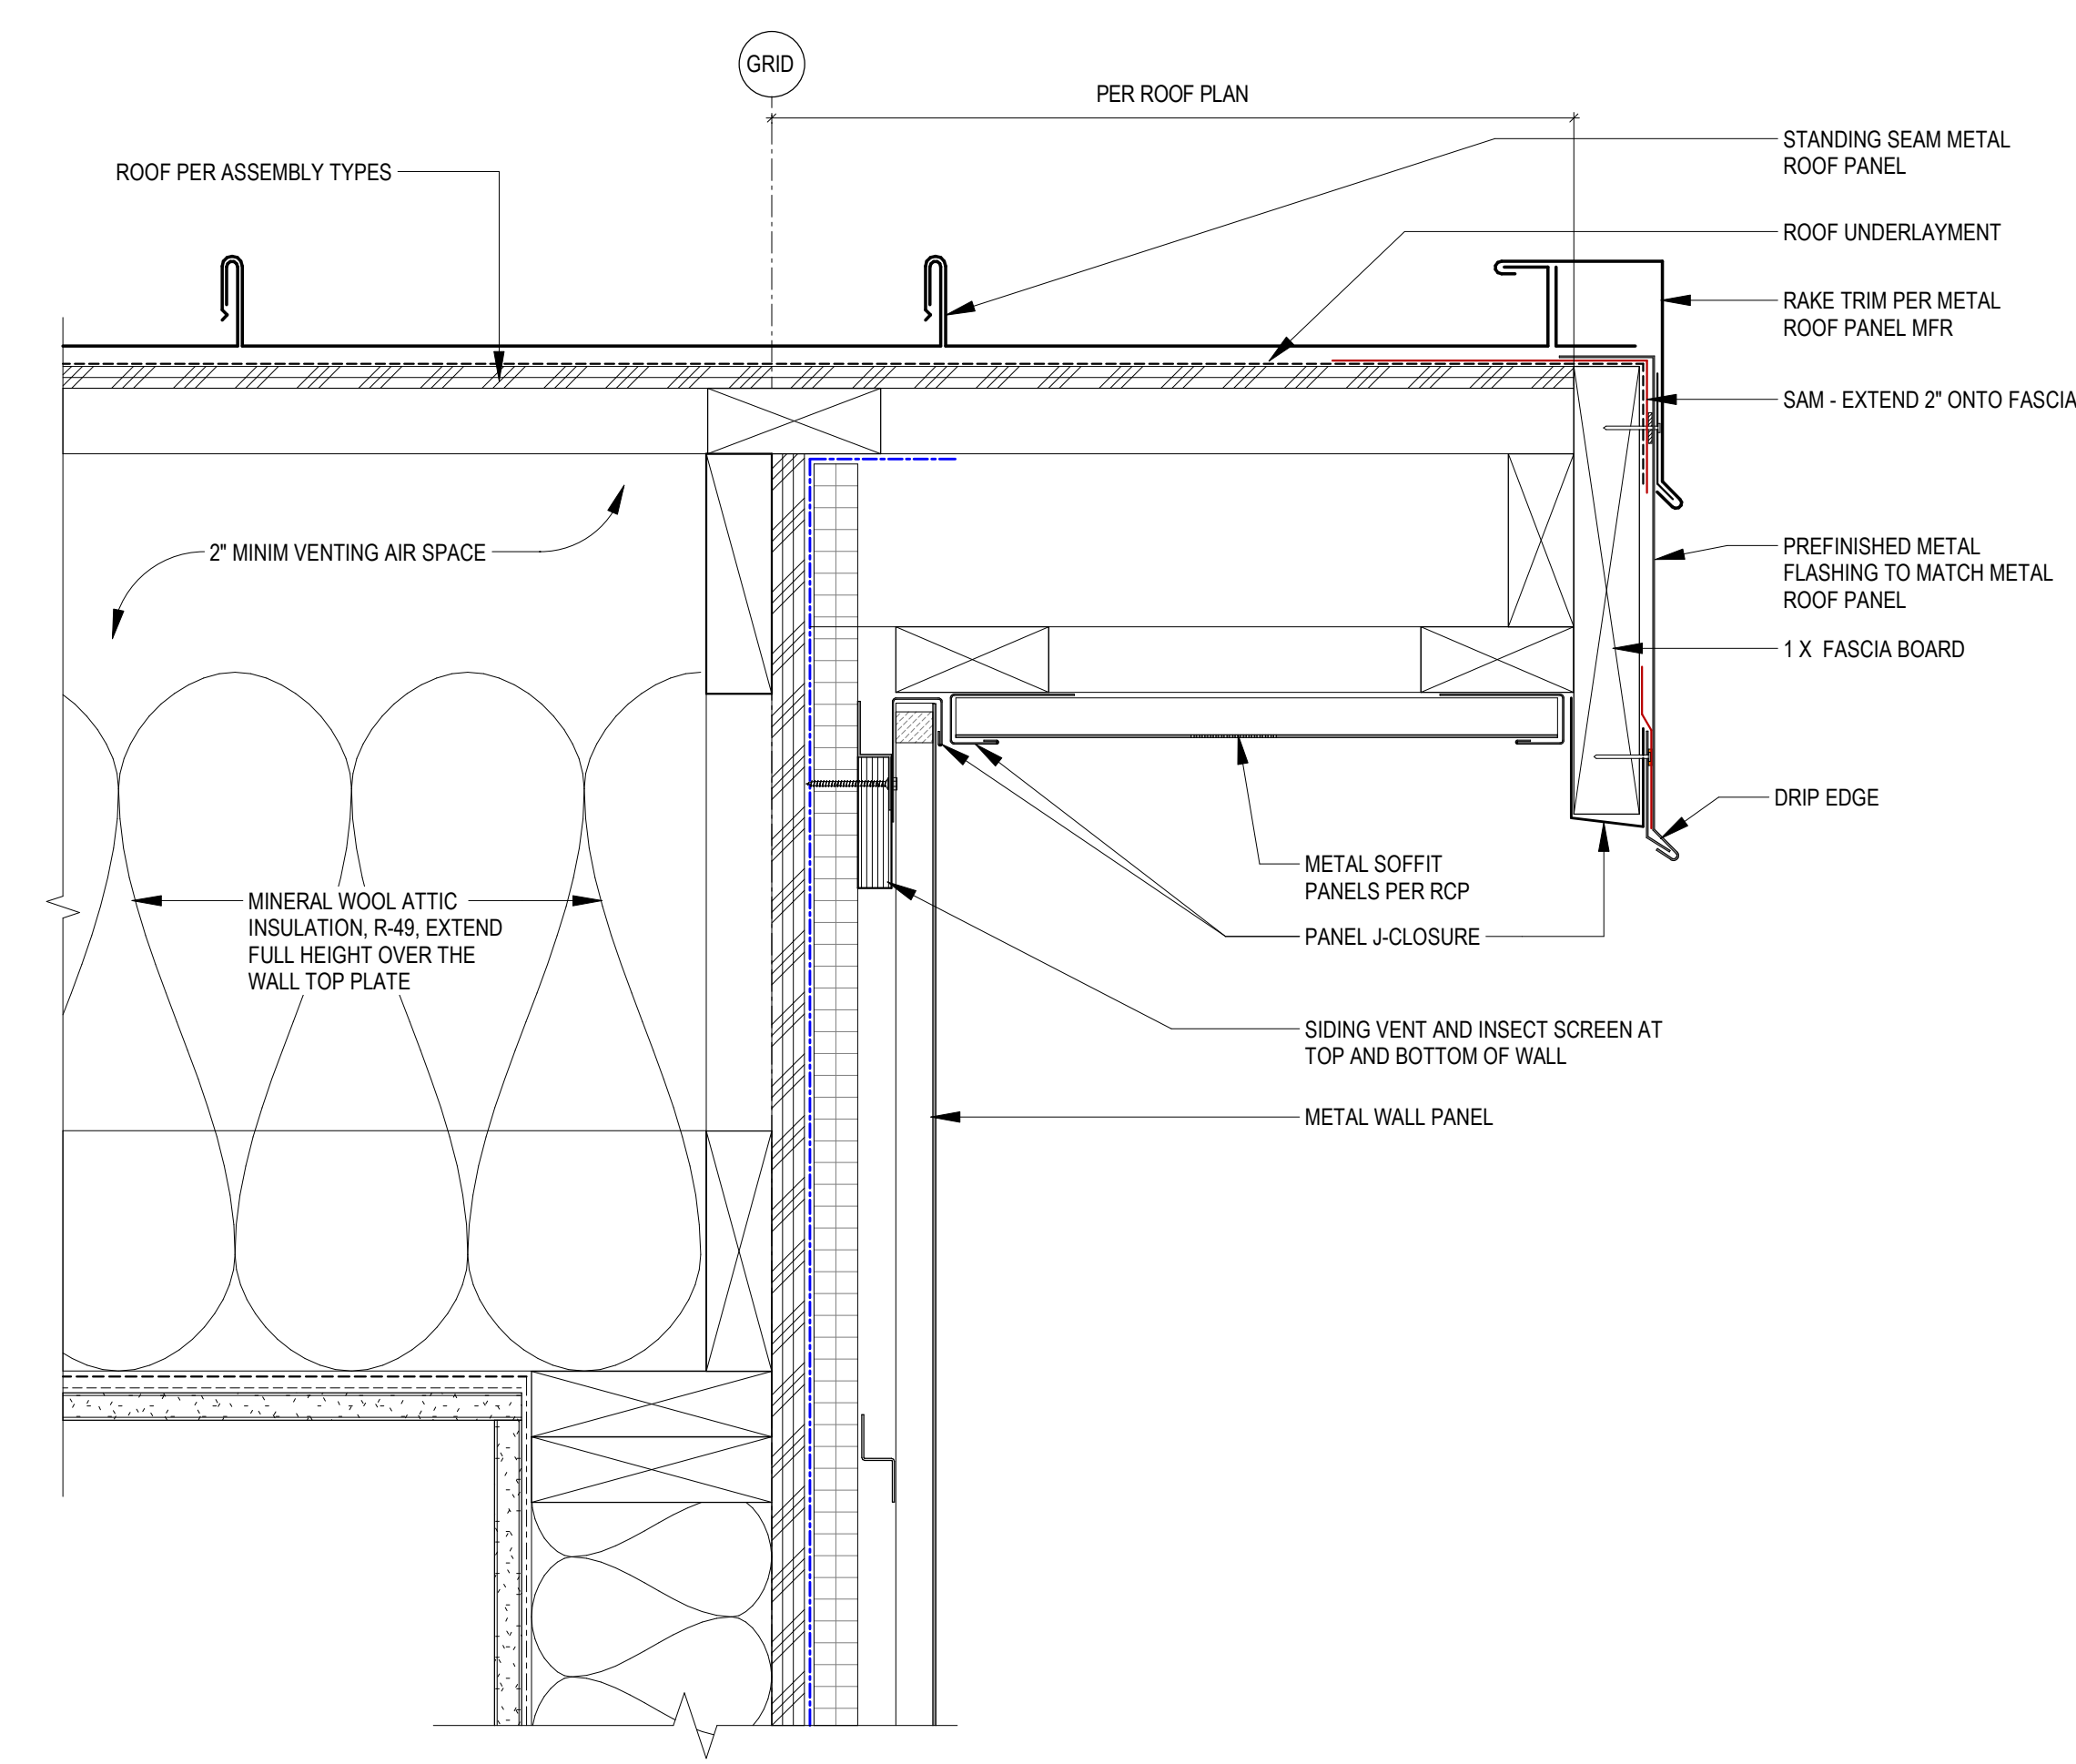


1 SECTION - ROOF RAKE @ VENTED ATTIC
3" = 1'-0"

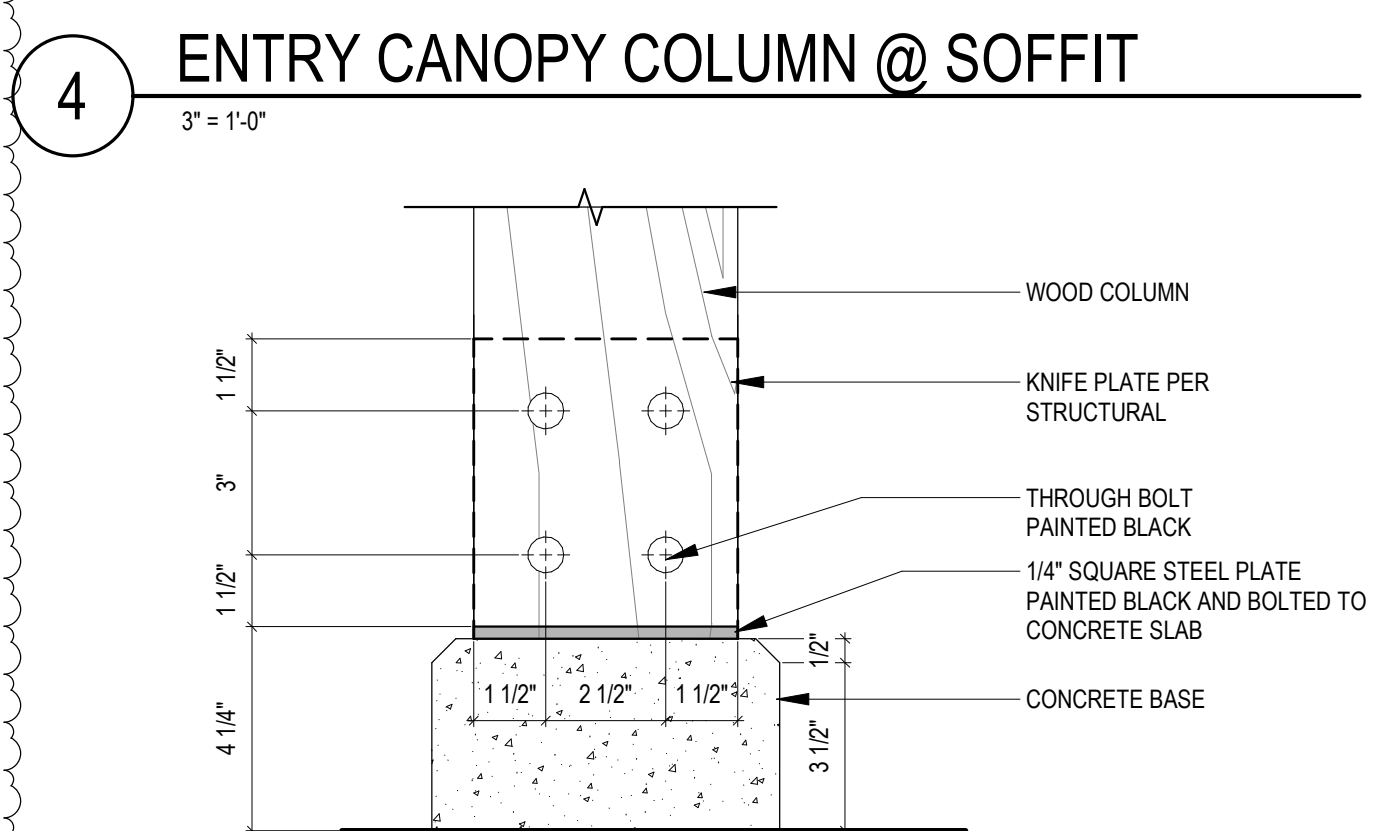

3 WOOD COLUMN BASE
3" = 1'-0"

AHJ APPROVAL STAMP

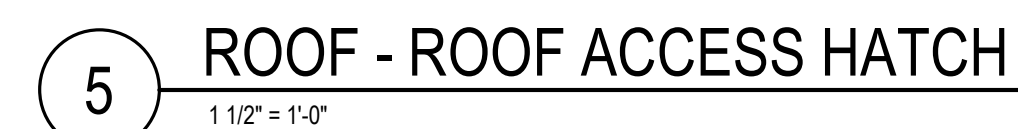



STONE VENEER PER ELEVATIONS

SELF ADHERING FLASHING LAPS OVER METAL FLASHING AND EXTENDS 3" MIN, TYP

SELF ADHERING MEMBRANE FLASHING WRAPS INTO F.O. AND OUT OVER WRB, TYP

PRE-FINISHED METAL HEAD FLASHING

SEALANT & BACKER ROD, TYP

HM FRAME

DOOR PER SCHEDULE

STONE VENEER PER ELEVATIONS

PRE-FINISHED METAL FLASHING

SEALANT & BACKER ROD, TYP

HM FRAME

DOOR PER SCHEDULE

DOOR PER SCHEDULE

DOOR THRESHOLD SET IN BED OF LIQUID FLASHING

LIQUID FLASHING

METAL FLASHING

FINISHED FLOOR

CONC. SLAB PER STRUCT.

MTL SIDING

PLYWD SHEATHING PER STRUCT

PRE-FINISHED MTL FLASHING

1/4" W SEALANT

EXTERIOR

INSULATION PER WALL SECTION & ASSEMBLY TYPES

INT FINISH PER FINISH SCHEDULE

VAPOR RETARDER

INSULATION & WD STUD SIZE PER WALL SECTION & ASSEMBLY TYPES

SEE FRAME TYPES

HOLLOW METAL FRAME

DOOR PER DOOR SCHEDULE

Diagram illustrating the cross-section of a door assembly, showing the following components and labels:

- R10 RIGID INSULATION WHERE OCCURS PER WALL TYPES
- HOLLOW METAL FRAME
- DOOR PER DOOR SCHEDULE
- 1" HORIZ VENTED Z-GIRT
- MTL-1 SIDING
- 14" W SEALANT
- PRE-FINISHED MTL FLASHING
- 14"
- PRE-FINISHED MTL J-TRIM. COLOR TO MATCH W/ SIDING

Diagram illustrating the cross-section of a door threshold assembly, showing the exterior and interior components and their relationship to the concrete slab and floor finish.

Labels and components shown:

- EDGE OF HM FRAME BEYOND
- THRESHOLD SET IN SEALANT
- FLOORING PER FINISH SCHEDULE
- CONC. SLAB PER STRUCT.
- EXTERIOR
- DOOR PER SCHEDULE
- DOOR THRESHOLD SET IN BED OF SEALANT OVER LIQUID FLASHING
- METAL FLASHING
- 1/2" MAX

1 EXTERIOR HM DOOR THRESHOLD DETAIL
3" = 1'-0"

EKLUND AT GALES
PENINSULA HOUSING AUTHORITY
2372 E 7TH AVENUE
PORT ANGELES, WAS 98362

PROJECT # 2023093.02

PERMIT SET

ISSUE DATE JULY 26, 2026

REVISION SCHEDULE


2 ADDENDUM #2 08/21/2026

AHJ APPROVAL STAMP


INTERIOR SECTION
DETAILS

SHEET #


A71.01

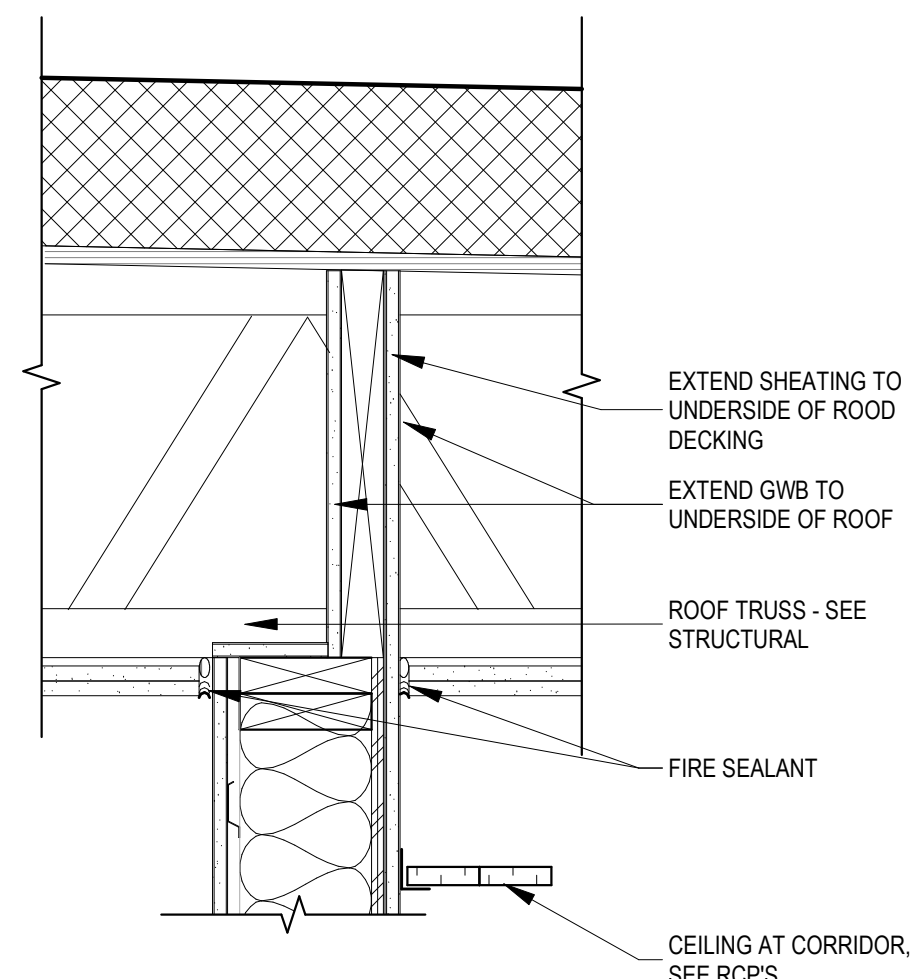


9 CORRIDOR WALL @ ROOF
1 1/2" = 1'-0"

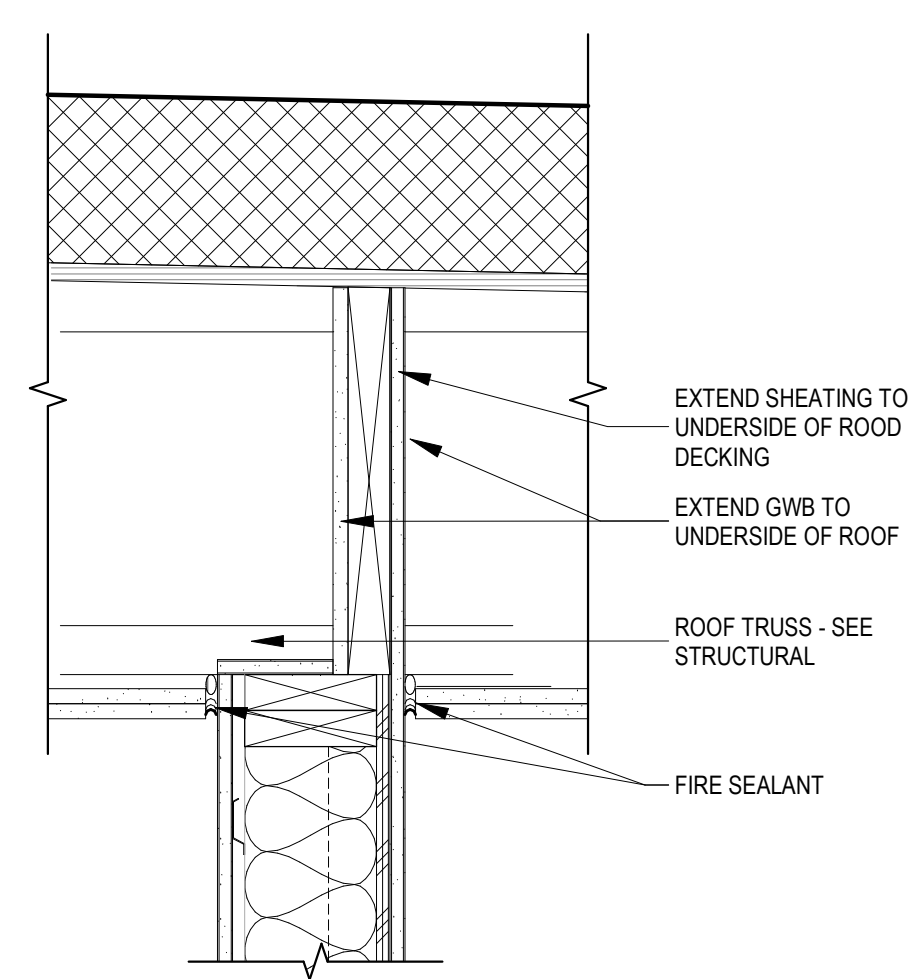


6 DEMISING WALL @ ROOF
1 1/2" = 1'-0"

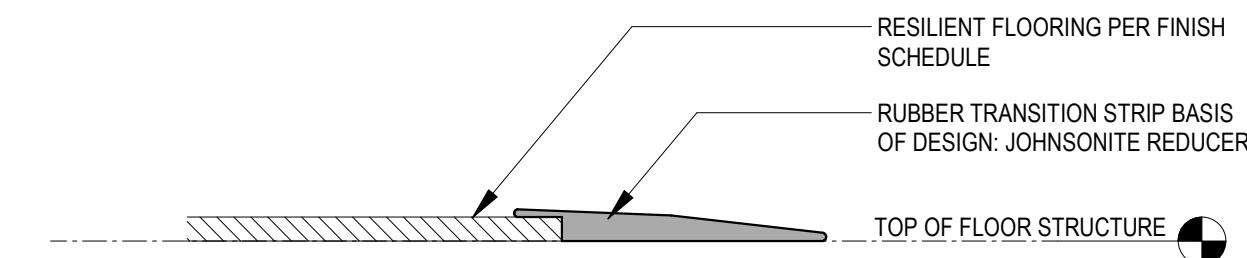


3 RESILIENT TO FLOOR STRUCTURE
12" = 1'-0"

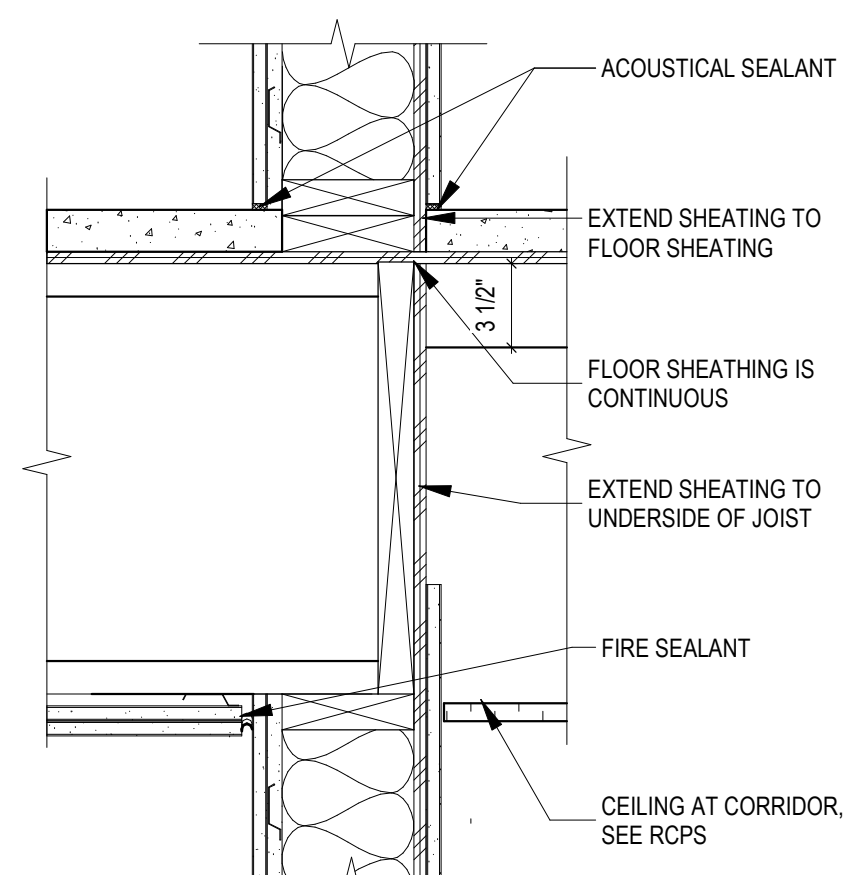


8 CORRIDOR WALL AT LEVEL 1 FLOOR
1 1/2" = 1'-0"

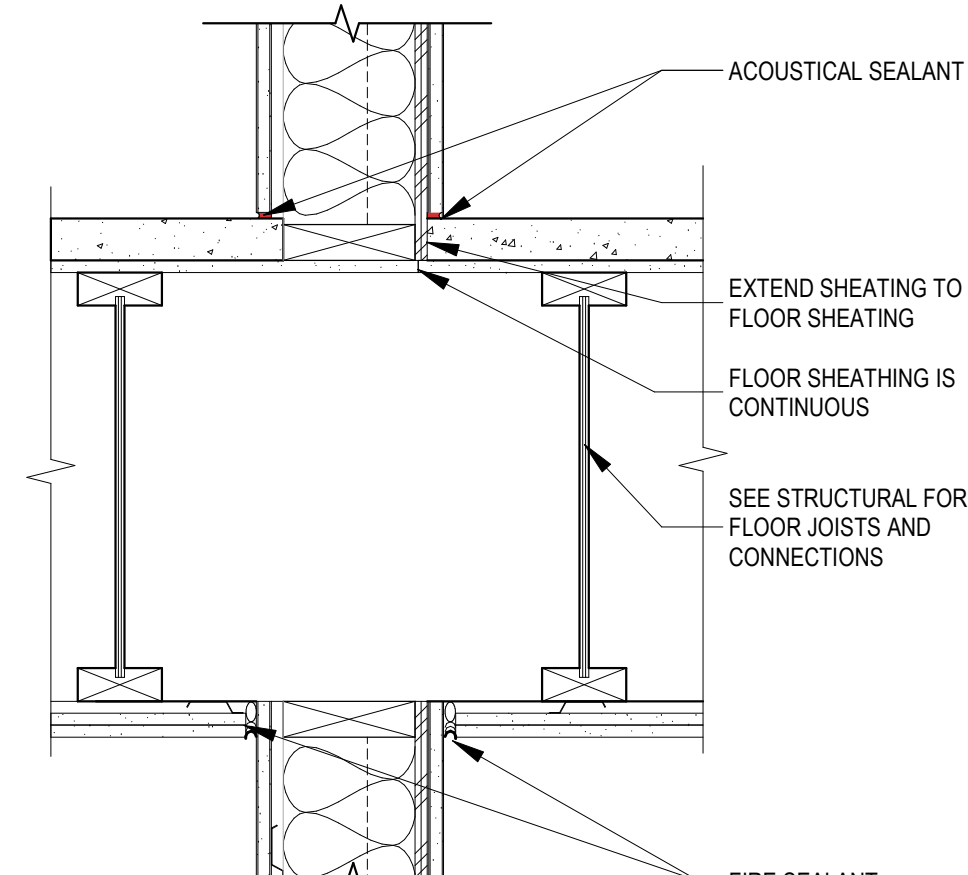


5 DEMISING WALL AT FLOOR
1 1/2" = 1'-0"

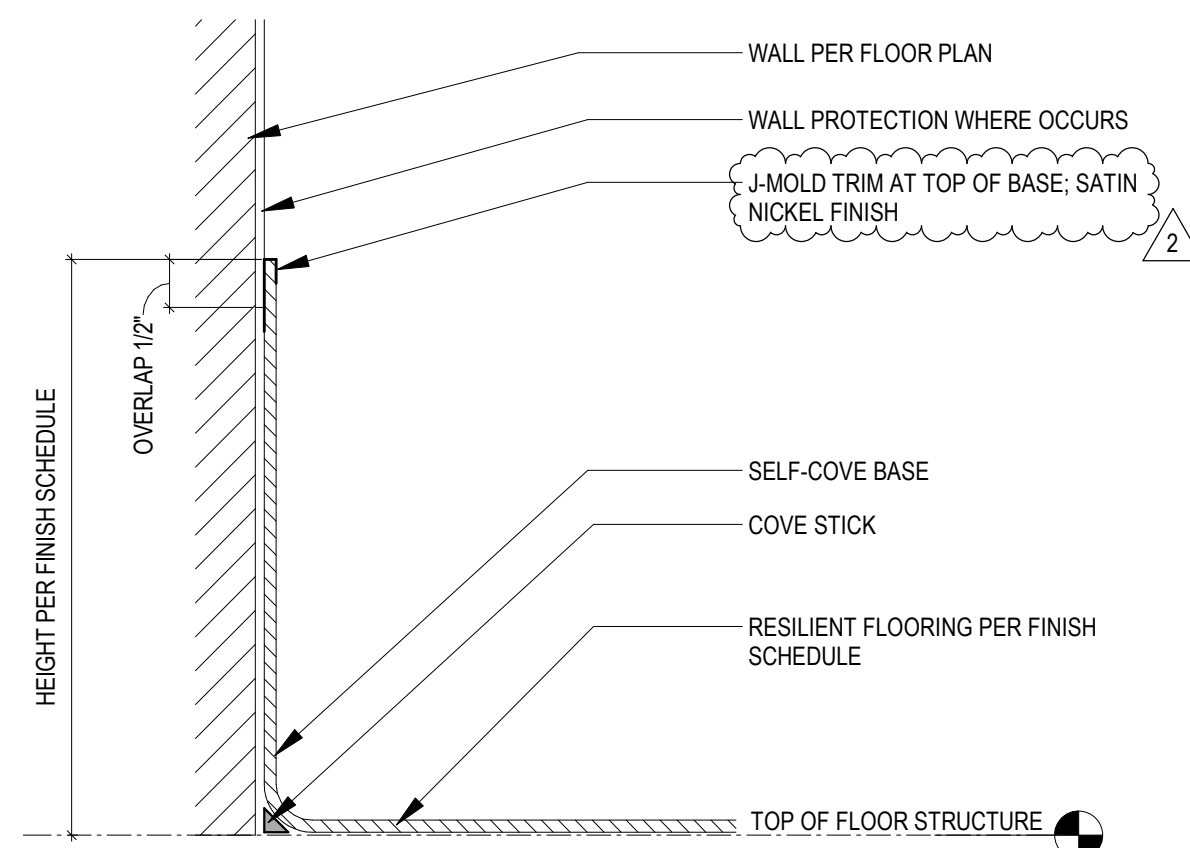


2 RESILIENT COVE BASE
6" = 1'-0"

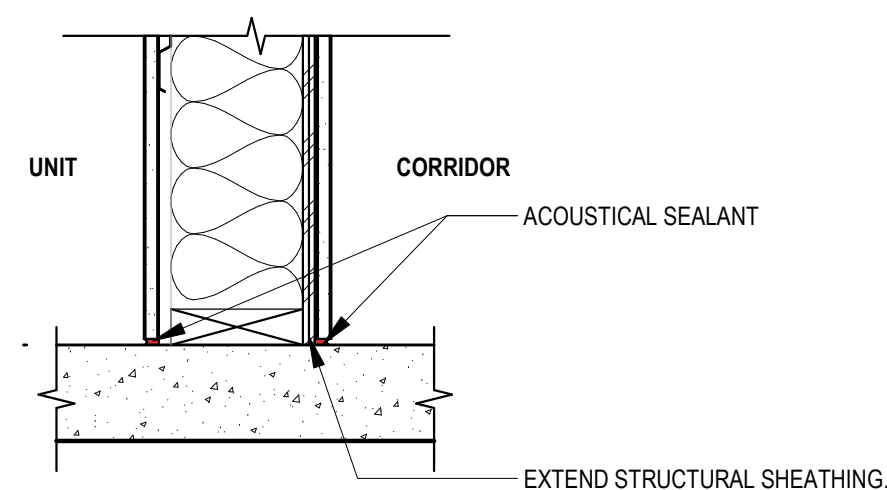

7 CORRIDOR WALL AT SLAB
1 1/2" = 1'-0"

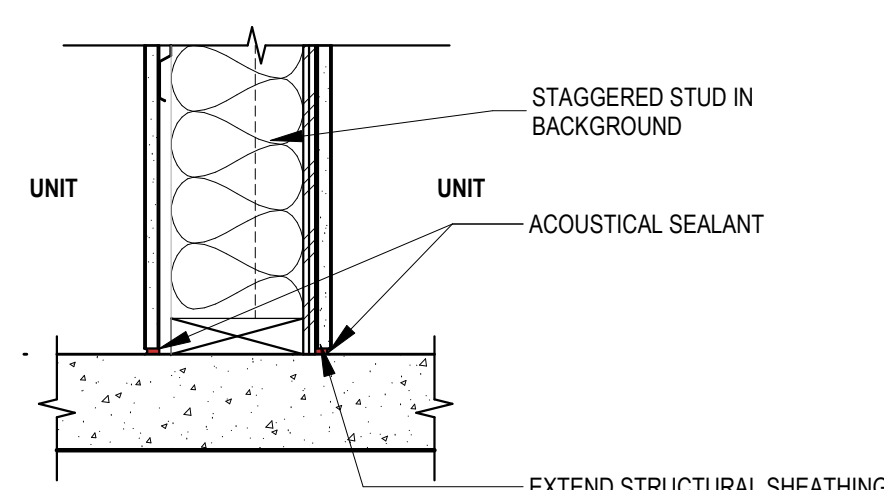

4 DEMISING WALL AT SLAB
1 1/2" = 1'-0"

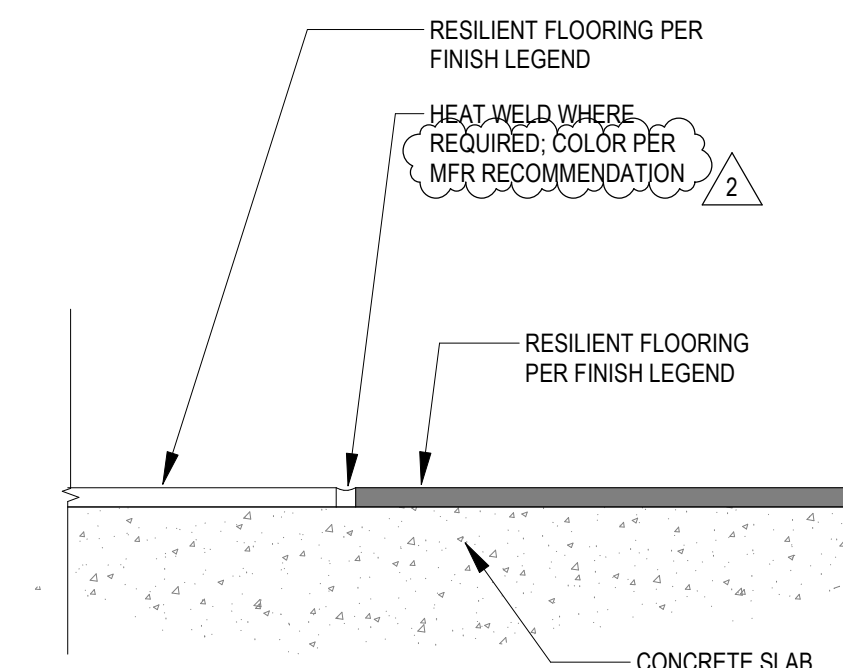

1 FLOORING TRANSITION - RESILIENT TO RESILIENT
12" = 1'-0"

1. SEE INTERIOR ELEVATIONS FOR COUNTERTOP AND CABINET MATERIAL FINISHES.
2. SEE INTERIOR ELEVATIONS FOR DOOR AND/ OR DRAWER LOCK LOCATIONS.
3. BACKSPLASH MATERIAL TO MATCH COUNTERTOP MATERIAL UNO.
4. INSTALL FLOORING BEFORE CASEWORK.
5. SCRIBE COUNTERTOPS AND CABINETS TO WALL SURFACES.
6. PROVIDE MARINE GRADE PLYWOOD TOE BOX UNO.
7. PROVIDE 120" CONCEALED HINGES AT DOORS UNO.
8. REMOVE PLUMB EXTENSION GLIDES AT DRAWERS UNO.
9. PROVIDE 96 MM WIRE PULLS AT DOORS AND DRAWERS UNO, FINISH: SATIN NICKEL. UNIT PULLS PER UNIT EQUIPMENT
10. PROVIDE IN-WALL BLOCKING BEHIND CABINETS
11. PROVIDE CONCEALED COUNTERTOP SUPPORT BRACKETS UNO.

